




2KM ARCHITECTS, INC.
 REGISTERED PROFESSIONAL ENGINEER
 MICHAEL C. MORSE
 NO. 25107
 12-07-20
 529 GREENE ST., AUGUSTA, GA. 30901
 (706) 726-3333 • FAX (706) 726-7100

This document is the property of 2KM Architects, Inc. The unauthorized reproduction, copying, or otherwise use of this document is strictly prohibited and any infringement thereon may be subject to legal action. Copyright © 2020, 2KM Architects, Inc.

- GENERAL NOTES:**
- UNLESS OTHERWISE INDICATED, ALL EQUIPMENT SHOWN IS INTENDED TO BE A ONE FOR ONE REPLACEMENT OF THE EXISTING UNIT. A NEW FLEXIBLE CONNECTION AND FUSES SHALL BE PROVIDED FOR ALL EQUIPMENT REPLACED. PROVIDE NEW DISCONNECTS FOR ALL ROOF TOP (RTU) UNITS. SEE MECHANICAL CONNECTION SCHEDULE ON SHEET E2.3 FOR MORE DETAILED INFORMATION.
 - THE ELECTRICAL DRAWINGS ARE ONLY A PART OF THE CONTRACT DOCUMENTS. ALL OF THE DRAWINGS AND SPECIFICATIONS MUST BE REVIEWED FOR THEIR INTERRELATIONSHIP AND REQUIRED COORDINATION BETWEEN DISCIPLINES.
 - ALL CONDUIT ROUTED FROM DISCONNECT TO EXTERIOR HVAC UNITS SHALL BE ROUTED UNDERGROUND, TURN UP ADJACENT TO UNIT AND MAKE TRANSITION TO SEALTITE TO SERVE UNIT.

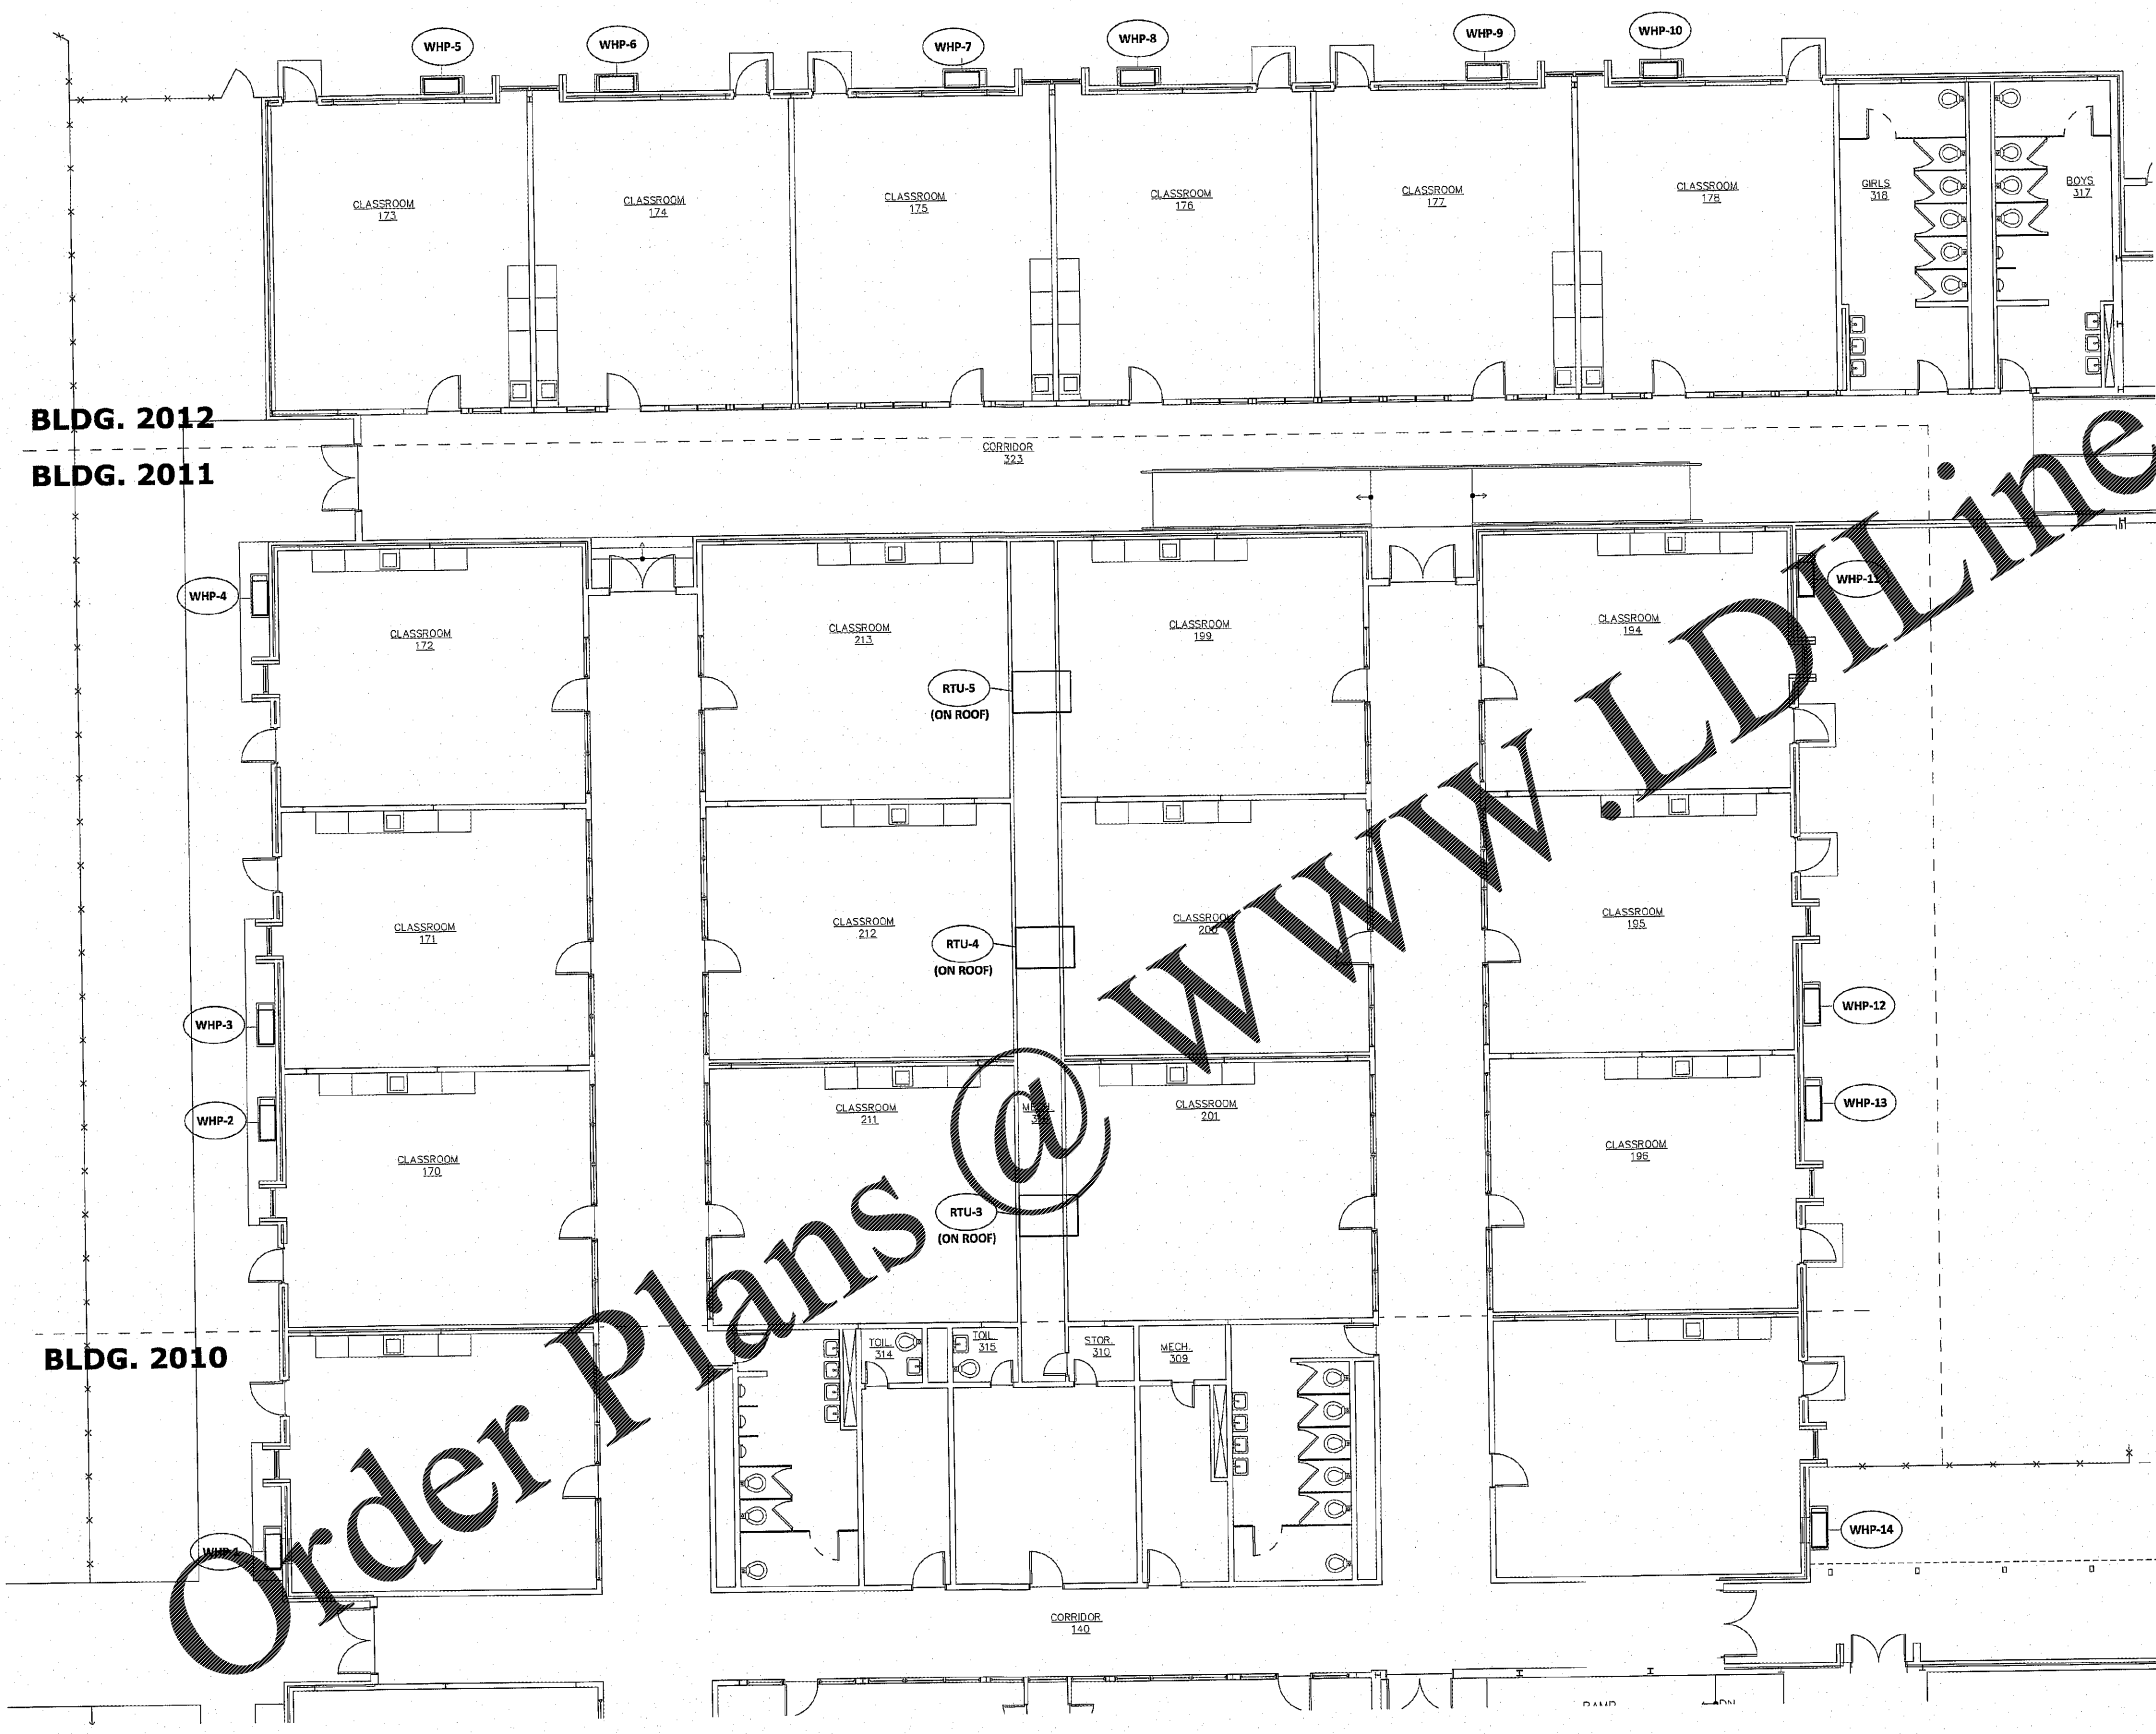

BLDG. 2012

BLDG. 2011

BLDG. 2010

Order Plans @ WWW.LDILine.com

KEY PLAN:

REVISIONS:

Date	Description

**TERRACE MANOR
 ELEMENTARY
 SCHOOL ROOF AND
 HVAC**

FOR
 RICHMOND COUNTY BOARD OF EDUCATION
 RCBOE # B-18-012-4330
 3110 TATE ROAD AUGUSTA, GA

DRAWING TITLE
**MECHANICAL
 POWER PLAN -
 BLDG 2011/2012**

PROJECT NO.	20-14	DRAWING NO.	E2.2
DATE	12/07/2020		
DRAWN BY	KH		
PAPER	24"x36"		
ISSUE	BID SET		

1 MECHANICAL POWER PLAN - BLDG 2011/2012
 E2.2 SCALE: 1/8"=1'-0"

EDC ELECTRICAL ENGINEERS
 1201 BROAD ST., SUITE 1-A
 AUGUSTA, GA 30901
 PH: (706) 724-8551
 FAX: (706) 724-8507
 EDC PROJECT #: 20085