


10/30/2020 9:45:00 AM


J
H
G
F
E
D
C
B
A

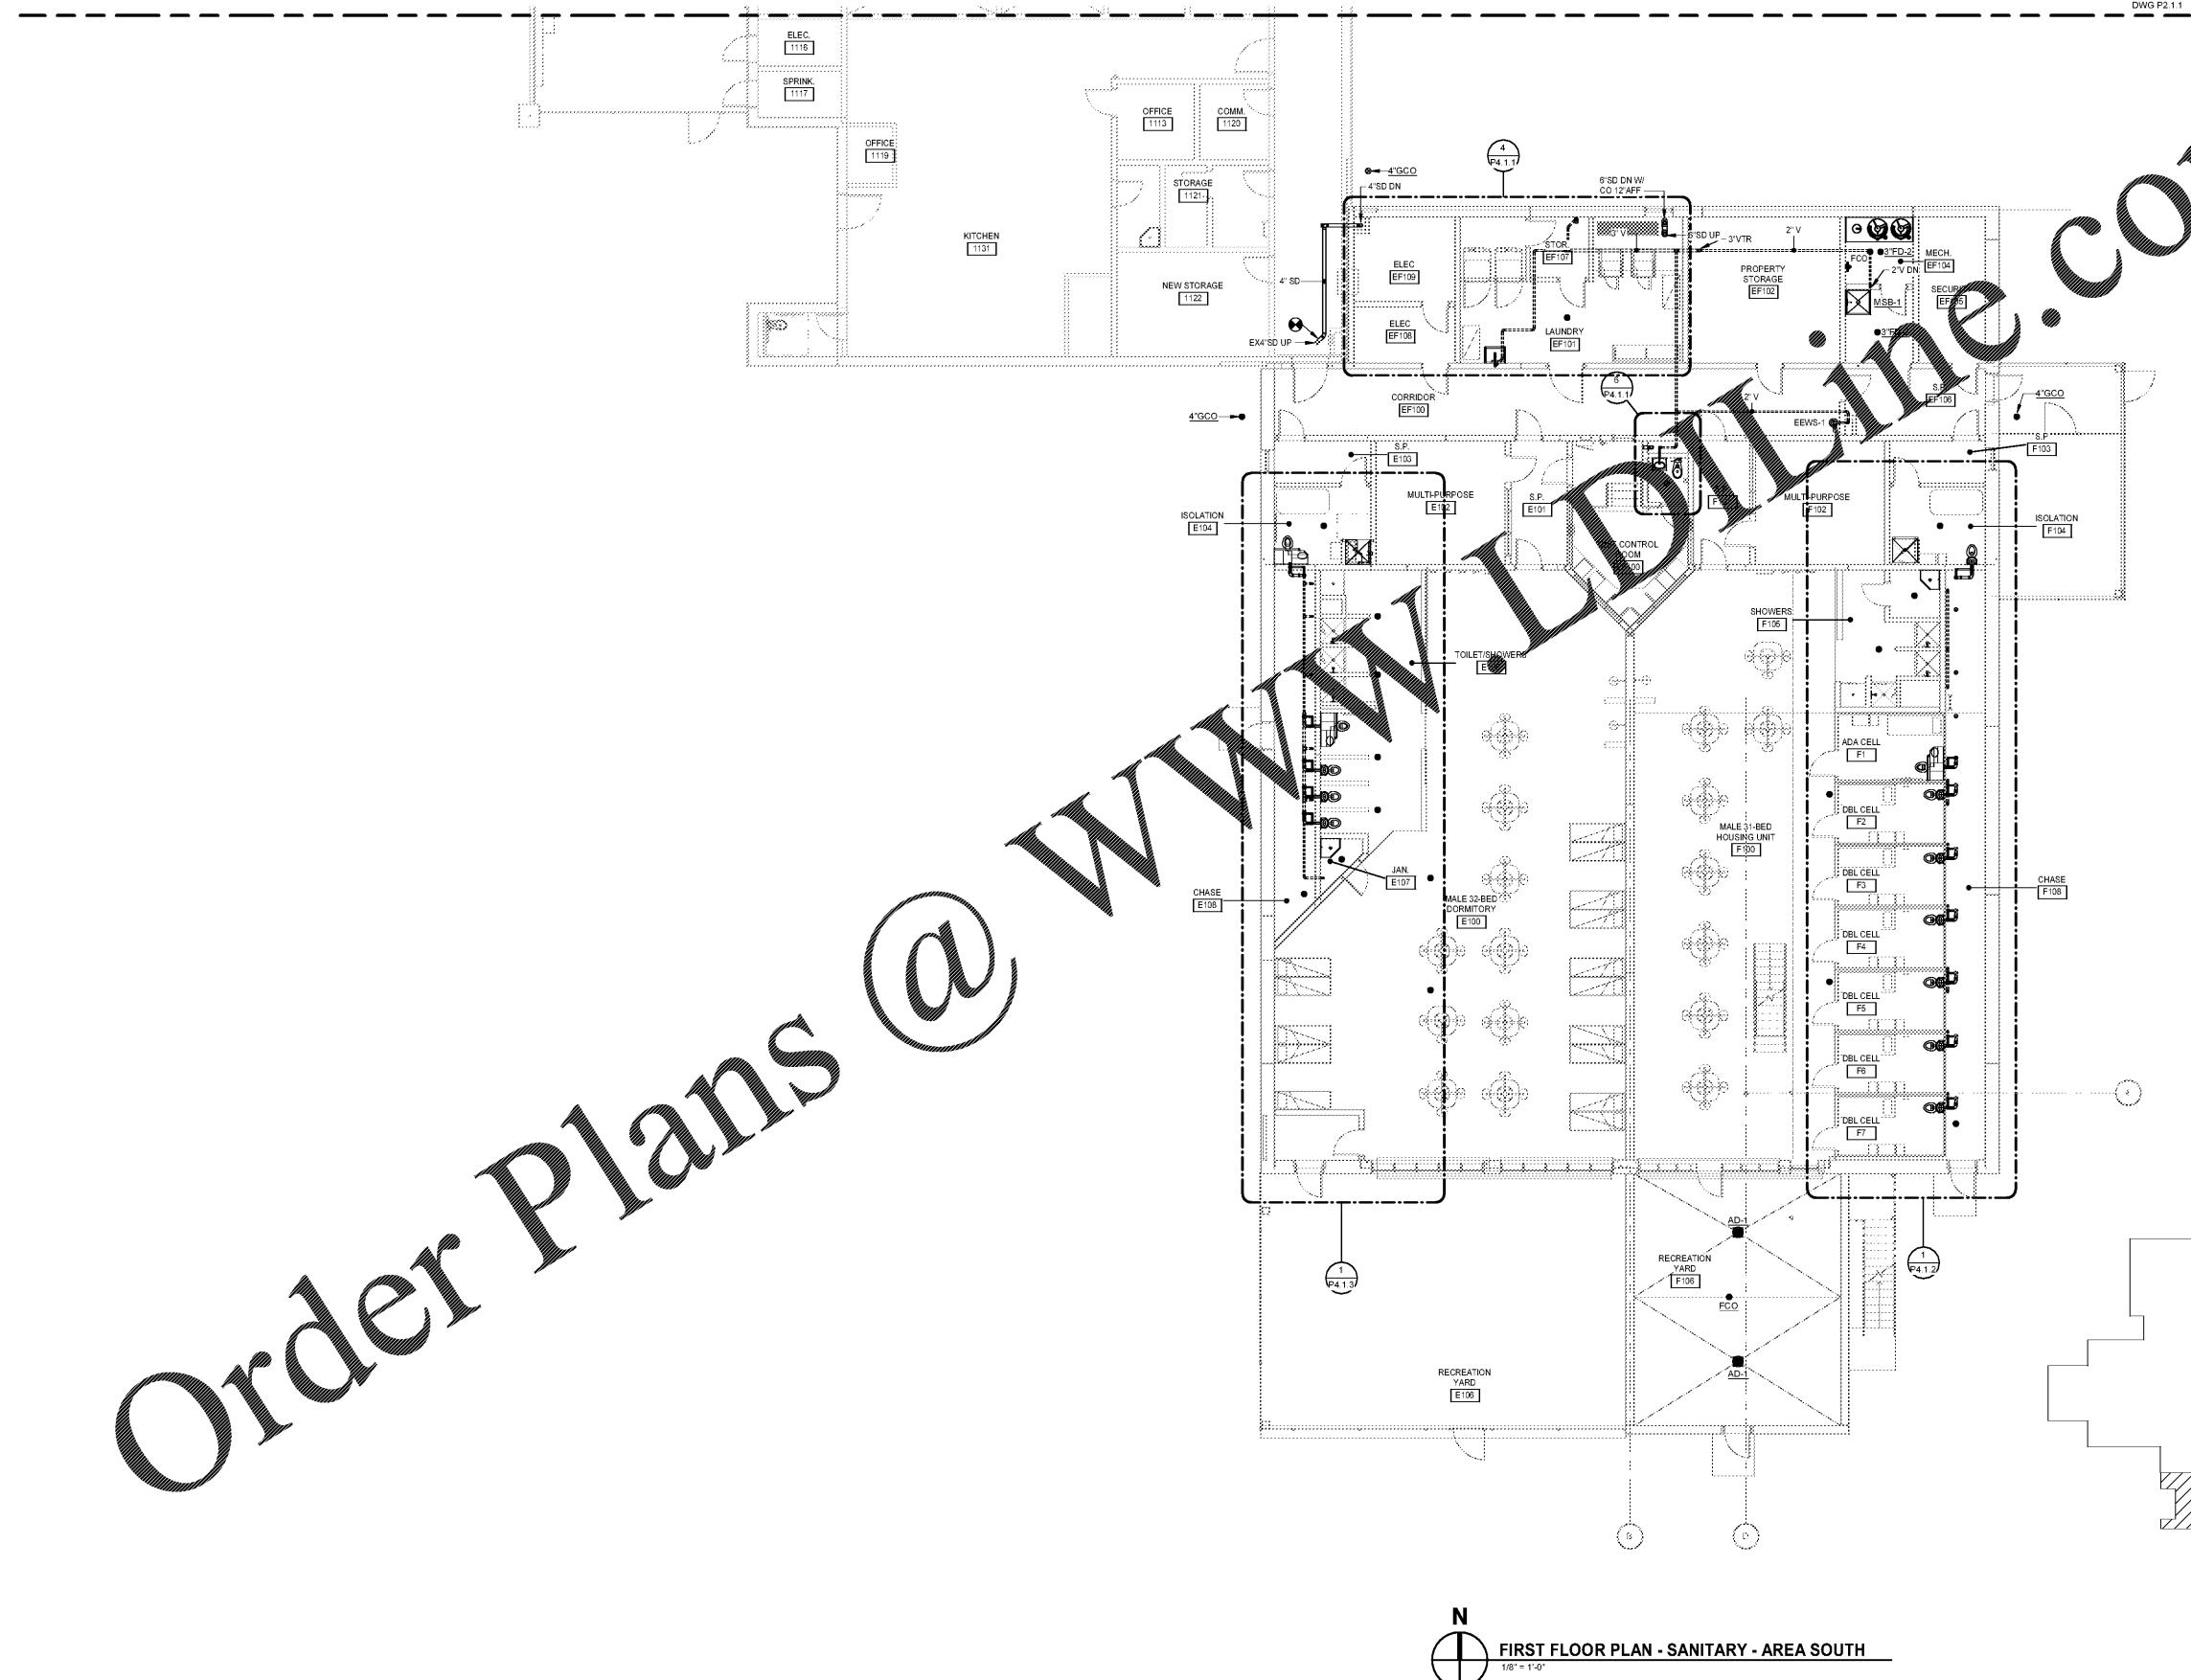

DWG P2.1.1

Order Plans @ WWW.LDLINE.COM

N
FIRST FLOOR PLAN - SANITARY - AREA SOUTH
1/8" = 1'-0"

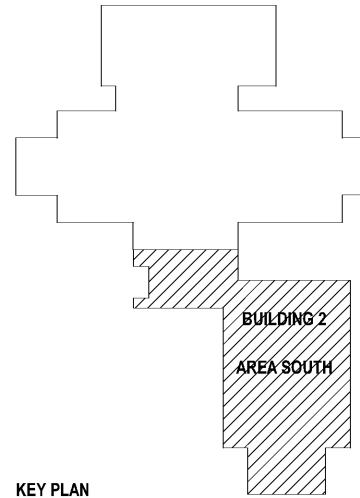

MOSELEYARCHITECTS



1320 MAIN STREET, SUITE 300, COLUMBIA, SC 29201
PHONE (803) 724-1252
MOSELEYARCHITECTS.COM

MARION COUNTY LEC

591492
MARION COUNTY
2715 EAST HWY 76, MULLINS, SC 29574

PROJECT NO.	DATE	REVISIONS
591492	OCTOBER 30, 2020	

FIRST FLOOR
SANITARY PLAN -
AREA SOUTH

P2.1.2