


REVISIONS

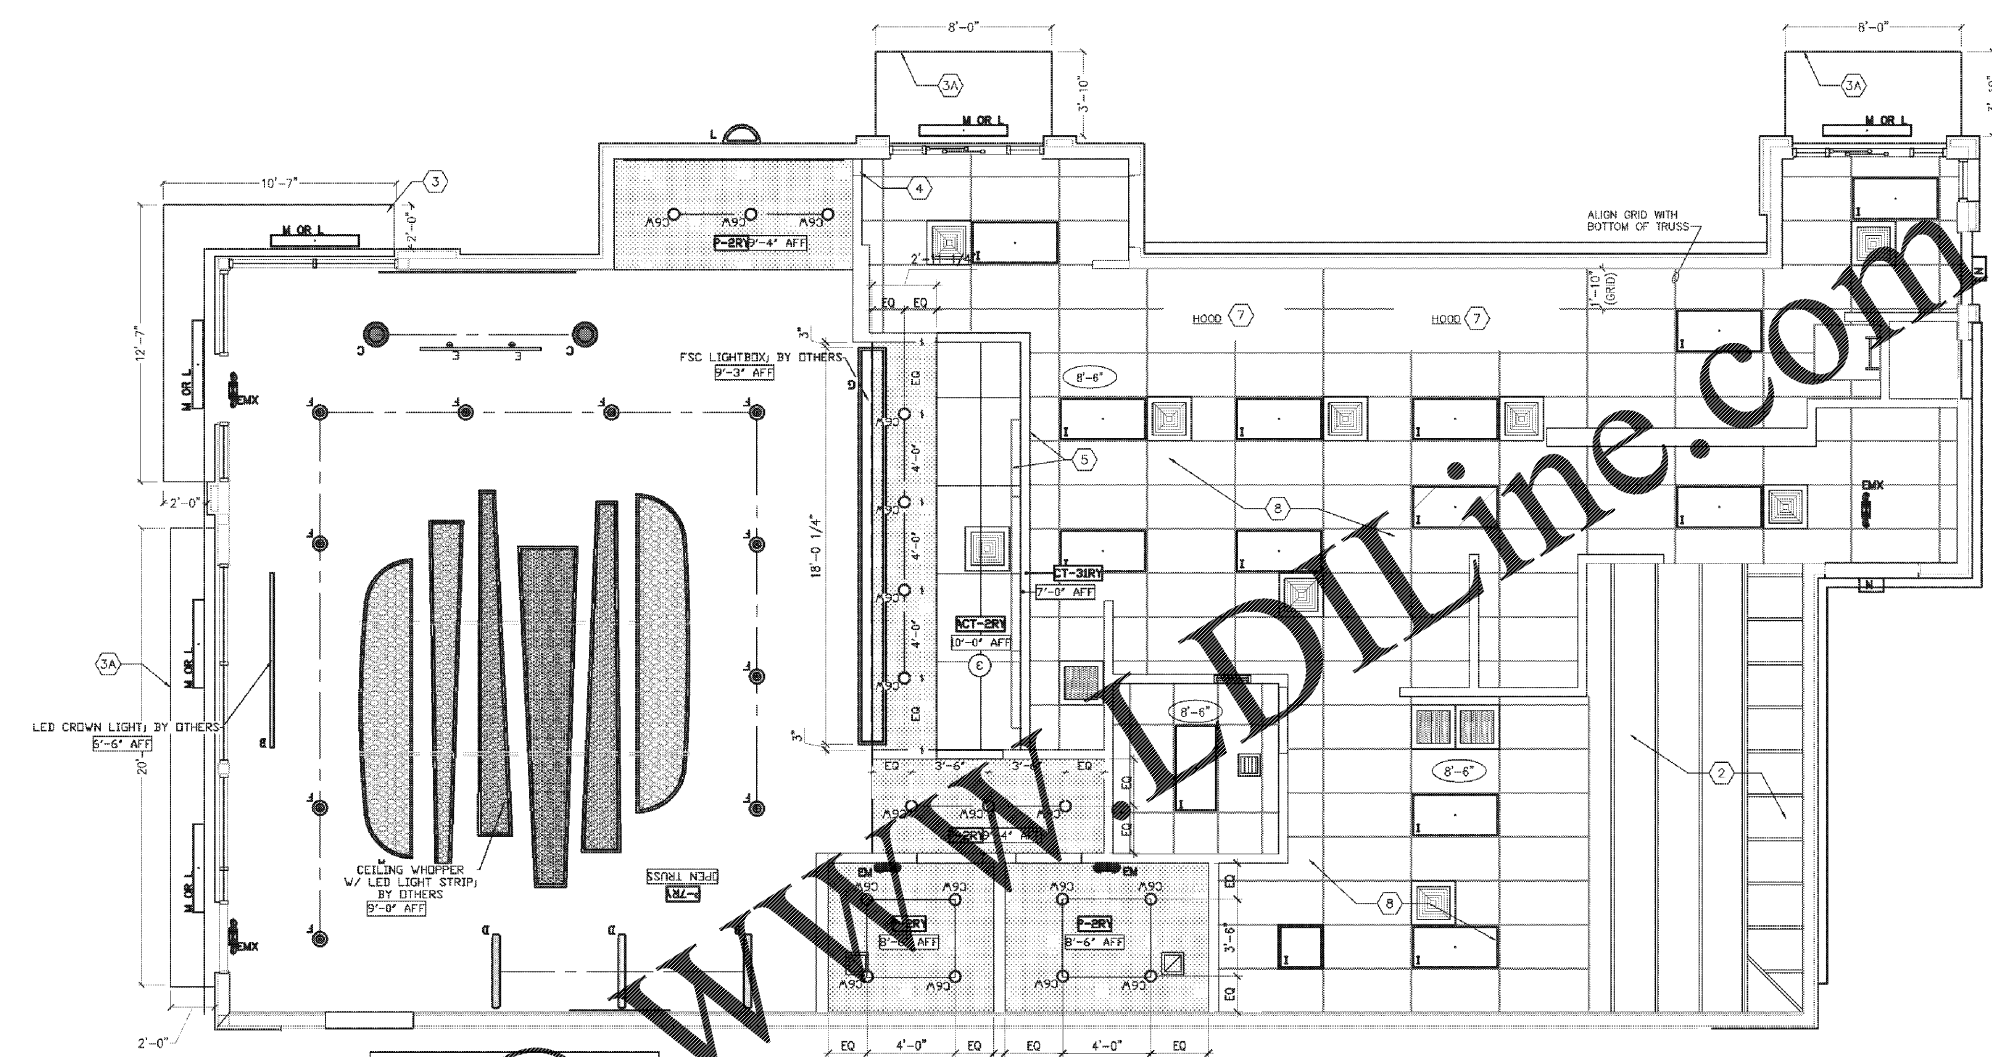

SEE ID AND EQUIP. DRAWINGS FOR DETAILS

1 REF. CLG. PLAN
A1.2 SCALE: 1/4" = 1'-0"

SYMBOLS LEGEND

SYMBOL	DESCRIPTION
	SUPPLY AIR DIFFUSERS
	RETURN AIR GRILLES
	EXHAUST FAN GRILLES
A	SINGLE PENDANT, COORDINATE LOCATION AND QUANTITY WITH DECOR SUPPLIER.
B	SINGLE PENDANT, COORDINATE LOCATION AND QUANTITY WITH DECOR SUPPLIER.
C6w	6" DIAMETER RECESSED DOWNLIGHT
D6w	6" DIAMETER ADJUSTABLE WALL WASH DOWNLIGHT
E	ADJUSTABLE TRACK LIGHT
F	PROFILE LIGHT
G	2" DIAMETER DOWNLIGHT
G1	2" DIAMETER WALL WASH DOWNLIGHT
I	2x4 RECESSED FLAT LIGHTS (NIGHT LIGHT WHEN SHOWN HATCHED)
K	12x12 RECESSED SOFFIT LIGHT
L	SURFACE MOUNTED EXTERIOR WALL SCONCE (ALSO USED IN OPEN CANOPIES)
M	WET LISTED 4'-0" CANOPY LIGHT (USED UNDER AWNINGS AND CLOSED CANOPIES)
N	WALL MOUNTED SECURITY LIGHT
EM	EMERGENCY LIGHT
EMX	EXIT LIGHT

SEE MECH. FOR SPECIFICATIONS
SEE ELEC. DWGS FOR SPECIFICATIONS

KEYED NOTES:

- 1 GYPSUM BOARD CEILING/SOFFIT
- 2 EXPOSED TRUSS ABOVE WALK-IN BOX, REFER TO W.I.B. DRAWINGS FOR INTERIOR LIGHT FIXTURES
- 3 PREFABRICATED METAL CANOPY
- 4 STAINLESS STEEL SERVICE CHASE
- 5 MENU BOARD AND HEADER. REFERENCE DTL 7/A4.2
- 6 SOFFIT ABOVE ENTRY. -CEILING PAINT TO BE EF-16 (REFER TO EXTERIOR FINISH SCHEDULE)
- 7 MECHANICAL EXHAUST HOOD ABOVE
- 8 SUSPENDED ACCOUSTICAL TILE CEILING. REFER TO FINISH SCHEDULE.
- 9 DINING / CORRIDOR CEILING REFER TO ID SHEETS FOR COLOR.
- 10 SUSPENDED ACCOUSTICAL TILE CEILING. REFER TO FINISH SCHEDULE.
- 11 ALL GYP. CEILINGS ARE TO BE FINISHED W/ EPOXY PAINT OR EPOXY SEALANT. COORD. & VERIFY W/ DECOR DRAWINGS
- 12 INSTALL MOTOR SENSORS LIGHT SWITCHES IN RESTROOMS & OFFICE. COORD. & VERIFY W/ OWNER
- 13 ENCLOSE GAP BETWEEN TOP OF W.I.B. & BOT. OF CLG. WITH S.S. ENCLOSURE

GENERAL NOTES:

- A. ALL DIMENSIONS SHOWN ON REFLECTED CEILING PLAN ARE FROM FACE OF WALL FINISH UNLESS NOTED OTHERWISE.
- B. THE REFERENCE HEIGHTS INDICATED ON PLAN ARE FROM FINISH FLOOR (F.F.).
- C. GENERAL CONTRACTOR TO COORDINATE DINING ROOM LIGHTING WITH APPROVED INTERIOR DECOR DRAWINGS.
- D. CONTRACTOR SHALL VERIFY FIXTURE QUANTITIES AND ALSO MAKE PROPER ADJUSTMENTS FOR ANY CHANGES IN PLAN DUE TO ADDITIONAL REQUIREMENTS, LOCAL CODES, ETC.
- E. FOR H.V.A.C. PLAN, SECTIONS, DUCT LOCATIONS, SUPPLY AND RETURN GRILLE SIZES AND ADDITIONAL INFORMATION, REFERENCE MECH. DWGS.
- F. ALL FIXTURES SHALL BE LOCATED IN THE CENTER OF CEILING TILES UNLESS NOTED OTHERWISE.
- G. REFERENCE ELEC. DWGS. FOR LIGHTING LAYOUT REQUIREMENTS AND ADDITIONAL INFORMATION.
- H. REFERENCE INTERIOR DECOR SHEETS FOR FINISH SPECIFICATIONS.
- I. CONTRACTOR TO COORDINATE PENDANT LIGHT LOCATIONS WITH DECOR SUPPLIER DRAWINGS.

Files: November 06, 2020 09:29:36am [bld]
 N:\Projects\2019\19085\Architect\Drawings\A1.2.dwg [A1.2]
 Plt: 3/20/20 11:18:24 AM [A1.2] PLOT DATE: 11/06/2020 11:18:24 AM
 User: jloia