


11/22/2020 10:58 AM C:\Users\jking\OneDrive\Documents\Projects\20197 22 0000\DWG\Sanitary\Sanitary\Sanitary.dwg
 11/22/2020 10:58 AM C:\Users\jking\OneDrive\Documents\Projects\20197 22 0000\DWG\Sanitary\Sanitary\Sanitary.dwg
 11/22/2020 10:58 AM C:\Users\jking\OneDrive\Documents\Projects\20197 22 0000\DWG\Sanitary\Sanitary\Sanitary.dwg

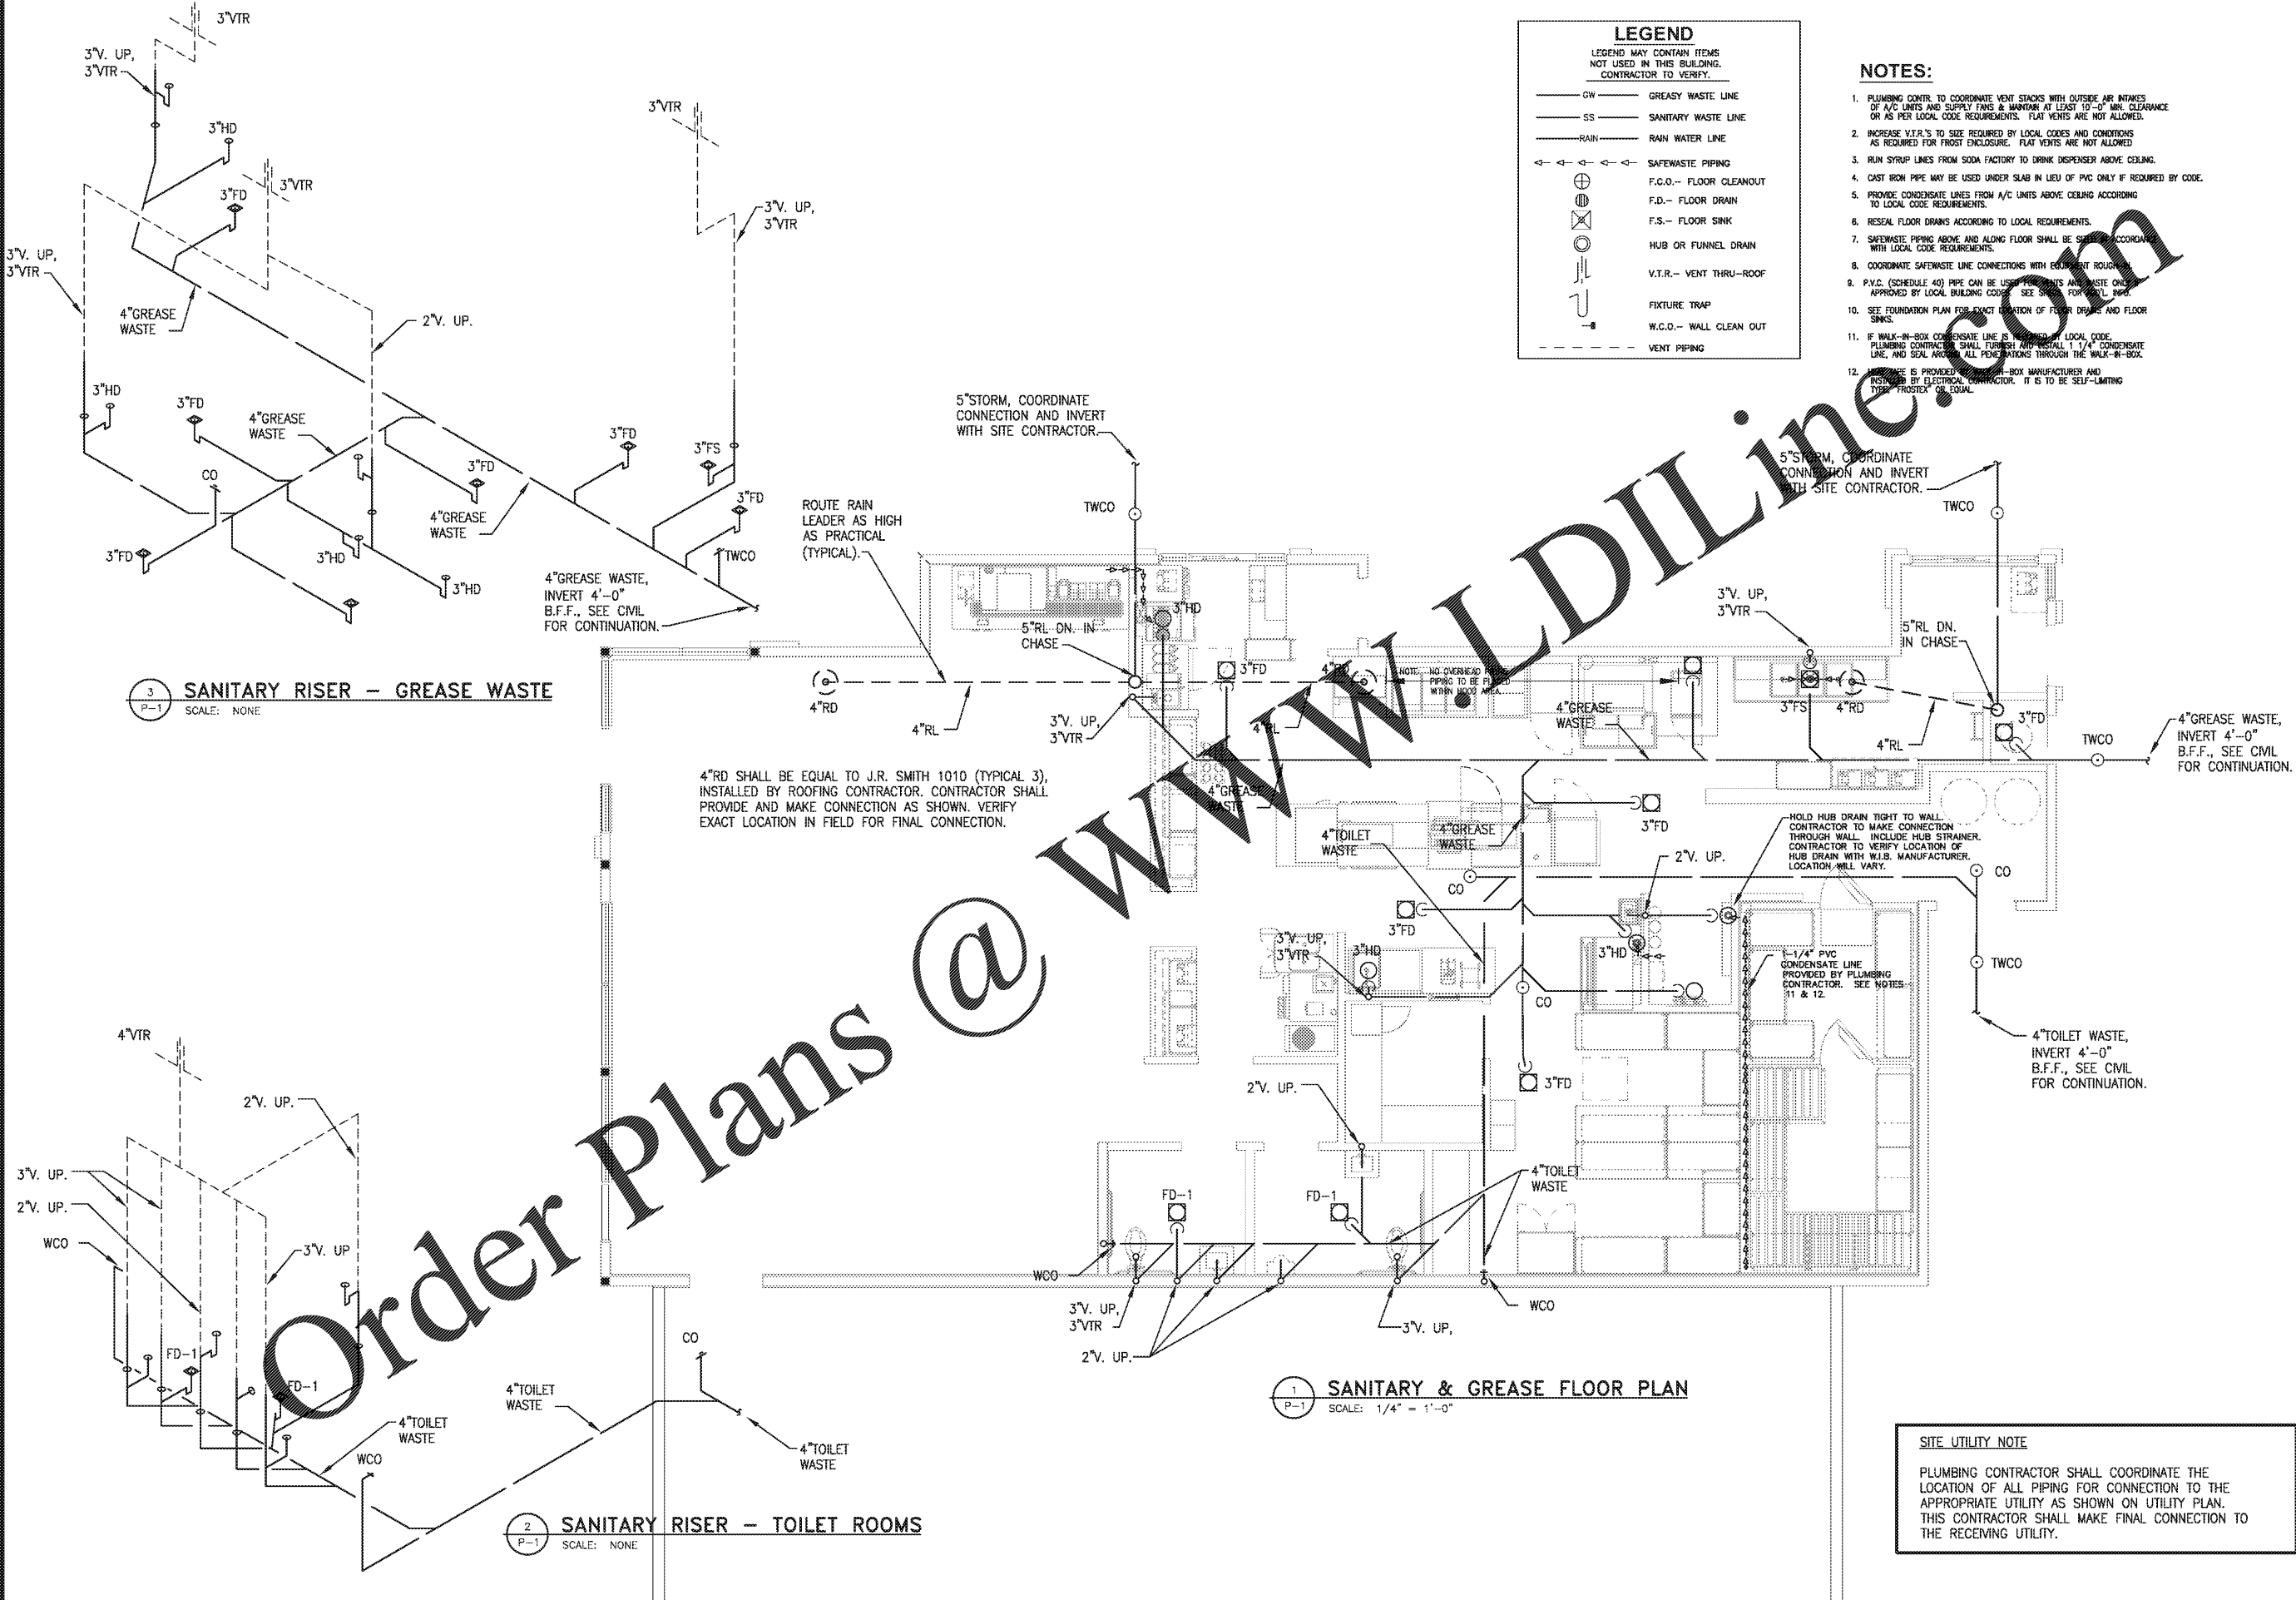

LEGEND	
— GW	GREASY WASTE LINE
— SS	SANITARY WASTE LINE
— RAIN	RAIN WATER LINE
← ← ← ← ←	SAFEWASTE PIPING
⊕	F.C.O.— FLOOR CLEANOUT
⊖	F.D.— FLOOR DRAIN
⊗	F.S.— FLOOR SINK
⊙	HUB OR FUNNEL DRAIN
⊘	V.T.R.— VENT THRU—ROOF
⊚	FIXTURE TRAP
⊛	W.C.O.— WALL CLEAN OUT
---	VENT PIPING

- NOTES:**
- PLUMBING CONTR. TO COORDINATE VENT STACKS WITH OUTSIDE AIR INTAKES OF A/C UNITS AND SUPPLY FANS & MAINTAIN AT LEAST 10'-0" MIN. CLEARANCE OR AS PER LOCAL CODE REQUIREMENTS. FLAT VENTS ARE NOT ALLOWED.
 - INCREASE V.T.R.'S TO SIZE REQUIRED BY LOCAL CODES AND CONDITIONS AS REQUIRED FOR FROST ENCLOSURE. FLAT VENTS ARE NOT ALLOWED.
 - RUN STRIP LINES FROM SODA FACTORY TO DRINK DISPENSER ABOVE CEILING.
 - CAST IRON PIPE MAY BE USED UNDER SLAB IN LIEU OF PVC ONLY IF REQUIRED BY CODE.
 - PROVIDE CONDENSATE LINES FROM A/C UNITS ABOVE CEILING ACCORDING TO LOCAL CODE REQUIREMENTS.
 - RESEAL FLOOR DRAINS ACCORDING TO LOCAL REQUIREMENTS.
 - SAFEWASTE PIPING ABOVE AND ALONG FLOOR SHALL BE SEaled ACCORDING TO LOCAL CODE REQUIREMENTS.
 - COORDINATE SAFEWASTE LINE CONNECTIONS WITH EQUIPMENT ROUGHING.
 - P.V.C. (SCHEDULE 40) PIPE CAN BE USED FOR UNITS AND WASTE ONLY APPROVED BY LOCAL BUILDING CODES. SEE SPEC. FOR P.V.C. PIPE.
 - SEE FOUNDATION PLAN FOR EXACT LOCATION OF FLOOR DRAINS AND FLOOR SINKS.
 - IF WALK-IN-BOX CONDENSATE LINE IS REQUIRED BY LOCAL CODE, PLUMBING CONTRACTOR SHALL FURNISH AND INSTALL 1 1/4" CONDENSATE LINE, AND SEAL AROUND ALL PENETRATIONS THROUGH THE WALK-IN-BOX.
 - CONDENSATE LINE IS PROVIDED BY WALK-IN-BOX MANUFACTURER AND SHALL BE INSTALLED BY ELECTRICAL CONTRACTOR. IT IS TO BE SELF-LIMITING TYPE, FROST-RESISTANT OR EQUAL.


3 SANITARY RISER - GREASE WASTE
SCALE: NONE

1 SANITARY & GREASE FLOOR PLAN
SCALE: 1/4" = 1'-0"

2 SANITARY RISER - TOILET ROOMS
SCALE: NONE

Order Plans @ WWW.LDILINE.COM

ROBERTSON LOIA ROOF ARCHITECTS & ENGINEERS
 3460 Preston Ridge Road, Suite 275, Alpharetta, Georgia 30005
 770-674-9600 Fax 770-674-9745
 GA.COA.#RE000562 Exp. Date 6/30/2022

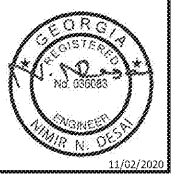

PALMETTO BURGER KING
 3765 ROOSEVELT HWY, PALMETTO, GA.
 FOR **JP DESIGN & CONSTRUCTION**
 JACKSON, GA.

REVISIONS

SHEET TITLE
SANITARY AND GREASE WASTE PLAN & RISERS

DATE
 10-30-20

PROJECT NUMBER
 20-197

SHEET NUMBER
P-1

SITE UTILITY NOTE

PLUMBING CONTRACTOR SHALL COORDINATE THE LOCATION OF ALL PIPING FOR CONNECTION TO THE APPROPRIATE UTILITY AS SHOWN ON UTILITY PLAN. THIS CONTRACTOR SHALL MAKE FINAL CONNECTION TO THE RECEIVING UTILITY.