


2 SANITARY RISER - TOILET ROOMS
SCALE: NONE

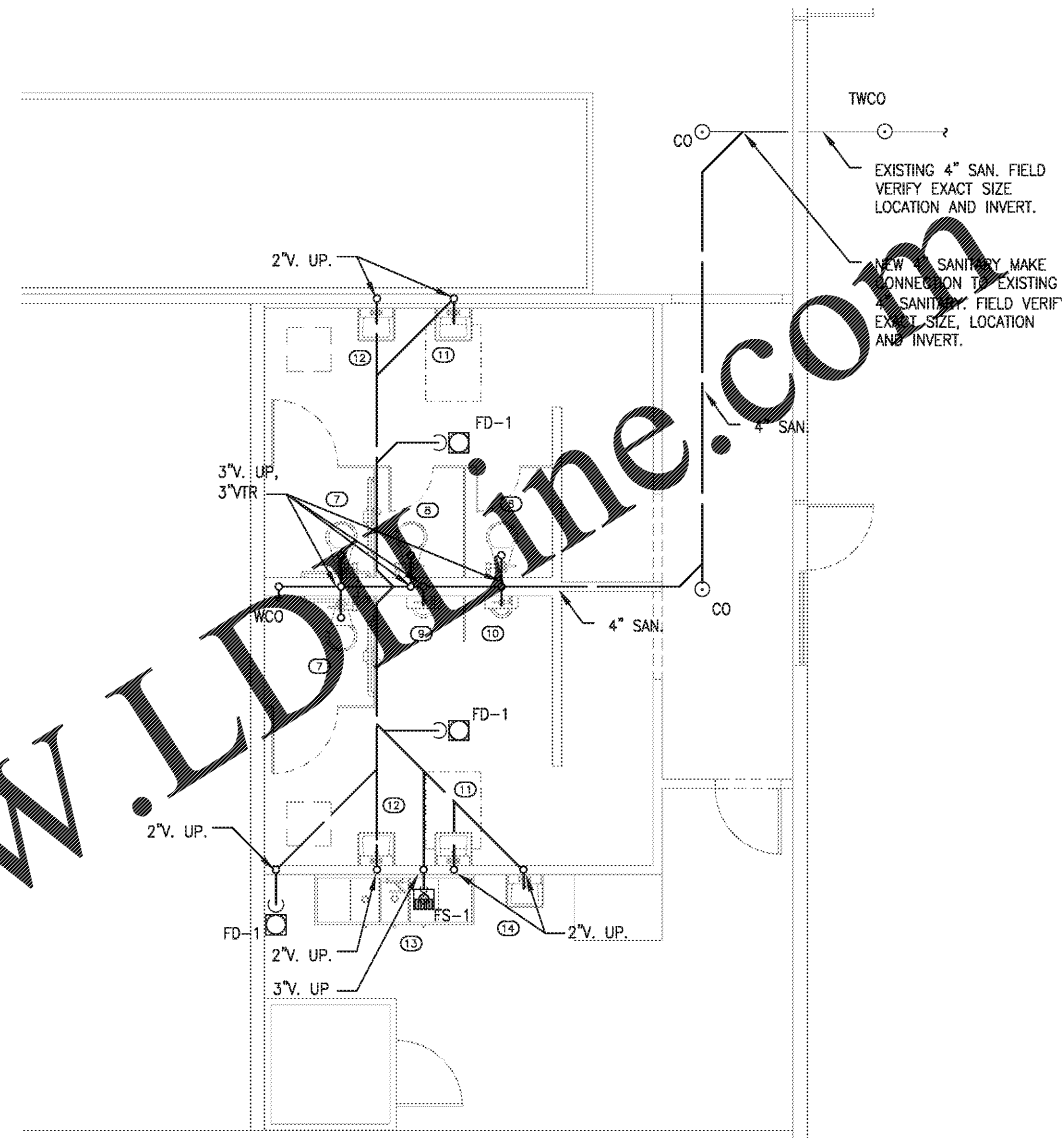

1 SANITARY & GREASE FLOOR PLAN
SCALE: 1/4" = 1'-0"

Order Plans @ www.LDOnline.com

ROBERTSON LOIA ROOF ARCHITECTS & ENGINEERS
 3460 Preston Ridge Road, Suite 275, Alpharetta, Georgia 30005
 770-674-9800, Fax 678-919-0745
 GA COA #PE000562 Exp. Date 6/30/2022



PALMETTO BURGER KING
 3765 ROOSEVELT HWY, PALMETTO, GA.
 FOR **JP DESIGN & CONSTRUCTION**
 JACKSON, GA.

REVISIONS

SHEET TITLE
SANITARY WASTE PLAN & RISERS

DATE	10-30-20
PROJECT NUMBER	20-197
SHEET NUMBER	P-4

H:\Projects\2017\Palmetto Burger King\2017 P-1 Sanitary and Grease Working\2017 P-1 Sanitary and Grease Working.dwg
 11/02/2020 10:00:00 AM
 W. N. DeJani