


PLOT DATE: 12/11/20 2:24 PM
 R:\07-Production\0206124\0206124-ICC.01 - Lake Lanier Islands Conference Center -\Production\Engineering\Design\LI Conference Center\0206124-ICC-SITE.dwg

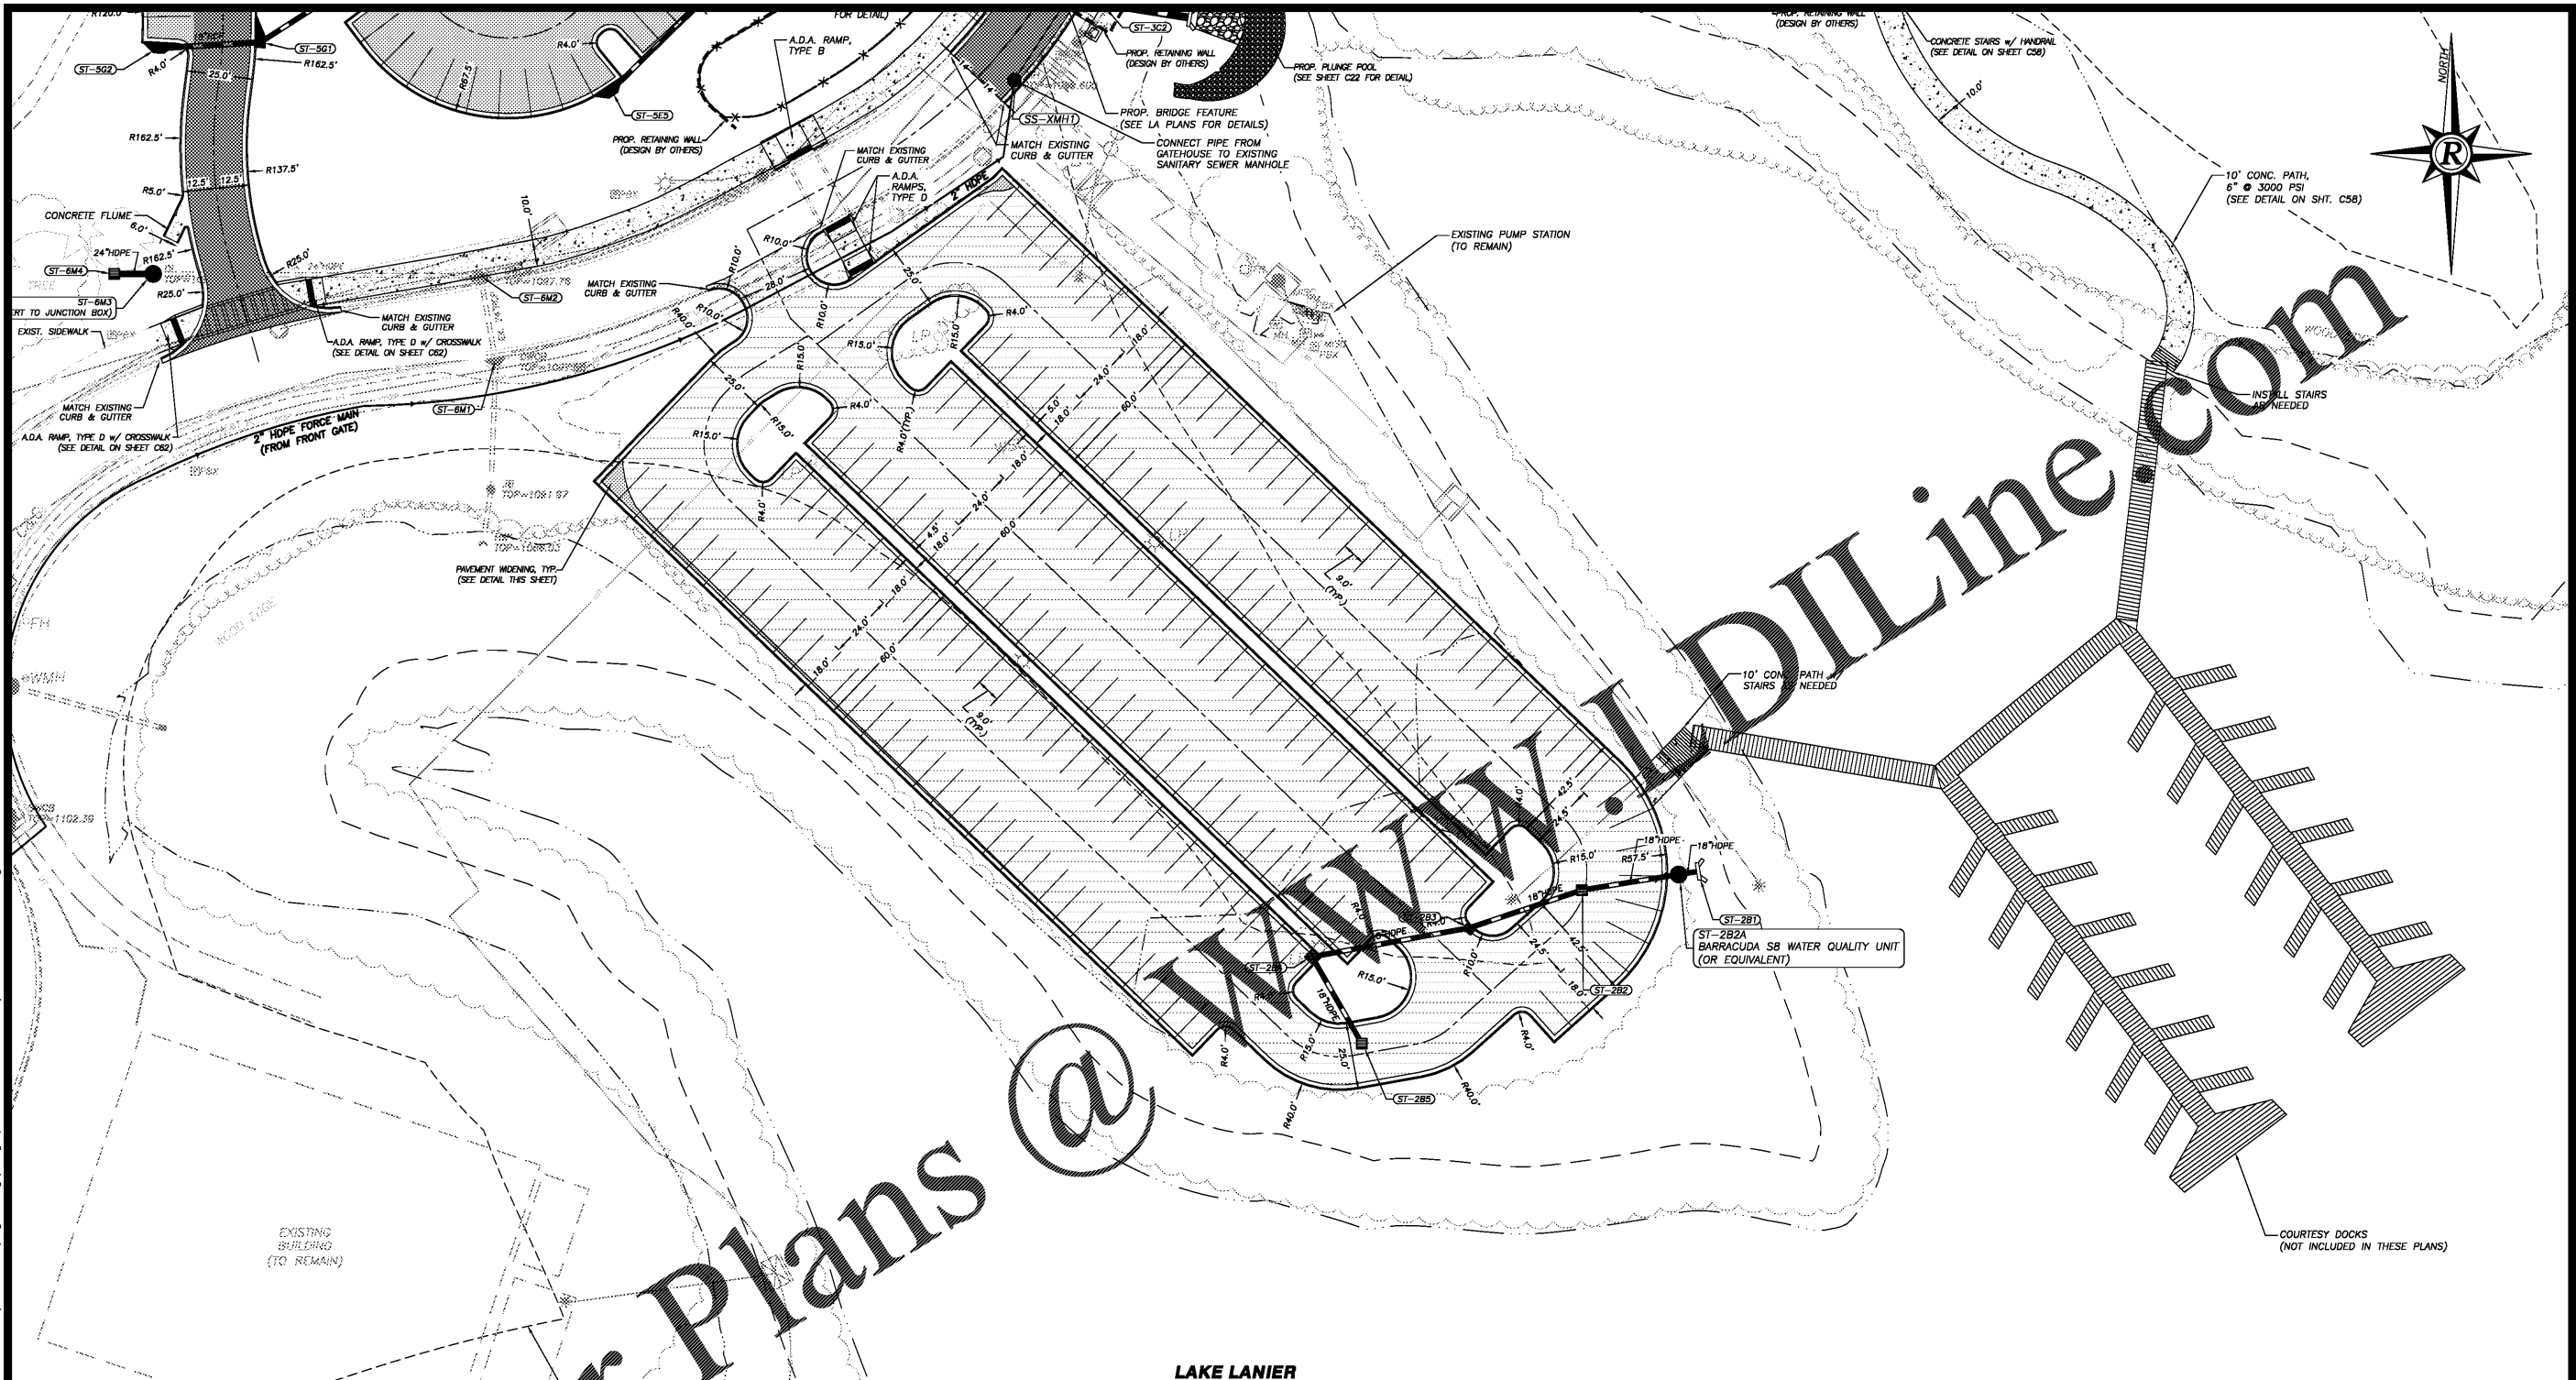


Order Plans @

HATCH LEGEND


	REINFORCED TURF
	CONCRETE SIDEWALKS
	HEAVY DUTY CONCRETE
	STAMPED CONCRETE SEE LANDSCAPE PLANS
	ASPHALT OVERLAY
	BUILDING
	HEAVY DUTY PAVEMENT
	LIGHT DUTY PAVEMENT

LINETYPE LEGEND

	25' STATE UNDISTURBED BUFFER
	100' SHORELINE BUFFER
	NORMAL POOL ELEVATION (1071')
	FLOOD ELEVATION (1085')
	EXISTING TREE LINE

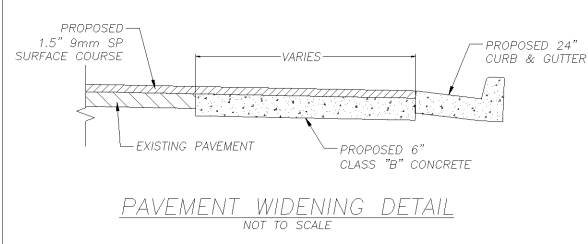

- NOTES:**
- SEE LA & MEP PLANS FOR SITE LIGHTING PLANS.
 - SEE ARCHITECTURAL PLANS FOR EXACT BUILDING DIMENSIONS.
 - CURB DIMENSIONS ARE TO BACK OF CURB UNLESS OTHERWISE MENTIONED.
 - SEE SHEETS C24 THROUGH C25 FOR SANITARY SEWER PROFILES.
 - SEE SHEETS C58 THROUGH C62 FOR CONSTRUCTION DETAILS.

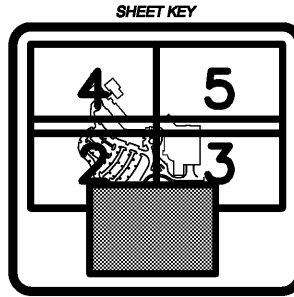

SITE & UTILITY PLAN 1
 FOR:
**LANIER ISLANDS
 CONFERENCE CENTER**
 LAND LOT 380
 7TH DISTRICT
 CITY OF BUFORD, HALL COUNTY, GEORGIA

REVISIONS

NO.	REV	DATE	DESCRIPTION

ANY CHANGES OR ALTERATIONS MADE TO THESE CONSTRUCTION DRAWINGS WITHOUT THE SIGNATURE OF THE DESIGNER OR ASSOCIATES, INC. VOID. THE SEAL SHOWN HEREON AND ANY LIABILITY ASSOCIATED THEREWITH ARE KEPT ON FILE FOR VERIFICATION OF ANY CHANGES.

GRAPHIC SCALE
 1" = 30'
 0' 30' 60'



SHEET
C10
 OF
C66
 DATE: 12-11-20
 SCALE: 1"=30'
 JOB NO.: 0206124-ICC.01
 REV'D BY: JNC
 DRAWN BY: JRS