


SHEET KEY

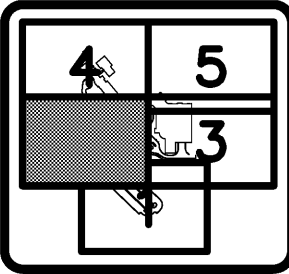

LINETYPE LEGEND

- 25' STATE UNDISTURBED BUFFER
- 100' SHORELINE BUFFER
- NORMAL POOL ELEVATION (1071')
- FLOOD ELEVATION (1085')
- EXISTING TREE LINE



NOTES:

- SEE LA & MEP PLANS FOR SITE LIGHTING PLANS.
- SEE ARCHITECTURAL PLANS FOR EXACT BUILDING DIMENSIONS.
- CURB DIMENSIONS ARE TO BACK OF CURB UNLESS OTHERWISE MENTIONED.
- SEE SHEETS C24 THROUGH C25 FOR SANITARY SEWER PROFILES.
- SEE SHEETS C58 THROUGH C62 FOR CONSTRUCTION DETAILS.

HATCH LEGEND

- REINFORCED TURF
- CONCRETE SIDEWALKS
- HEAVY DUTY CONCRETE
- STAMPED CONCRETE SEE LANDSCAPE PLANS
- ASHPALT OVERLAY
- BUILDING
- HEAVY DUTY PAVEMENT
- LIGHT DUTY PAVEMENT

Order Plans

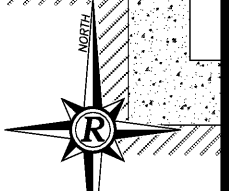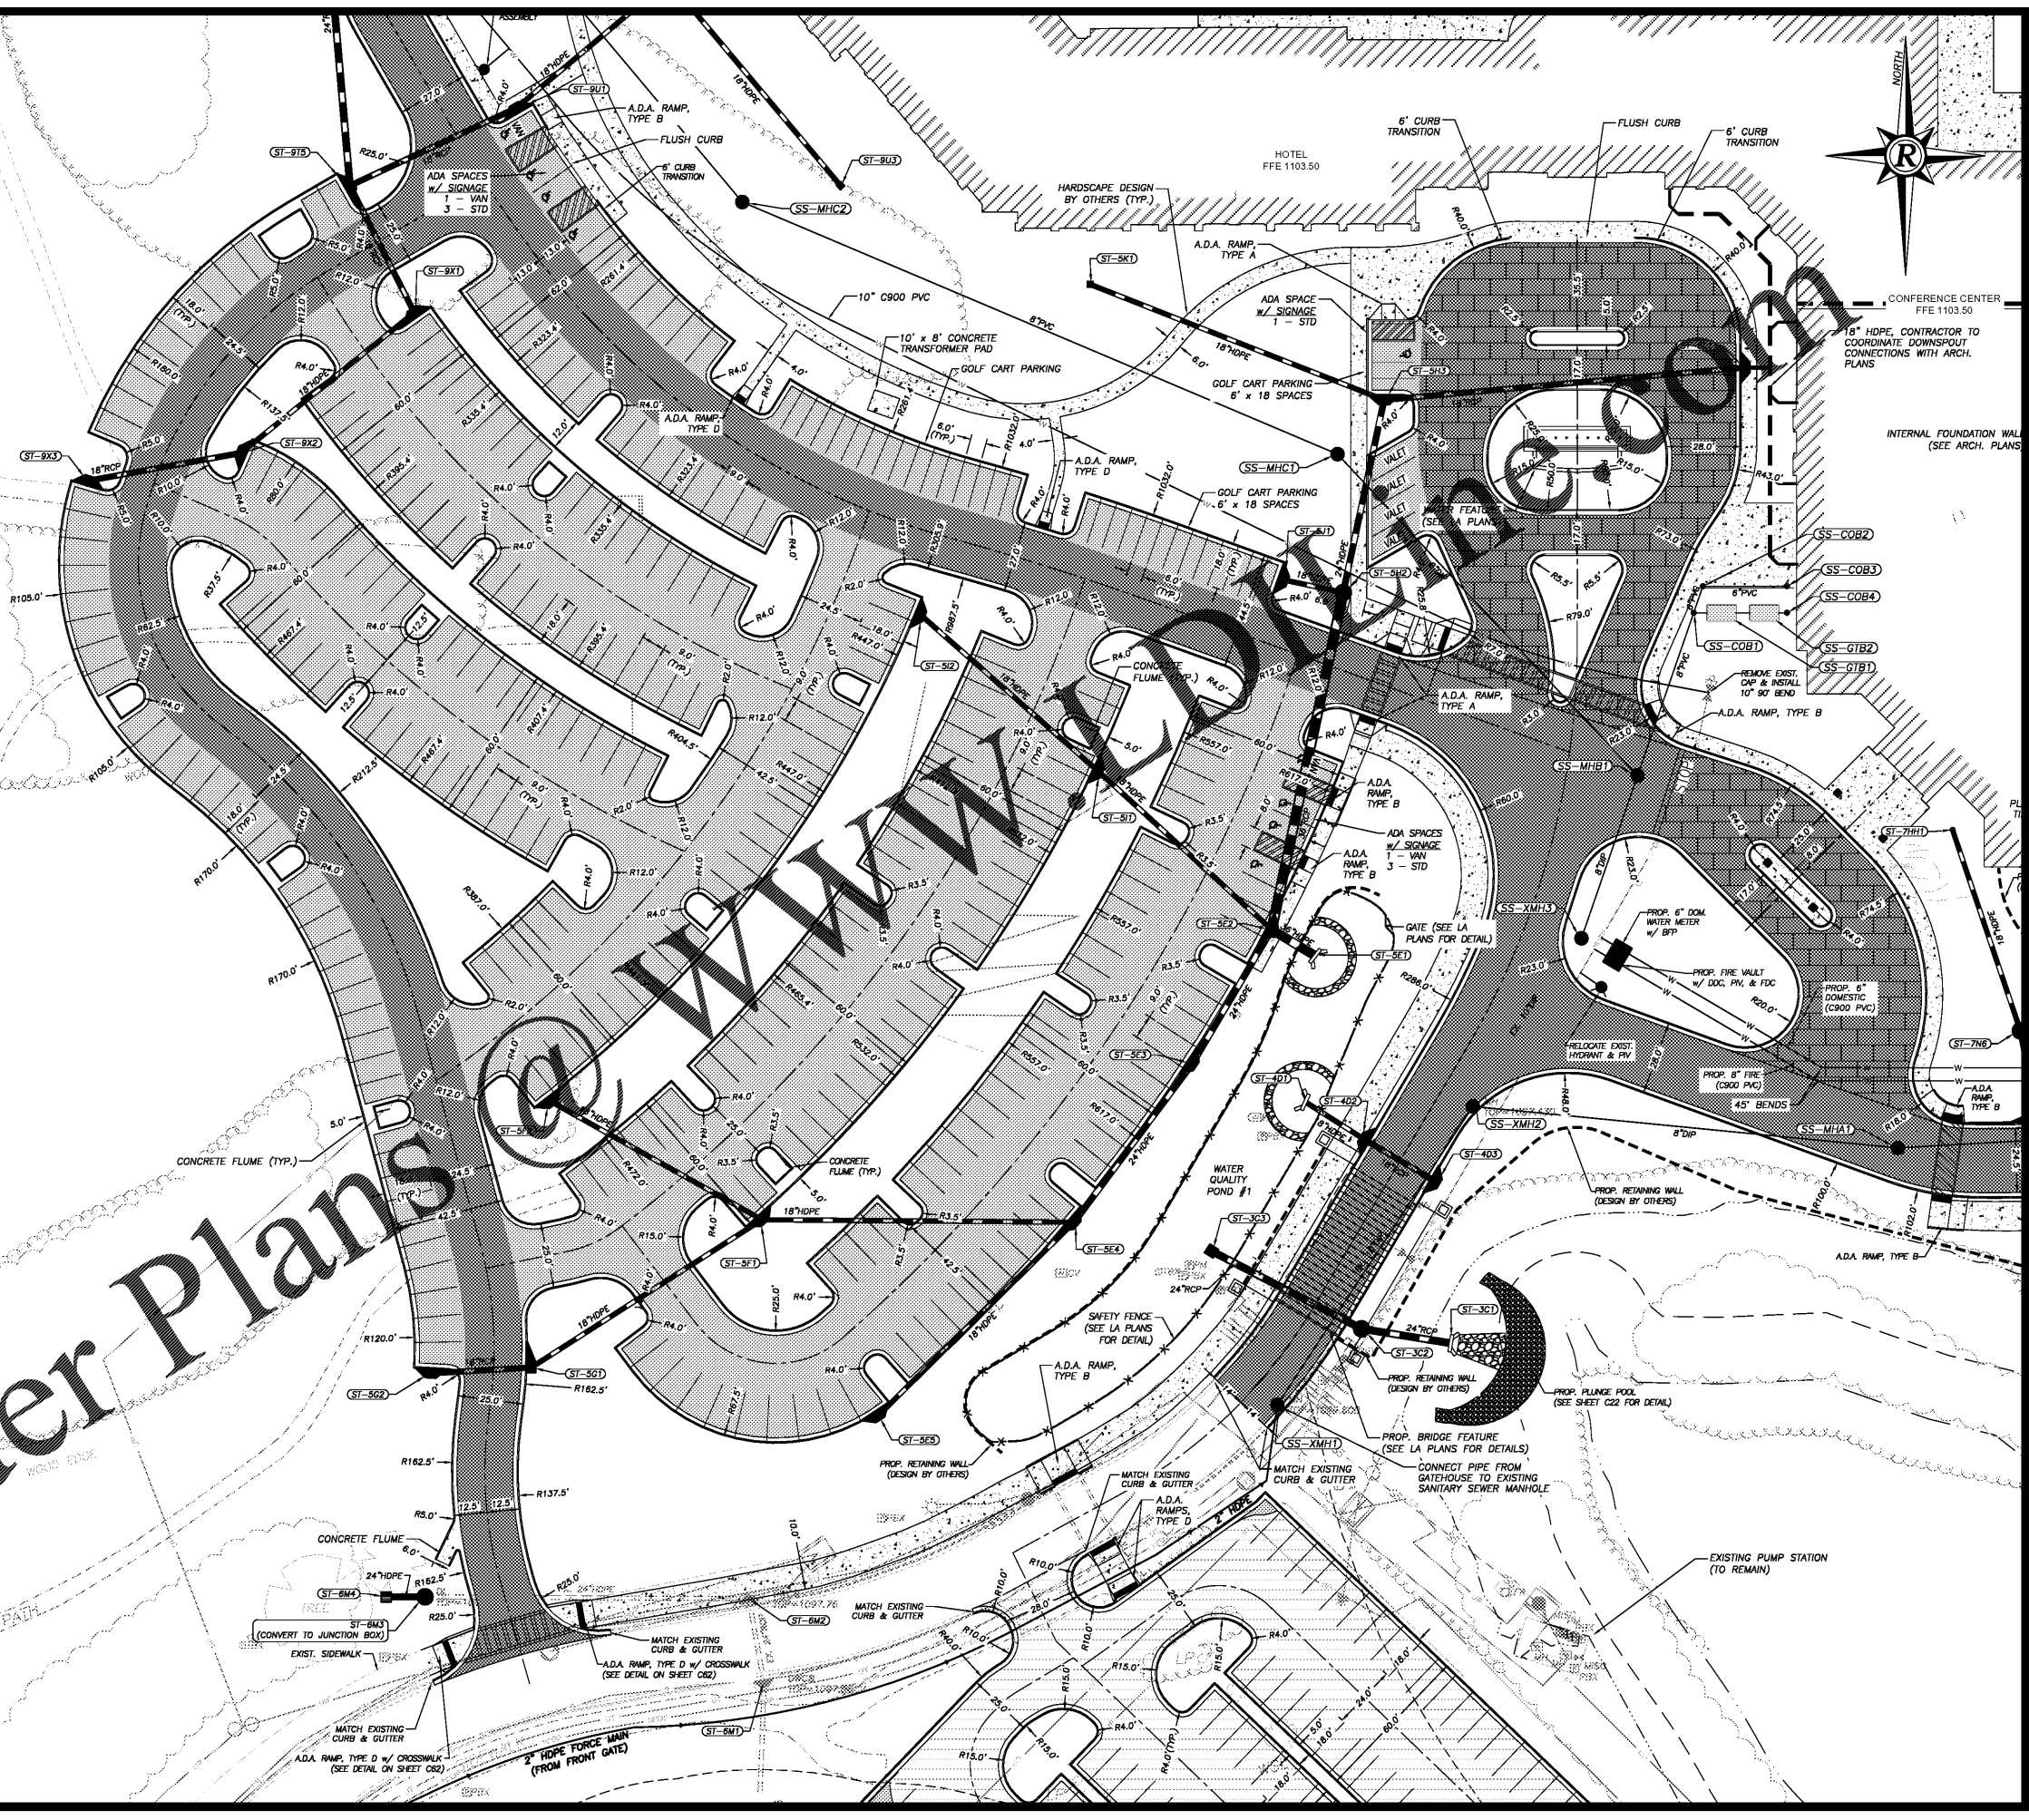

FOR:  
**LANIER ISLANDS  
 CONFERENCE CENTER**

LAND LOT 390  
 7TH DISTRICT  
 CITY OF BUFORD, HALL COUNTY, GEORGIA

REVISIONS

NO.	REV.	DATE	DESCRIPTION

ANY CHANGES OR ALTERATIONS MADE TO THESE CONSTRUCTION DRAWINGS WITHOUT THE SIGNATURE OF THE PROFESSIONAL ENGINEER AND ANY LIABILITY ASSOCIATED THEREWITH ARE VOID. THESE DRAWINGS ARE KEPT ON FILE FOR VERIFICATION OF ANY CHANGES.

GRAPHIC SCALE  
 1" = 30'  
 0" = 60'



SHEET  
**C11**  
 OF  
**C66**

DATE: 12-11-20  
 SCALE: 1"=30'  
 JOB NO.: 0208184.KC.01  
 REV'D BY: JNC  
 DRAWN BY: JRS

PLOT DATE: 12/11/20 2:24 PM  
 R:\07-Production\0208184\0208184-ICC.01 - Lake Lanier Islands Conference Center -\Production\Engineering\Design\LI Conference Center\0208184-ICC-SITE.dwg