

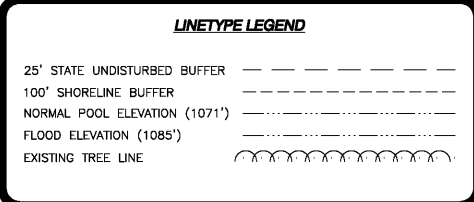


- NOTES:**
1. SEE L.A. & STRUCTURAL PLANS FOR WALL PLANS.
 2. SEE ARCHITECTURAL PLANS FOR EXACT BUILDING DIMENSIONS.
 3. BOTTOM OF WALL ELEVATIONS LISTED IS FINISHED GRADE ELEVATION AND NOT TOP OF FOOTING.
 4. SEE SHEETS C28 THROUGH C31 FOR STORM SEWER PROFILES.
 5. SEE SHEETS C58 THROUGH C62 FOR CONSTRUCTION DETAILS.
 6. SPOT GRADES ARE AT EDGE OF PAVEMENT UNLESS OTHERWISE NOTED.

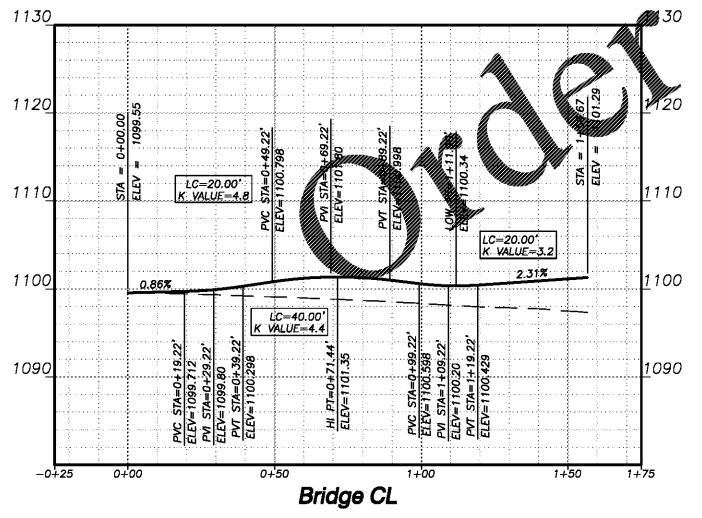


- LEGEND**
- AIF - ANGLE IRON FOUND
 - AKA - ALSO KNOWN AS
 - BC - BACK OF CURB
 - BL - BUILDING SETBACK LINE
 - BWF - BARB WIRE FENCE
 - C&G - CURB & GUTTER
 - CI - CRIMP TOP PIPE
 - CL - CURB INLET
 - CLF - CENTER LINE
 - CLM - CHAIN LINK FENCE
 - CMF - CONCRETE MONUMENT FOUND
 - COMP - CORRUGATED METAL PIPE
 - CO - CLEANOUT
 - CONC - CONCRETE
 - CORPS - US ARMY CORPS OF ENGINEERS
 - DB,PG - DEED BOOK, PAGE
 - D - DROP INLET
 - DIP - DUCTILE IRON PIPE
 - DS - DOWN SPOUT
 - DWCB - DOUBLE WING CATCH BASIN
 - EP - EDGE OF PAVEMENT
 - FFE - FINISH FLOOR ELEVATION
 - FH - FIRE HYDRANT
 - G - GAS LINE
 - GM - GAS METER
 - GP - GUY POLE
 - GV - GAS VALVE
 - GW - GUY WIRE
 - HC - HANDICAP
 - HW - HEADWALK
 - HWF - HOG WIRE FENCE
 - IE - INVERT ELEVATION
 - IPF - IRON PIN FOUND
 - IPS - IRON PIPE SET
 - JB - JUNCTION BOX
 - LL - LAND LOT
 - LL - LAND LOT LINE
 - LP - LIGHT POLE
 - MH - MANHOLE
 - MON - MONUMENT
 - NF - NOW OR FORMERLY
 - OT - OPEN TOP PIPE
 - PBX - POWER BOX / TRANSFORMER
 - P - OVERHEAD POWER LINE
 - PJT - OVERHEAD POWER & TELEPHONE LINE
 - PL - PROPERTY LINE
 - PM - POWER METER
 - POB - POINT OF BEGINNING
 - PP - POWER POLE
 - PTP - POWER & TELEPHONE POLE
 - PVC - POLYVINYLCHLORIDE PIPE
 - RB - REINFORCING IRON BAR
 - RCF - REINFORCED CONCRETE PIPE
 - RW - RIGHT OF WAY
 - SS - SANITARY SEWER LINE
 - SSE - SANITARY SEWER EASEMENT
 - SI - SIDEWALK
 - SW - SINGLE WING CATCH BASIN
 - TBM - TEMPORARY BENCHMARK
 - TBX - TELEPHONE BOX
 - TF - TRANSFORMER
 - TMH - TELEPHONE MANHOLE
 - TP - TELEPHONE POLE
 - TPOB - TRUE POINT OF BEGINNING
 - TJ - OVERHEAD TELEPHONE LINE
 - UP - UNDERGROUND POWER
 - UT - UNDERGROUND TELEPHONE
 - WI - WEIR INLET
 - W - WATER LINE
 - WM - WATER METER
 - WMH - WATER MANHOLE
 - WV - WATER VALVE

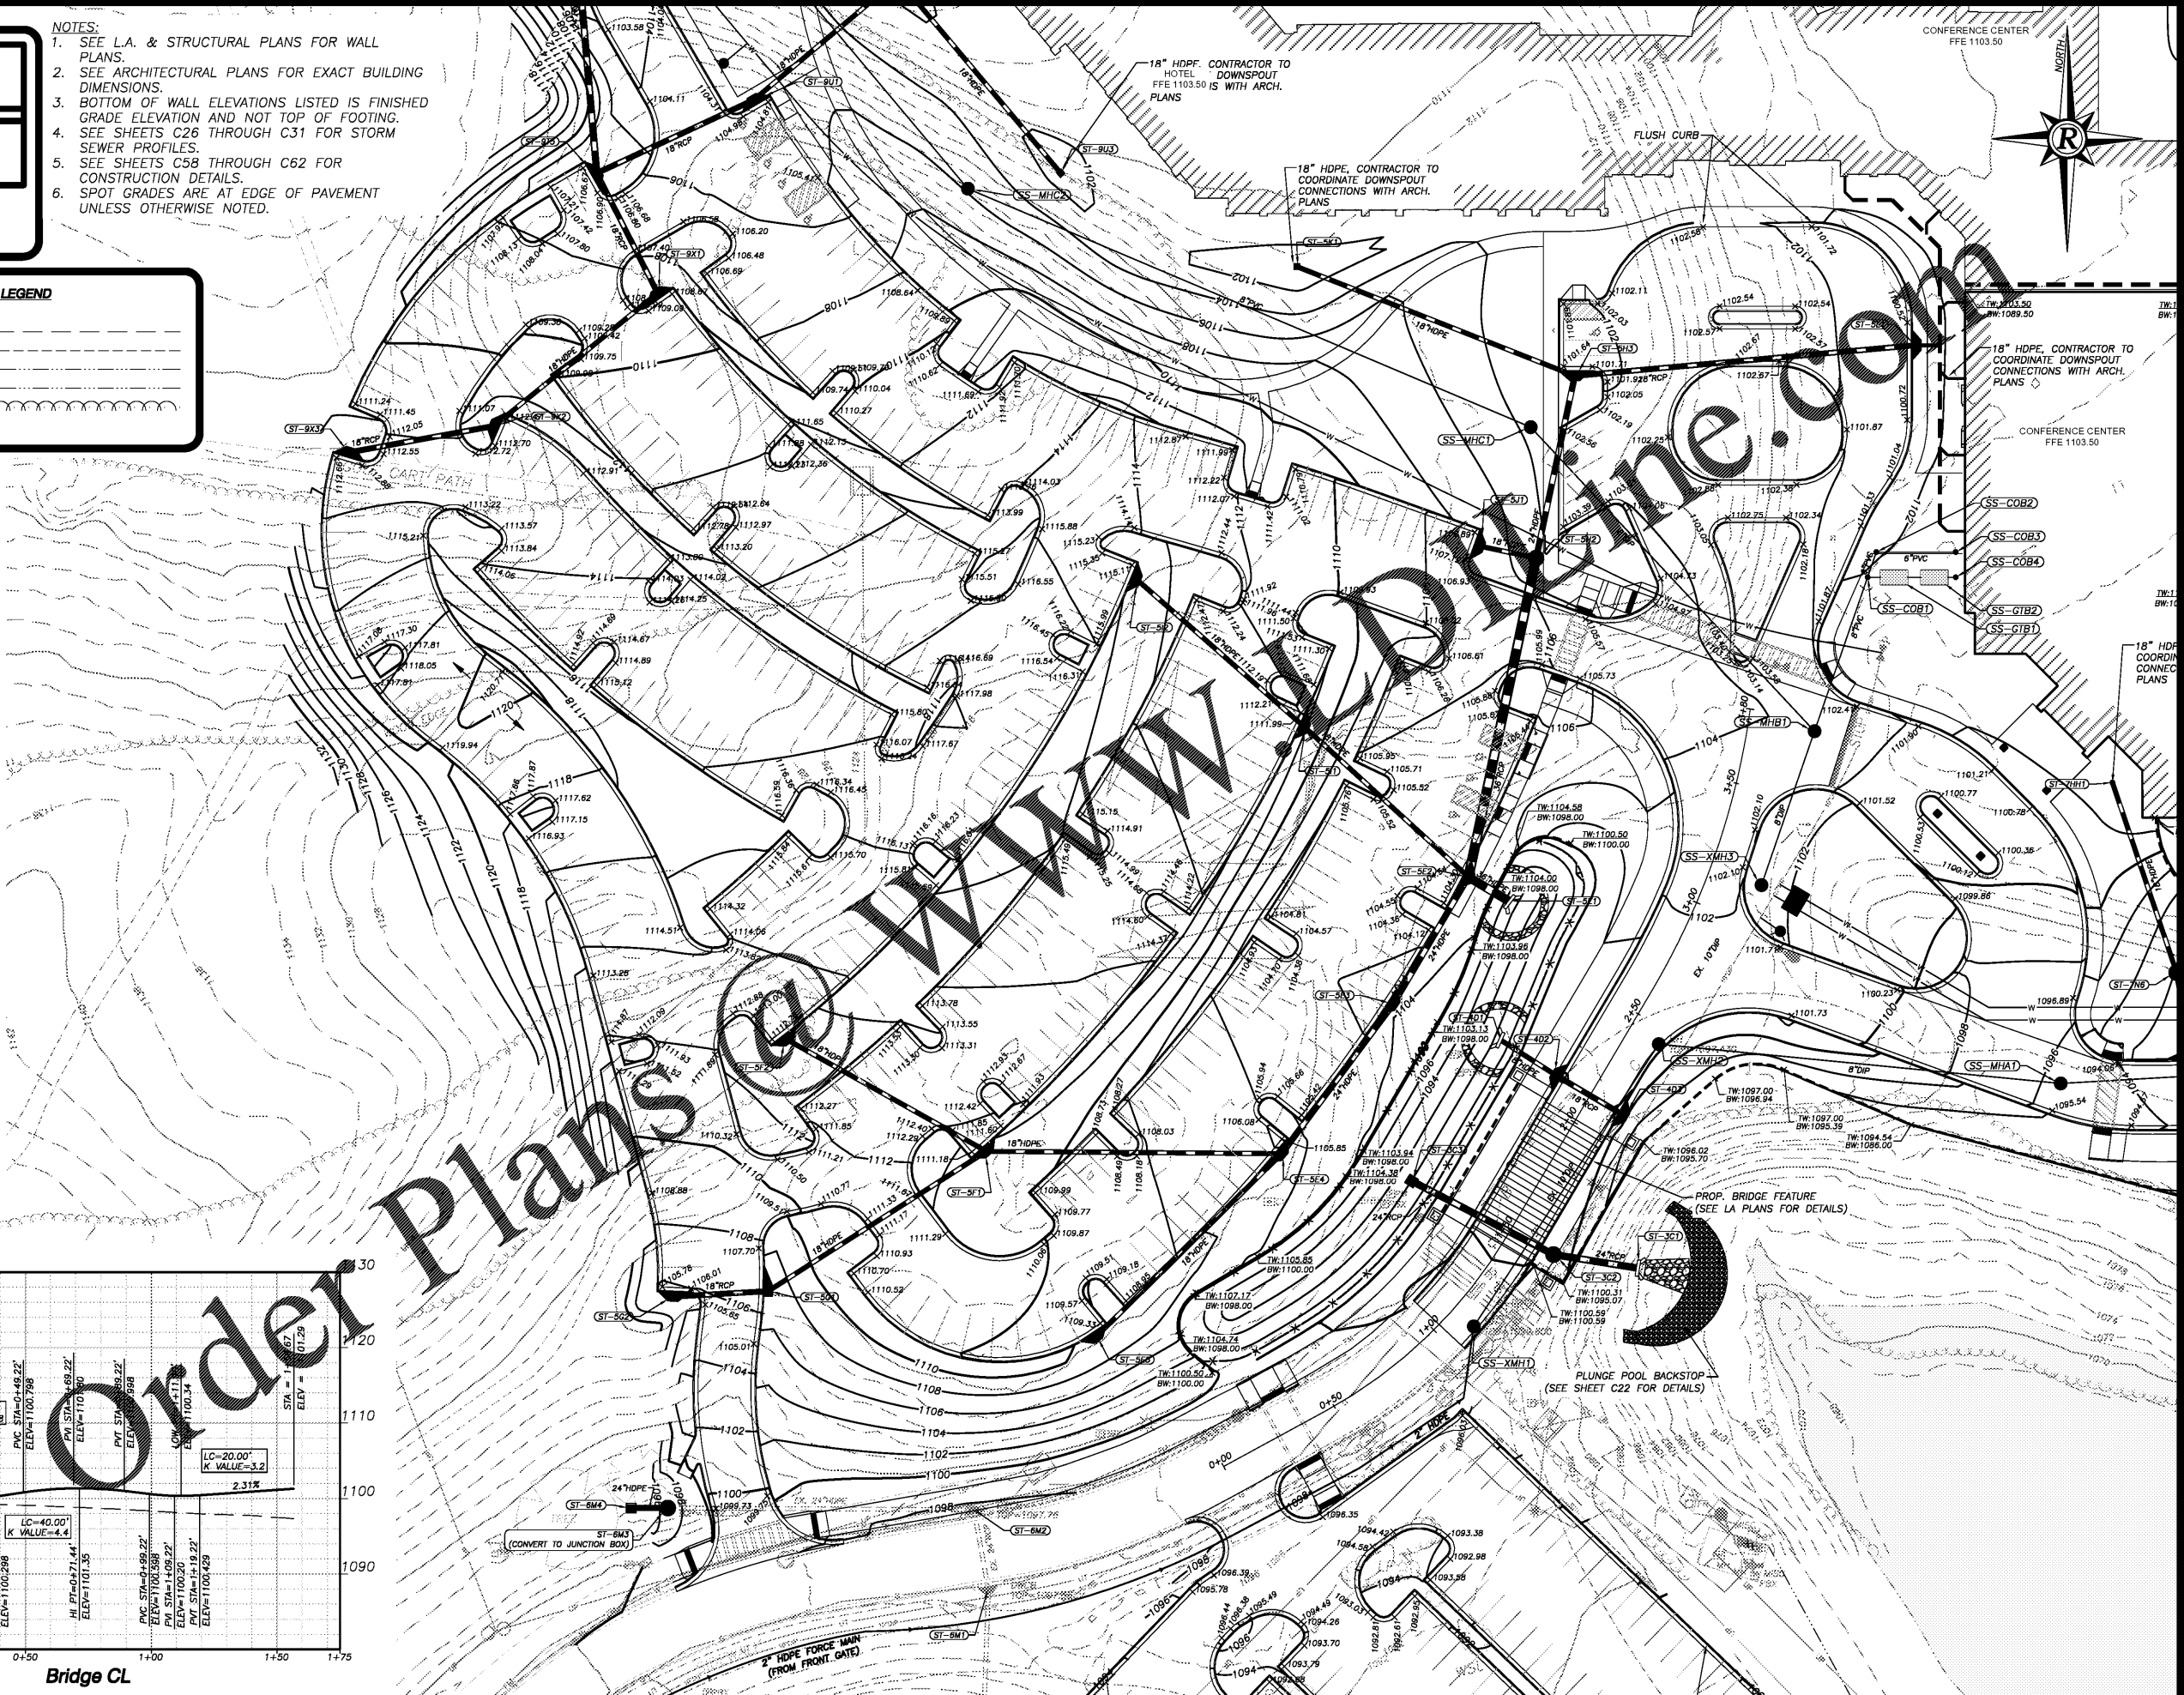

GRADING & DRAINAGE PLAN 2
 FOR
**LANIER ISLANDS
 CONFERENCE CENTER**
 LAND LOT 380
 7TH DISTRICT
 CITY OF BUFORD, HALL COUNTY, GEORGIA

REVISIONS

NO.	REV. DATE	DESCRIPTION

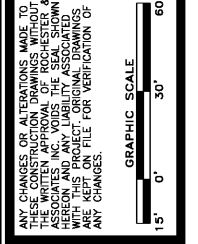

SHEET
C17
 OF
C66
 DATE: 12-11-20
 SCALE: 1"=30'
 JOB NO.: 020614.KC.01
 REVD BY: JNC
 DRAWN BY: JRS