


PLUMBING NOTED BY SYMBOL "○"

- 1 4" SANITARY UTILITY CONNECTION LOCATION. INVERT ELEVATION 962.0 BASED ON A FFE OF 996.0. REFERENCE CIVIL FOR CONTINUATION.
- 2 3" VENT FROM SAMPLE WELL & SAND/OIL INTERCEPTOR FROM BELOW GRADE UP THROUGH WALL TO VTP. REFERENCE SHEET P2.1 FOR CONTINUATION ABOVE SLAB.
- 3 NEW 6" PIPE WATER MAIN FROM CITY. REFERENCE CIVIL FOR CONNECTION POINT. PROVIDE WATER CONNECTION FROM 3" OUTSIDE BUILDING INTO FIRE RISER CLOSET. REFERENCE SHEET 01/P0.3 FIRE RISER DETAIL.
- 4 NEW 2" - 2 PSI GAS LINE DOWN FROM METER TO BELOW GRADE. CONTRACTOR SHALL REFERENCE CIVIL AND SHEET P2.1 FOR CONTINUATION.
- 5 NEW 1-1/2" DOMESTIC WATER IN FROM CITY MAIN. REFERENCE/COORDINATE WITH CIVIL ON FINAL LOCATION. ROUTE FROM 3" OUTSIDE OF BUILDING INTO FIRE RISER ROOM AND UP THROUGH SLAB INTO FIRE RISER ROOM. REFERENCE P2.1 FOR ABOVE SLAB CONTINUATION.
- 6 CONTRACTOR IS TO PROVIDE GREY WATER TRAP PRIMER FROM TAIL PIECE OF LAV2 TO FLOOR DRAIN. REFERENCE SHEET P0.2/05 FOR DETAIL.
- 7 OIL/SAND TRAP FINAL LOCATION IS TO BE COORDINATED WITH ARCHITECT/OWNER PRIOR TO CONSTRUCTION. REFERENCE SHEET P0.3/05.
- 8 ELECTRONIC TRAP PRIMER IN WALL. CONTRACTOR IS TO CONNECT FLOOR DRAIN AND FLOOR SINK TO TRAP PRIMER AS REQUIRED. CONNECT 1/2" WATER LINE UP IN WALL. PROVIDE ACCESS PANEL. REFERENCE SHEET P2.1 FOR CONTINUATION TO ABOVE SLAB PLAN. REFERENCE SHEET P0.2/04 FOR DETAIL.
- 9 UTILITY CONNECTION LOCATION. REFERENCE CIVIL FOR CONTINUATION.

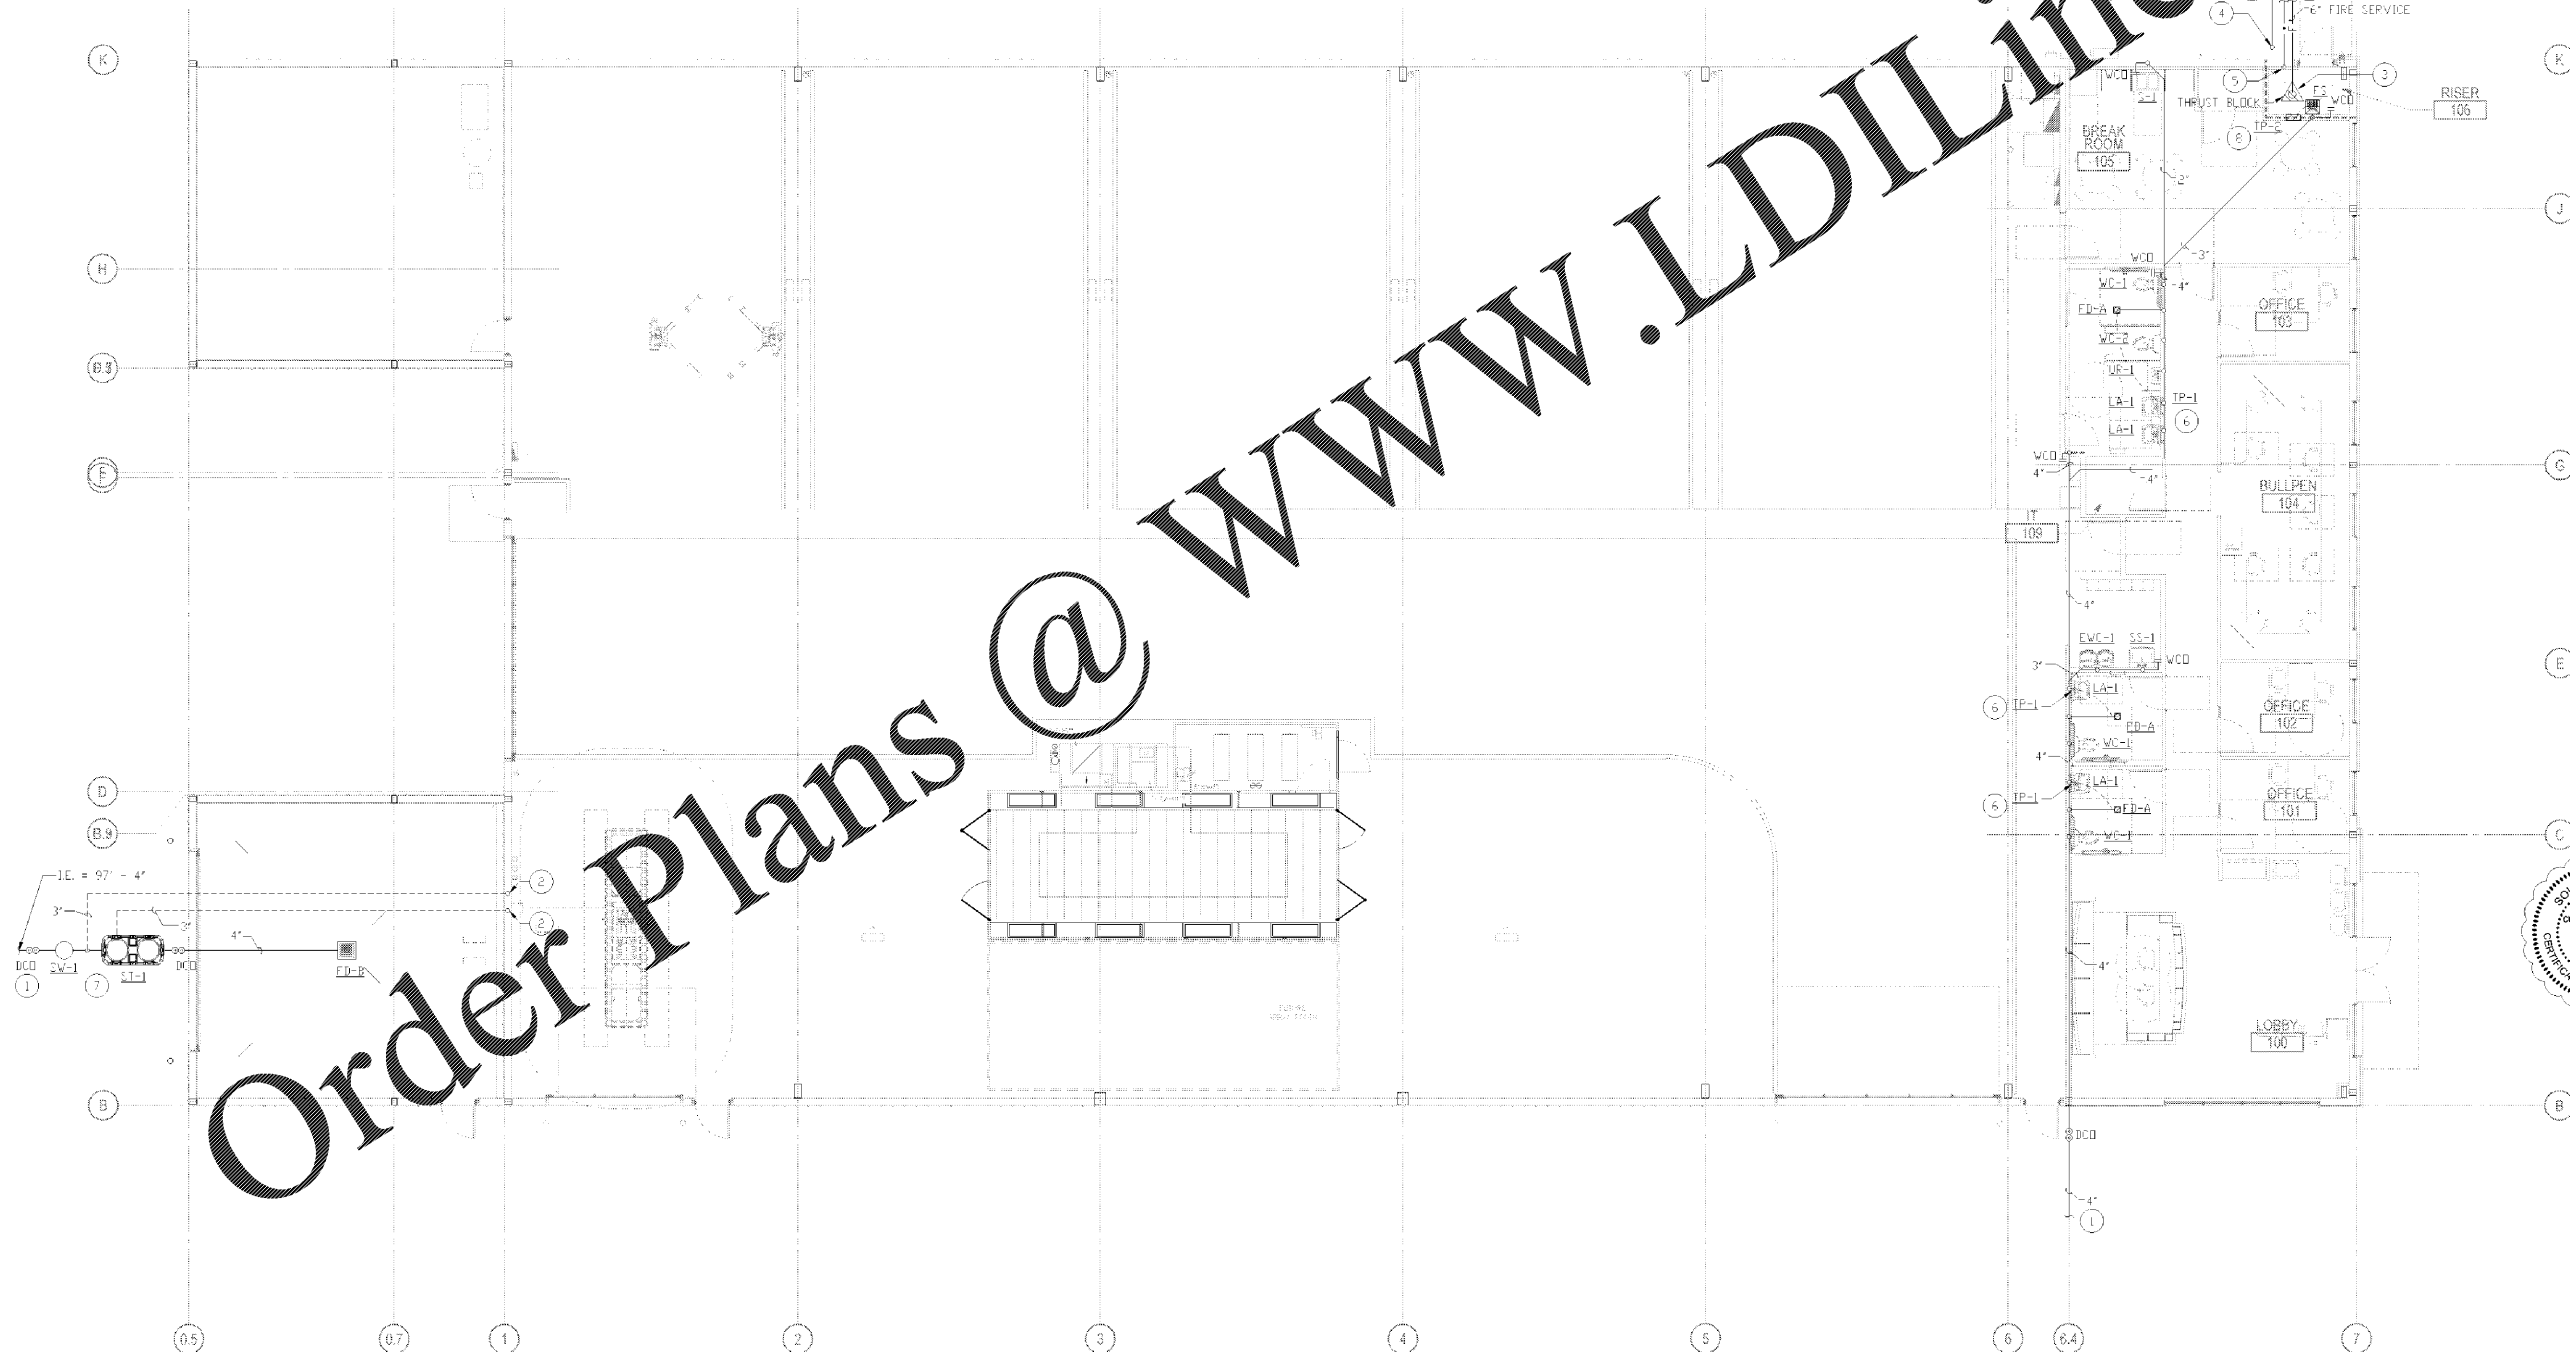


1925 Prospect Ave.  
Orlando, FL 32814  
P (407) 661-9100  
F (407) 661-9101  
www.cp.com  
Florida Corporate Certificate #AA 006025



CLIENT NAME  
**Cross Development**  
4338 March Ridge  
Carrollton, TX 75010

PROJECT NAME  
**Caliber Collision Five Forks (161)**  
1215 East Butler Rd.  
Greenville, SC 29607

SHEET TITLE  
**Plumbing Under Floor Plan**

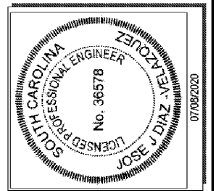

PROJECT NO.	2200057
DATE	07/06/2020
DRAWN	BHA
CHECKED	ECB

RELEASE

P2.0