



DATA SCHEDULE				VOICE SCHEDULE				OWNER FURNISHED, GC INSTALLED...	
CABLE	LOCATION-DESCRIPTION	TYPE	PH	CABLE	LOCATION-DESCRIPTION	TYPE	PH	PHONE MODEL	RESTRICT Y/N/TOLL
D-VC01	VISION CENTER	PRT	2	V-191	VISION CENTER	DESK	2	7960	N
D-VC02	VISION CENTER	TERM	2	V-192	VISION CENTER	DESK	2	7960	N
D-VC03	VISION CENTER	TERM	2	V-193	VISION CENTER	DESK	1	7960	N
D-VC04	VISION CENTER	TERM	2	V-194	VISION CENTER	DESK	1	7960	N
D-VC05	VISION CENTER	TERM	2	V-195	VISION CENTER	WALL	1	7960	N
D-VC06	VISION CENTER	TERM	2	V-196	VISION CENTER	DESK	2	7960	N
D-VC07	VISION CENTER	PRT	2	V-197	VISION CENTER	DESK	2	7960	N
D-REG08	VISION CENTER	REG	2	V-295	VISION CENTER	DESK	1	7960	N
D-OPT01	VISION CENTER	TERM	1	V-964	VISION CENTER	FAX	2		
D-EMR01	VISION CENTER	PC	2	V-965	VISION CENTER	MODEM	2		
D-EMR02	VISION CENTER	PC	2	V-966	VISION CENTER	MODEM	1		
D-VCTV-1	VISION CENTER	TV	2	V-969	VISION CENTER	FAX	2		
D-VCTV-2	VISION CENTER	TV	2						
D-VCTV-3	VISION CENTER	TV	2						


EQUIPMENT SCHEDULE	
VC0001	REGISTER PRINTER
VC0002	DRIVER
VC0003	DESK READER
VC0004	POS S GUN
VC0005	SHRED
VC0006	FLAT PANEL MONITOR
VC0007	KEYBOARD AND MOUSE
VC0008	PHONE
VC0009	MONITOR ARM
VC0010	REGISTER KEYPAD MONITOR
VC0011	COMPACT FRAME WARMER
VC0012	DIGITAL DISPLAY
VC0013	REGISTER CPU
VC0014	MINI CPU
VC0015	FRAME WARMER
VC0016	SENSORMATIC
VC0017	PHOTO COPIER
VC0018	SENSORMATIC CPU
VC0019	HAND EDGER
VC0020	POS FLAG DISPLAY
VC0021	REMOTE TRACER
VC0022	CLEANER
VC0023	CREDENTIALS BOARD
VC0024	BLUETOOTH IMAGER OPT SCAN GUN

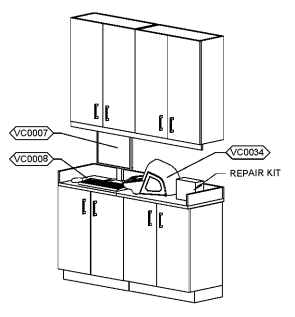


8 EQUIPMENT - PROCESSING ROOM

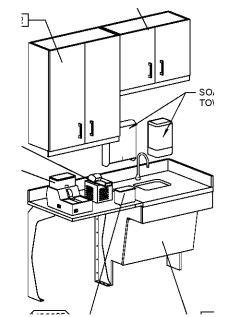


7 EQUIPMENT - PROCESSING ROOM SINK

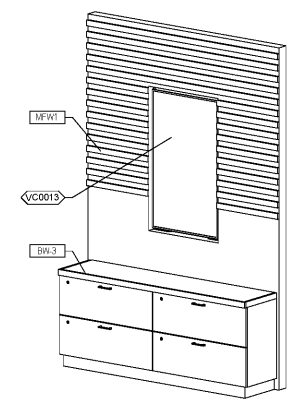


6 EQUIPMENT - DIGITAL DISPLAY

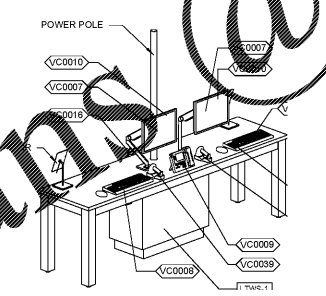


5 EQUIPMENT - LOW TABLE

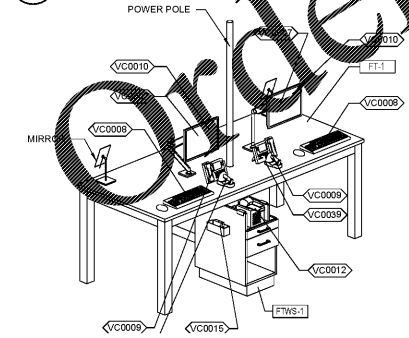


4 EQUIPMENT - FAMILY TABLE

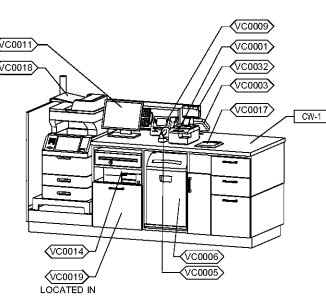

3 EQUIPMENT - CASHWRAP

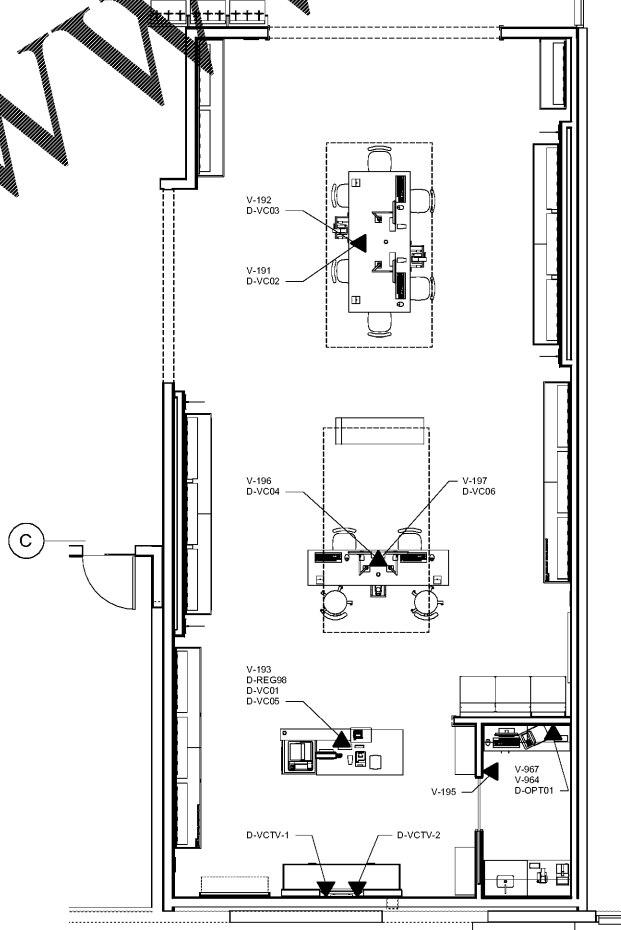

2 VISION CENTER VOICE / DATA PLAN
1/4" = 1'-0"

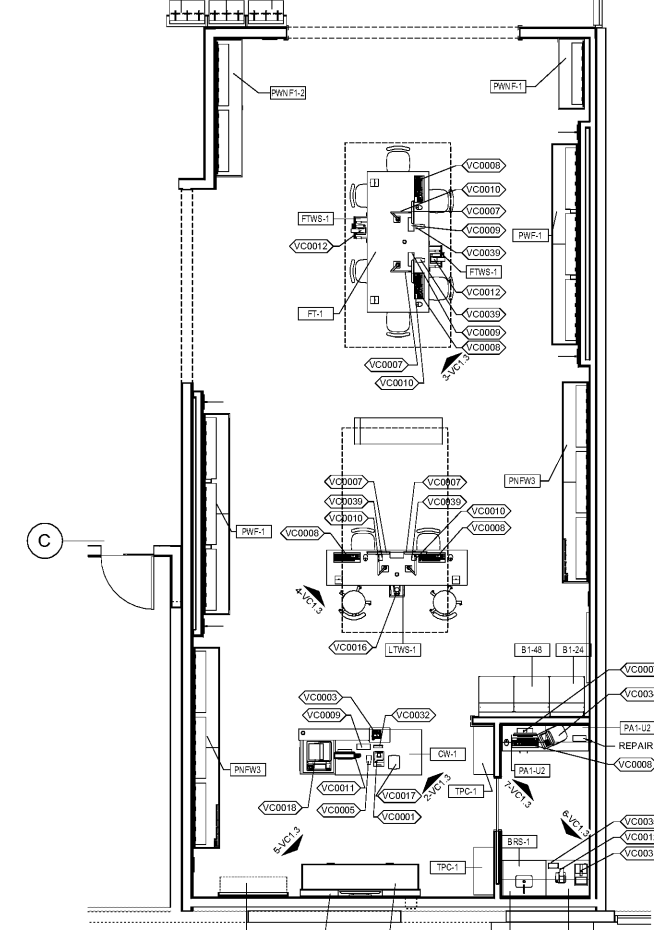

1 VISION CENTER EQUIPMENT PLAN
1/4" = 1'-0"

brr

ARCHITECT OF RECORD:
JOHN P. FRANK
515 N. HIGHWAY 400, SUITE 100
WILMINGTON, NC 28403
www.brrinc.com
TEL: 910-342-9395
FAX: 910-342-9344

STIPULATION FOR REUSE:
THIS IS A PRELIMINARY DRAWING FOR INFORMATIONAL PURPOSES ONLY AND IS NOT TO BE USED FOR CONSTRUCTION. ANY REUSE OF THIS DRAWING WITHOUT THE WRITTEN PERMISSION OF THE ARCHITECT OF RECORD IS PROHIBITED. THE ARCHITECT OF RECORD SHALL NOT BE RESPONSIBLE FOR ANY ERRORS OR OMISSIONS IN THIS DRAWING.

CONSULTANTS:

Walmart
ATLANTA (GRESHAM), GA
2427 GRESHAM RD SE 30316
STORE NO. 03709-233
JOB NUMBER: 8645888 | PHOTO: 185

ISSUE BLOCK

NO.	DESCRIPTION	DATE

CHECKED BY: MED
DRAWN BY: MED
PHOTO CYCLE: 10/30/20
DOCUMENT DATE: 11/20/20

NOT FOR CONSTRUCTION

THIS SHEET IS INCLUDED FOR INFORMATIONAL PURPOSES ONLY AND IS NOT TO BE SIGNED

VISION CENTER EQUIPMENT (FOR REFERENCE ONLY)

SHEET: VC.1.3

VC.1.3 (REV. 11/20/20)
185 (REV. 11/20/20) Walmart (Gresham), GA, 185, R_ARCH_VISION