

Order Plans @ www.LDILine.com

KEYNOTES

15.405 PROPERLY CAP, PLUG AND CONCEAL ANY PIPING LEFT IN PLACE. CAP ABANDONED SEWER FLOOR. MATCH EXISTING FLOOR CONSTRUCTION AND FINISHES. RE. ARCHITECTURAL PLANS. REMOVE UNUSED WATER AND VENT PIPING ABOVE CEILING AND CAP REMAINING PIPE.



ARCHITECT OF RECORD:
 JOHN P. FRANK
 8211 MEDICAL AVENUE
 OVERLAND PARK, KS 66204
 www.brrarch.com
 TEL: 913-242-9995
 FAX: 913-242-9996

STIPULATION FOR REUSE
 THIS DRAWING WAS PREPARED FOR THE CONTRACTOR'S USE ONLY. IT IS NOT TO BE REPRODUCED, COPIED, REPRODUCED, OR TRANSMITTED IN ANY FORM OR BY ANY MEANS, ELECTRONIC OR MECHANICAL, INCLUDING PHOTOCOPYING, RECORDING, OR BY ANY INFORMATION STORAGE AND RETRIEVAL SYSTEM, WITHOUT THE WRITTEN PERMISSION OF THE ARCHITECT OF RECORD. THE ARCHITECT OF RECORD SHALL NOT BE RESPONSIBLE FOR ANY REUSE OF THIS DRAWING FOR ANY OTHER PROJECT OR FOR ANY DAMAGE TO PERSONS OR PROPERTY CAUSED BY SUCH REUSE.

CONSULTANTS
HENDERSON
 ENGINEERS
 886 LEBLANC DRIVE, SUITE 300
 TEL: 770.622.0000 FAX: 770.622.0001
 WWW.HENDERSONENGINEERS.COM
 CA: CONTRACT NO. 15-002734
 EXPRESS 03/02/21

Walmart
 ATLANTA (GRESHAM)
 2427 GRESHAM RD SE 30316
 STORE NO: 137789-233
 JOB NUMBER: 216660706 | PHOTO: SPRB

ISSUE BLOCK


NO.	DESCRIPTION	DATE

CHECKED BY: JME
 DRAWN BY: HKM
 PHOTO CYCLE: 09/25/20
 DOCUMENT DATE: 11/20/20

NOT FOR CONSTRUCTION

ENLARGED PLUMBING PLANS

SHEET: P1.1

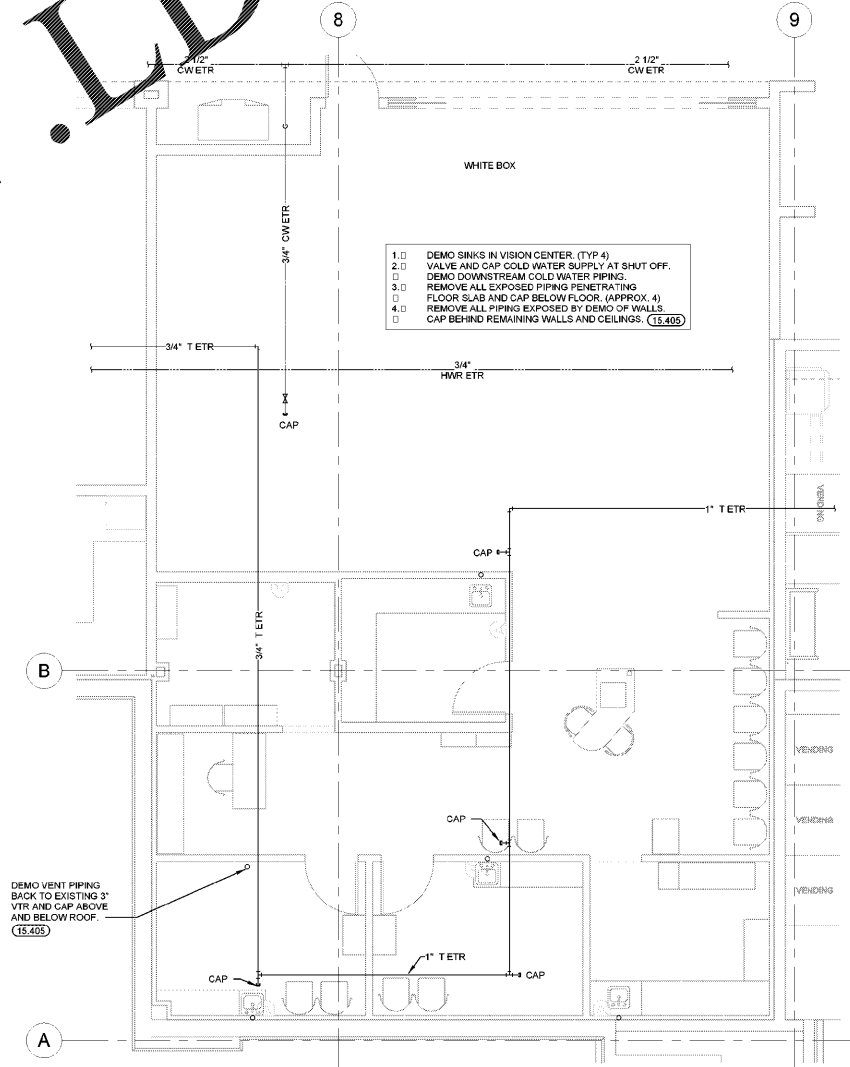

1 WHITE BOX PLUMBING PLAN
 1/4" = 1'-0"

EXISTING CONDITIONS WERE TAKEN FROM ORIGINAL DRAWINGS AND MAY NOT REFLECT EXACT "AS-BUILT" CONDITIONS. CONTRACTOR SHALL FIELD VERIFY ALL EXISTING CONDITIONS PRIOR TO SUBMITTING FINAL BIDS. CONTRACTOR SHALL CAREFULLY COORDINATE NEW WORK AND DEMOLITION WITH ALL OTHER DISCIPLINES AND EXISTING CONDITIONS.

EACH SUBCONTRACTOR IS RESPONSIBLE FOR HAVING A THOROUGH KNOWLEDGE OF ALL DRAWINGS AND SPECIFICATIONS IN THEIR RELATED FIELD. THE FAILURE TO ACQUAINT THEMSELVES WITH THIS KNOWLEDGE DOES NOT RELIEVE THE RESPONSIBILITY OF PERFORMING THE WORK PROPERLY. NO ADDITIONAL COMPENSATION SHALL BE ALLOWED BECAUSE OF CONDITIONS THAT OCCUR DUE TO FAILURE TO FAMILIARIZE WORKERS WITH THIS KNOWLEDGE.