


LIGHTING FIXTURE SCHEDULE						
TYPE	DESCRIPTION	MANUFACTURER	CATALOG NUMBER	LAMPS	VOLTAGE	WATTS
OA	AREA LIGHT, LED, POLE MOUNTED, TYPE 3 DISTRIBUTION, DARK BRONZE.	BEACON VISIONAIRE MCGRAW-EDISON	VPL-96L-315-4K7-3-UNV-DB APPROVED EQUAL	33,700 LUMENS	277	315

LIGHTING FIXTURE SCHEDULE NOTES
1. SEE LIGHTING FIXTURE SCHEDULE ON SITE ELECTRICAL AND BUILDING PLANS FOR EXACT FIXTURE CATALOG NUMBERS.

PHOTOMETRIC CALCULATIONS					
Calculation Points Name	Average	Maximum	Minimum	Average / Minimum	Maximum / Minimum
Overall Site	1.78 fc	4.64 fc	0.04 fc	49.04	127.51

PHOTOMETRIC PLAN NOTES
1. THE PHOTOMETRIC VALUES SHOWN ARE GENERATED BY A COMPUTER PROGRAM THAT CALCULATES FOOTCANDLE LEVELS AT GRADE LEVEL, WITHOUT CONSIDERATION FOR ELEVATION, CHANGES IN GRADE, OBJECTS SUCH AS TREES OR BUILDINGS, AND LIGHT FROM OTHER SOURCES. FIELD CONDITIONS WILL AFFECT PREDICTED PERFORMANCE.
2. DEFAULTS ARE BASED ON INDUSTRY ACCEPTED STANDARDS.
3. WALL-MOUNTED BUILDING LIGHT FIXTURES ARE NOT CONSIDERED IN THE PHOTOMETRIC CALCULATIONS.

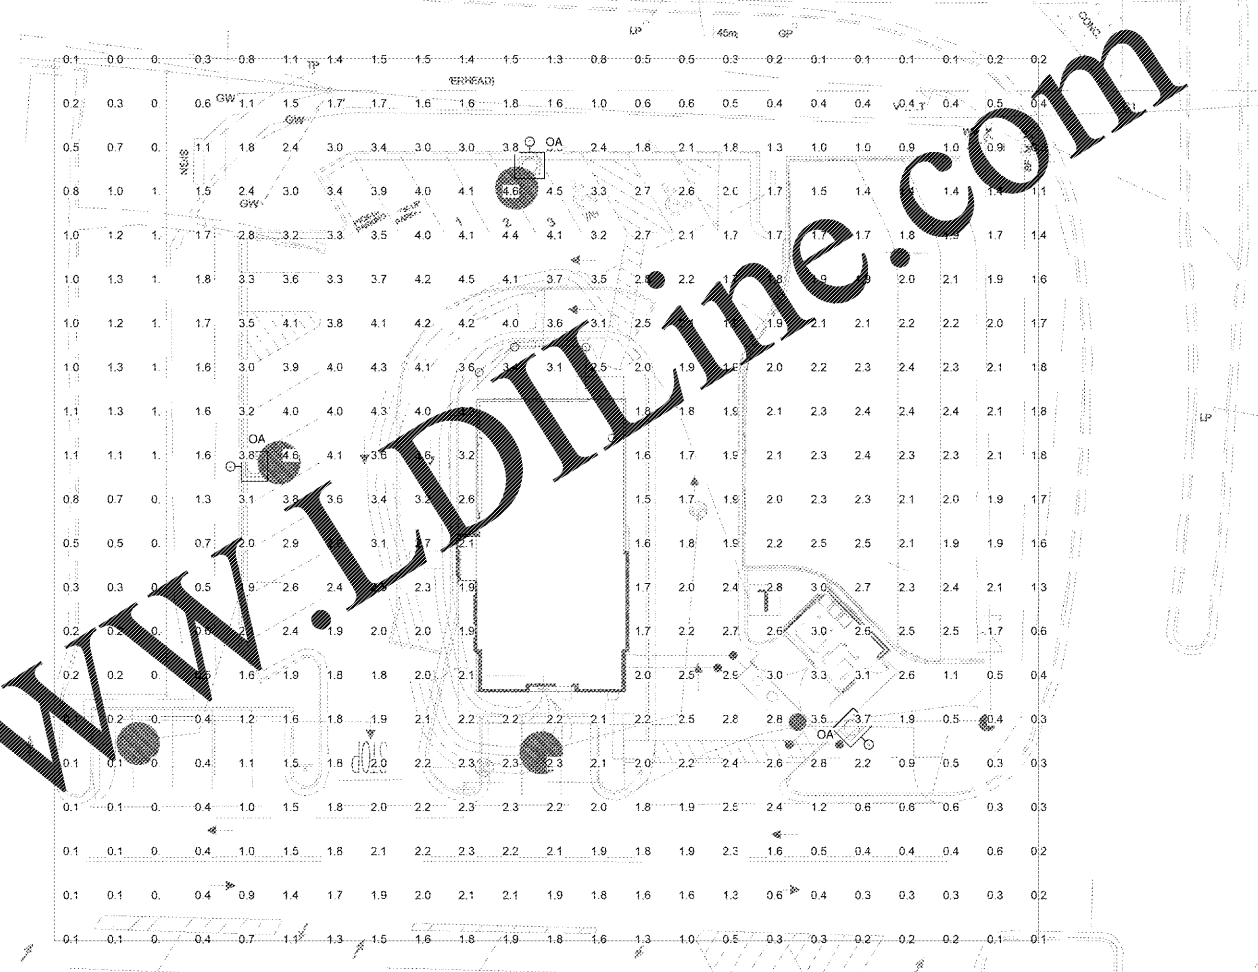

1 SITE PHOTOMETRIC PLAN  
E8.1 1" = 20'-0"

Order Plans @ www.dline.com

**ROBERSON LOIA ROOF ARCHITECTS & ENGINEERS**  
 3460 Preston Ridge Road, Suite 275 - Alpharetta, GA. 30005  
 770.674.2600 / www.rlrc.com  
 GA COA #PF000562 EXPIRES 05/31/2022

09/01/2020



CHIPOTLE AT CARTERSVILLE  
 E. MAIN STREET  
 CARTERSVILLE, GA 30121

REVISIONS

SHEET TITLE  
**SITE PHOTOMETRIC PLAN**

DATE  
 09/01/2020

PROJECT NUMBER  
 19303

SHEET NUMBER  
**E8.1**