


3  
P1.1  
1/8" = 1'-0"  
**PLUMBING ROOF PLAN**


**GAS LOADS:**  
CHIPOTLE REQUIREMENTS 1,600 CFH  
TOTAL 1,600 CFH

LOW PRESSURE GAS PIPING SIZE IS BASED ON A DEVELOPED LENGTH OF RUN OF 100'-0".

CHIPOTLE GAS PIPING REQUIREMENTS INCLUDE KITCHEN EQUIPMENT AND RTUS. CONNECTIONS WILL BE SHOWN ON TENANT BUILD OUT PLANS.

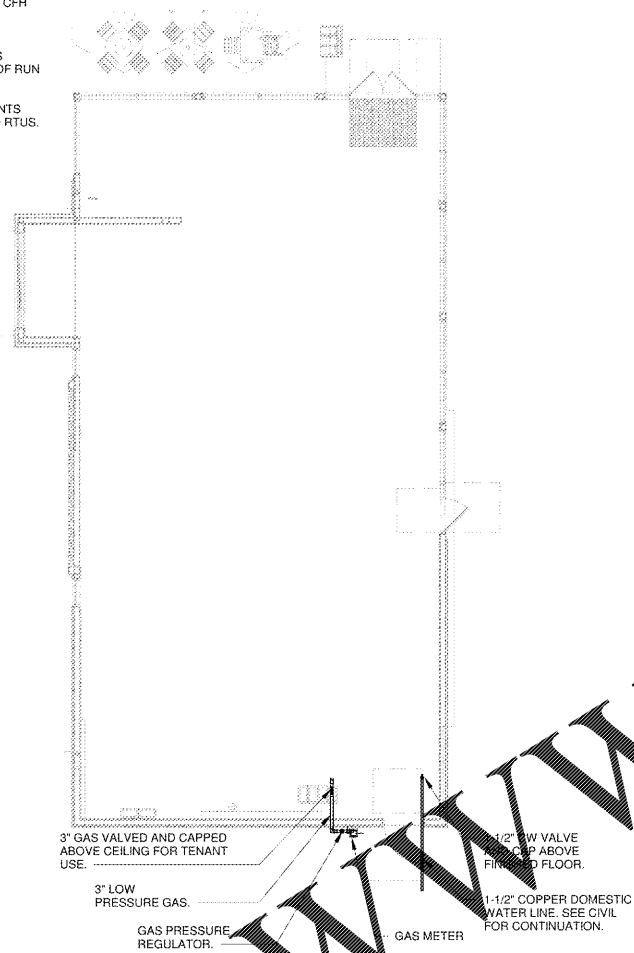

2  
P1.1  
1/8" = 1'-0"  
**PLUMBING WATER & GAS PLAN**

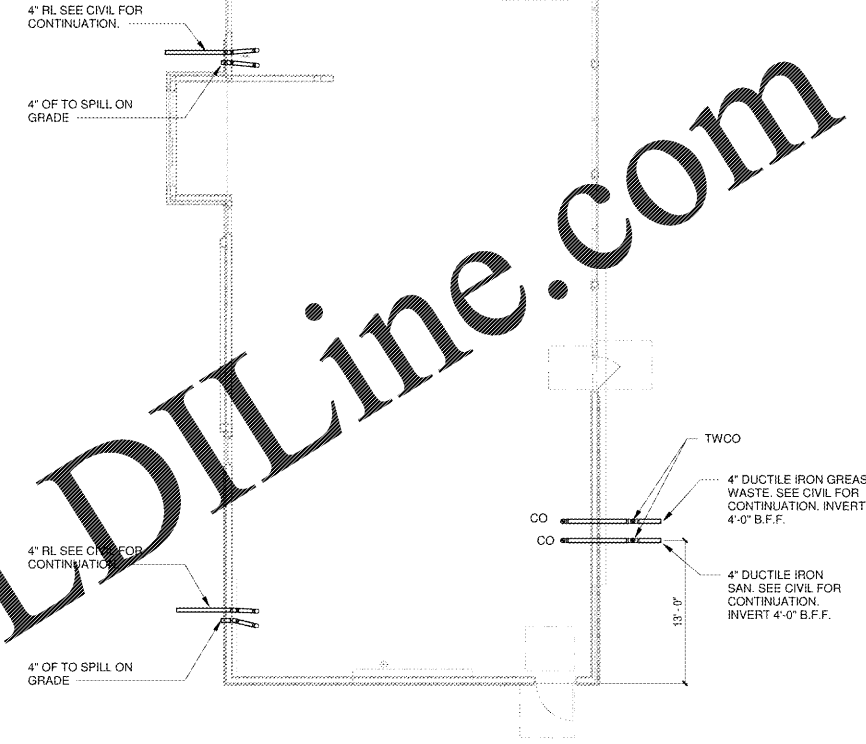

1  
P1.1  
1/8" = 1'-0"  
**PLUMBING SANITARY PLAN**

**PLUMBING GENERAL NOTES**

1. OBTAINING ALL REQUIRED PERMITS AND PAYING ALL ASSOCIATED FEES ARE THE RESPONSIBILITY OF THE CONTRACTOR. ALL WORK SHALL BE DONE IN ACCORDANCE WITH THESE PLANS, SPECIFICATIONS, LOCAL, STATE AND NATIONAL CODES.
2. ALL OBVIOUS ERRORS AND/OR OMISSIONS IN THE ABOVE MENTIONED DOCUMENTS SHALL BE CALLED TO THE ATTENTION OF THE ARCHITECT / ENGINEER PRIOR TO CONSTRUCTION.
3. THIS CONTRACTOR SHALL INSPECT THE JOB SITE WHERE THE WORK IS TO BE PERFORMED AND SHALL ACQUAINT THEMSELVES WITH THE CONDITIONS UNDER WHICH IT SHALL BE EXECUTED.
4. ALL WORK SHALL BE DONE IN ACCORDANCE WITH THESE PLANS, SPECIFICATIONS, LOCAL, STATE AND NATIONAL CODES. CERTIFICATES OF INSPECTION, WHERE REQUIRED, SHALL BE OBTAINED AND PAID FOR BY THIS CONTRACTOR AND FURNISHED TO THE OWNER.
5. IT IS THE INTENT OF THE PLANS AND SPECIFICATIONS TO PROVIDE A COMPLETE AND OPERATING INSTALLATION INCLUDING ALL OBVIOUSLY NECESSARY ITEMS EVEN THOUGH SOME ITEMS MAY NOT BE INDICATED ON THE DRAWING OR SPECIFICATIONS.
6. THE CONTRACT DRAWINGS INDICATE THE EXTENT AND GENERAL ARRANGEMENTS OF EQUIPMENT AND SYSTEMS. IF ANY DEPARTURES FROM THE CONTRACT DRAWINGS ARE DEEMED NECESSARY BY THE CONTRACTOR, DETAILS OF SUCH DEPARTURES AND REASONS THEREFORE SHALL BE SUBMITTED TO THE OWNER FOR APPROVAL. CONTRACTOR SHALL PROVIDE AS-BUILT DRAWINGS, UPON COMPLETION OF WORK, TO SHOW DEVIATIONS FROM CONSTRUCTION DOCUMENTS.
7. ALL MATERIALS AND EQUIPMENT SHALL BE NEW AND COMMERCIAL GRADE.
8. THE CONTRACTOR SHALL FURNISH ALL LABOR, MATERIALS, EQUIPMENT AND TOOLS TO PERFORM WORK AS SHOWN, NOTED OR SCHEDULED FOR A COMPLETE INSTALLATION.
9. PROVIDE DIELECTRIC UNIONS OR FITTINGS WHENEVER FERROUS AND NON-FERROUS PIPES ARE JOINED.
10. ALL PLUMBING FIXTURES AND EQUIPMENT SHALL BE INSTALLED PER MANUFACTURER'S WRITTEN INSTRUCTIONS. UNLESS OTHERWISE NOTED.
11. CONTRACTOR TO VERIFY SIZE AND LOCATIONS OF ALL SERVICES PRIOR TO COMMENCING WITH NEW WORK.
12. IT IS THE RESPONSIBILITY OF THE CONTRACTOR TO RECEIVE, OFFLOAD, AND STORE ALL PLUMBING MATERIALS WHICH ARRIVE AT THE JOB SITE.
13. ALL VALVES AND SPECIALTY ITEMS MAY NOT BE SHOWN IN EVERY INSTANCE ON THE DRAWINGS, BUT ARE TO BE PROVIDED WHETHER SHOWN OR NOT WHEN NECESSARY FOR PROPER OPERATION AND MAINTENANCE OF THE SYSTEM. VALVES AND SPECIALTY ITEMS ARE TO BE RATED AT 125 PSIG. DEVICES AND VALVES 2 1/2" AND SMALLER ARE TO HAVE SOLDERED OR SCREWED CONNECTIONS.

**SITE UTILITY NOTE:**

PLUMBING CONTRACTOR SHALL COORDINATE THE LOCATION OF ALL PIPING FOR CONNECTION TO THE APPROPRIATE UTILITY AS SHOWN ON THE UTILITY PLAN. THIS CONTRACTOR SHALL MAKE FINAL CONNECTION TO THE RECEIVING UTILITY.

Order Plans @

WWW.LDILine.com



**CHIPOTLE AT CARTERSVILLE**  
E. MAIN STREET  
CARTERSVILLE, GA 30121

REVISIONS

**SANITARY, WATER, & GAS PIPING PLAN**

DATE: 12/30/20

PROJECT NUMBER: 19303

SHEET NUMBER: P1.1