



© 2018 COLEMAN COMPANY, INC. DATE PLOTTED: 12/26/2020 10:07 AM BY: Randy Richter DRAWING PATH: G:\2020\20-265\000\DWG\Civil\20-265-C PipeMaker Canal Pooler Parkway US 120720.dwg

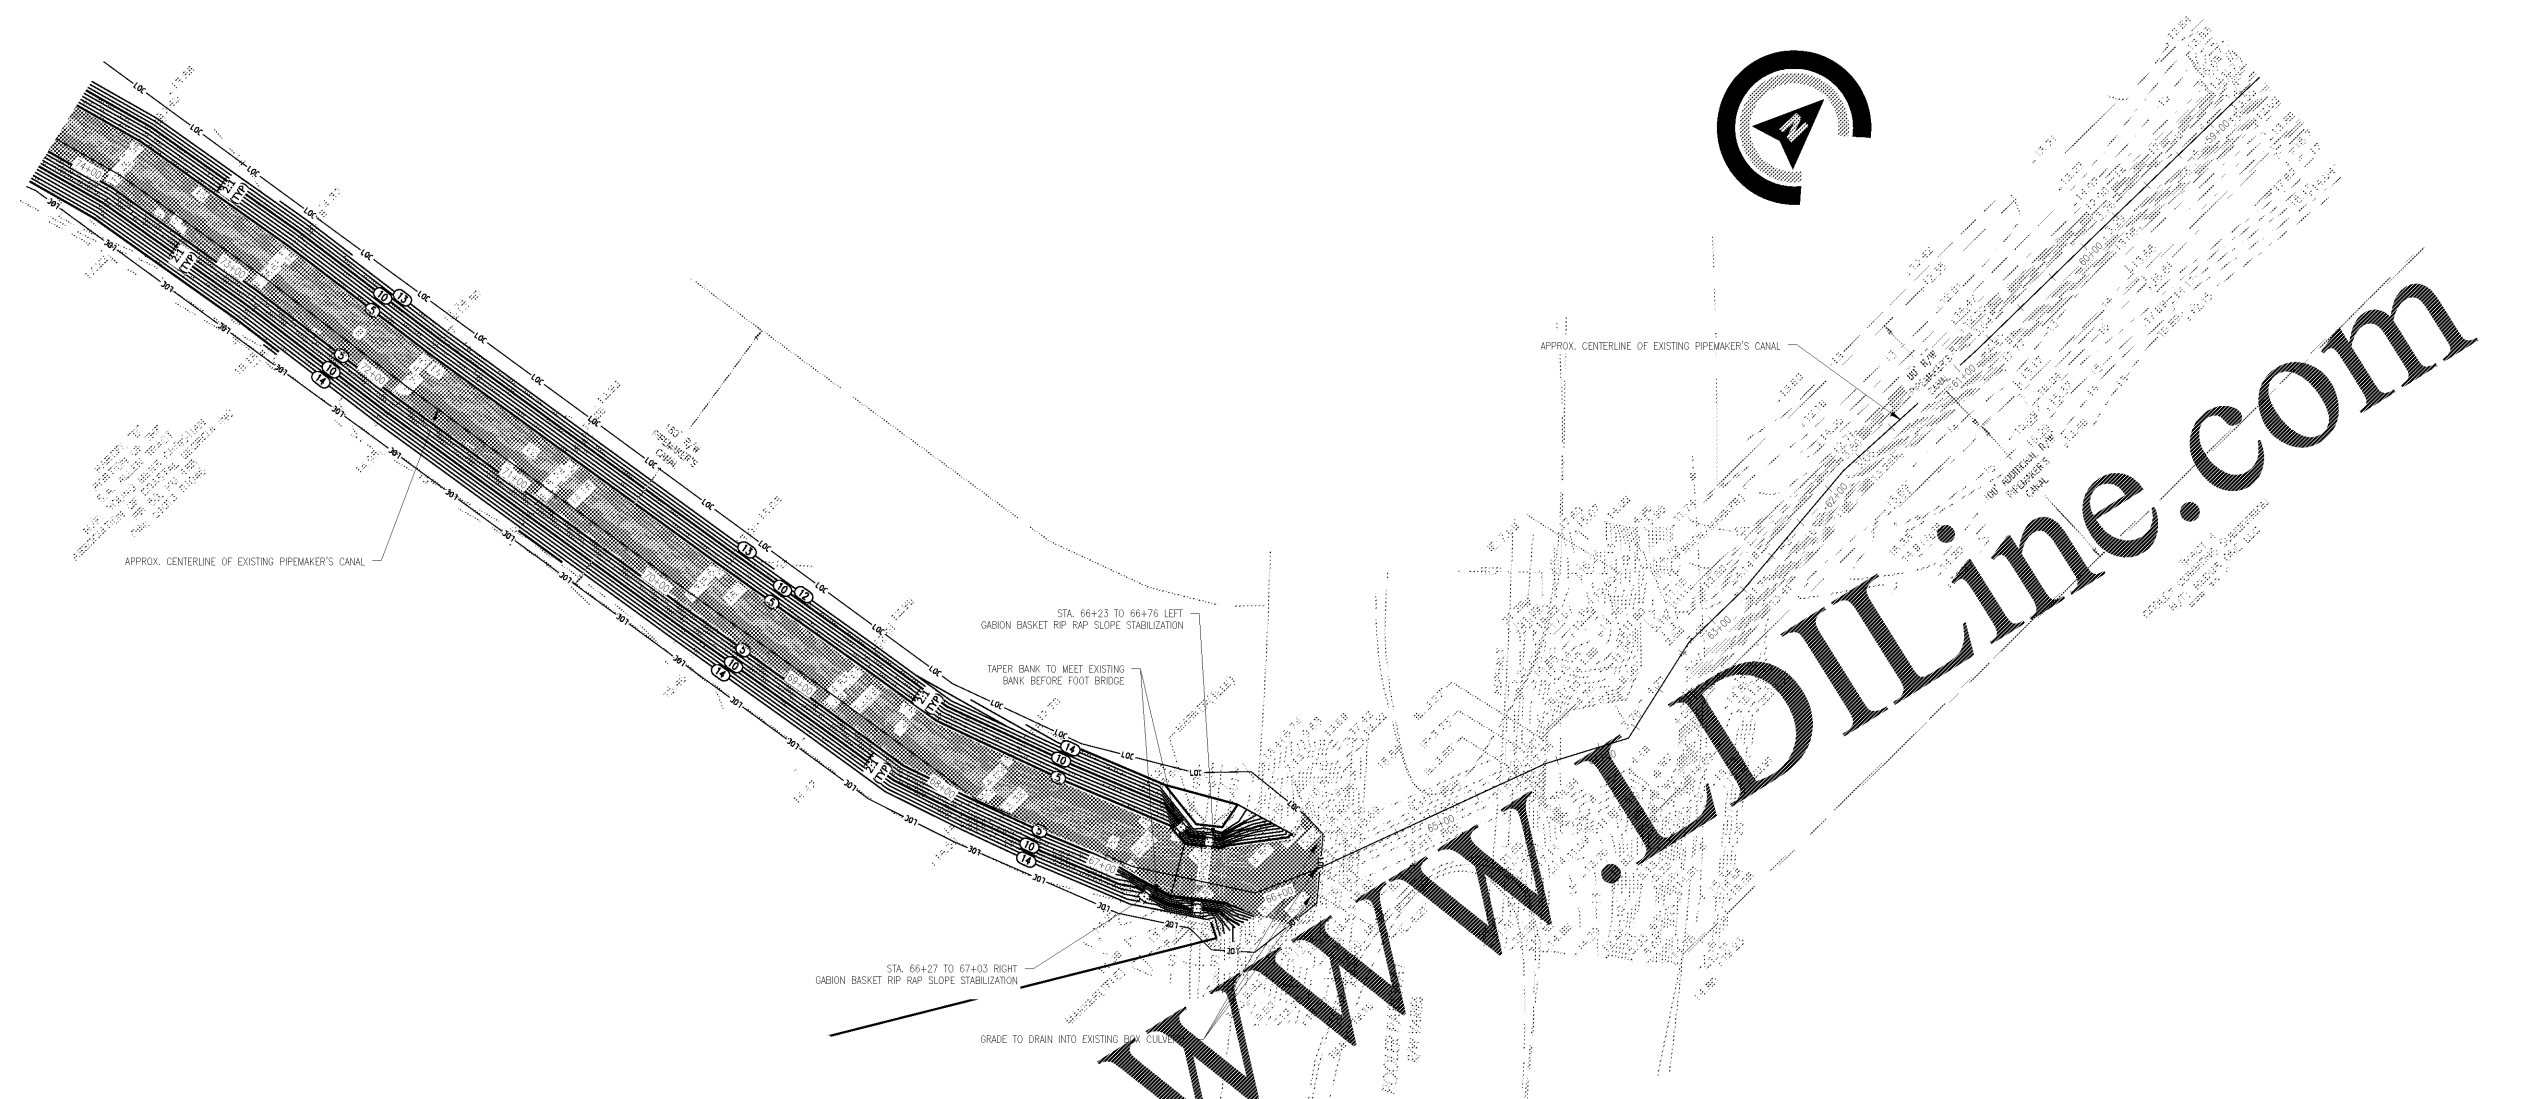

Order Plans @

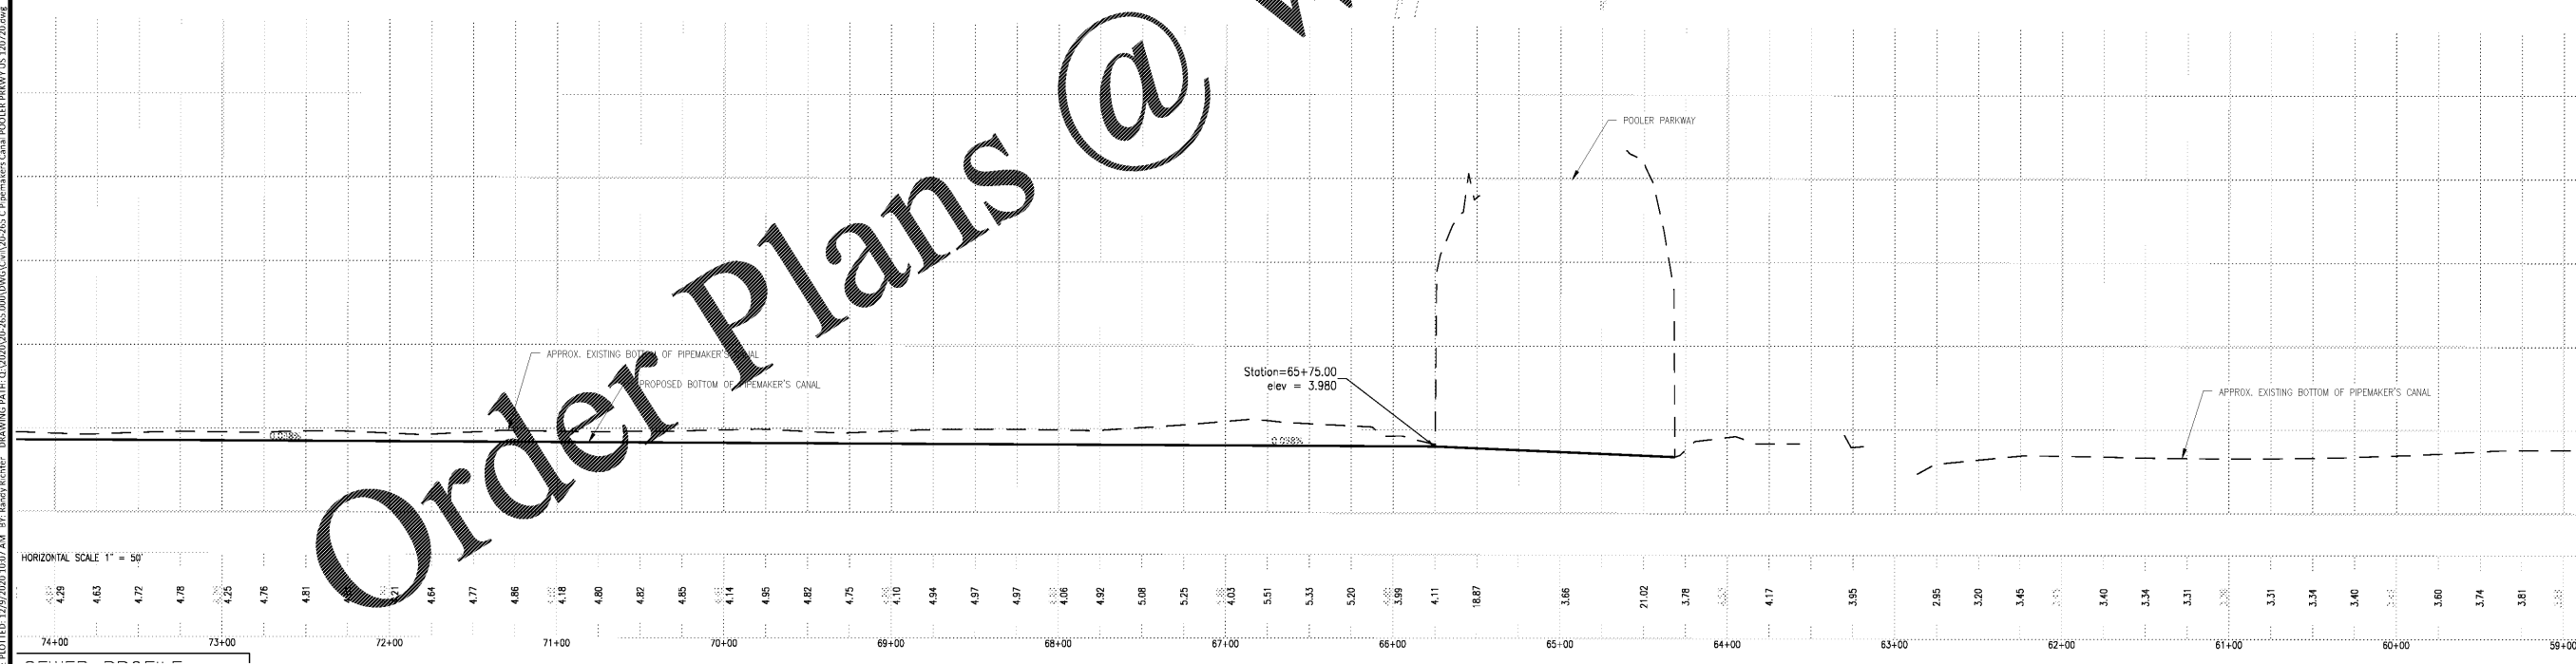

HORIZONTAL SCALE 1" = 50'

SCALE: 1" = 5' - VERTICAL
SCALE: 1" = 50'



COLEMAN COMPANY
ENGINEERS • SURVEYORS
Savannah, Georgia | (912) 260-3841 | CCI-SAV.COM

RELEASED FOR CONSTRUCTION

TRAVIS G. G...

REVISIONS:

CIVIL CONSTRUCTION PLANS FOR
PIPE MAKER'S CANAL IMPROVEMENTS
LOCATED IN POOLER, GA
PREPARED FOR CITY OF POOLER

JOB NUMBER: 20-265
DATE: 06/05/20
DRAWN BY: RAR
CHECKED BY: TGB
SCALE: AS NOTED

PLAN AND PROFILE

SHEET:
C1.1