

RELEASED FOR CONSTRUCTION

 


REVISIONS:

CIVIL CONSTRUCTION PLANS FOR
PIPE MAKER'S CANAL IMPROVEMENTS
 LOCATED IN POOLER, GA
 PREPARED FOR CITY OF POOLER

JOB NUMBER: 20-265
 DATE: 06/05/20
 DRAWN BY: RAR
 CHECKED BY: TGB
 SCALE: AS NOTED

PLAN AND PROFILE

SHEET:
C1.2

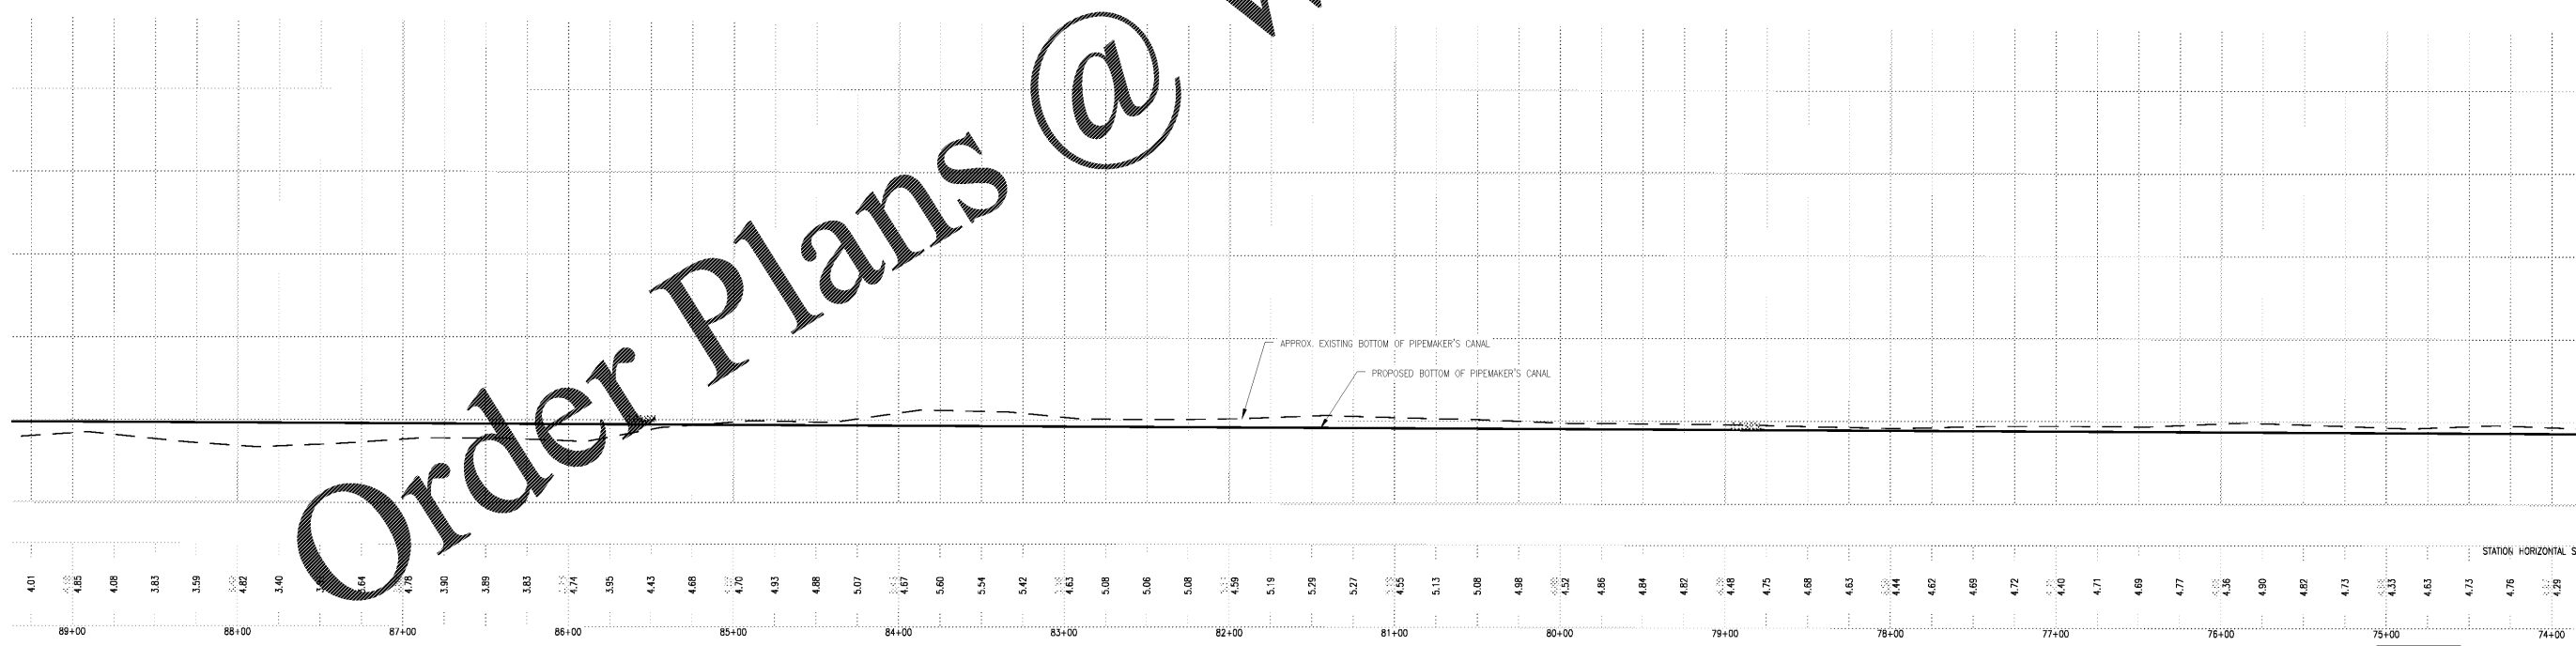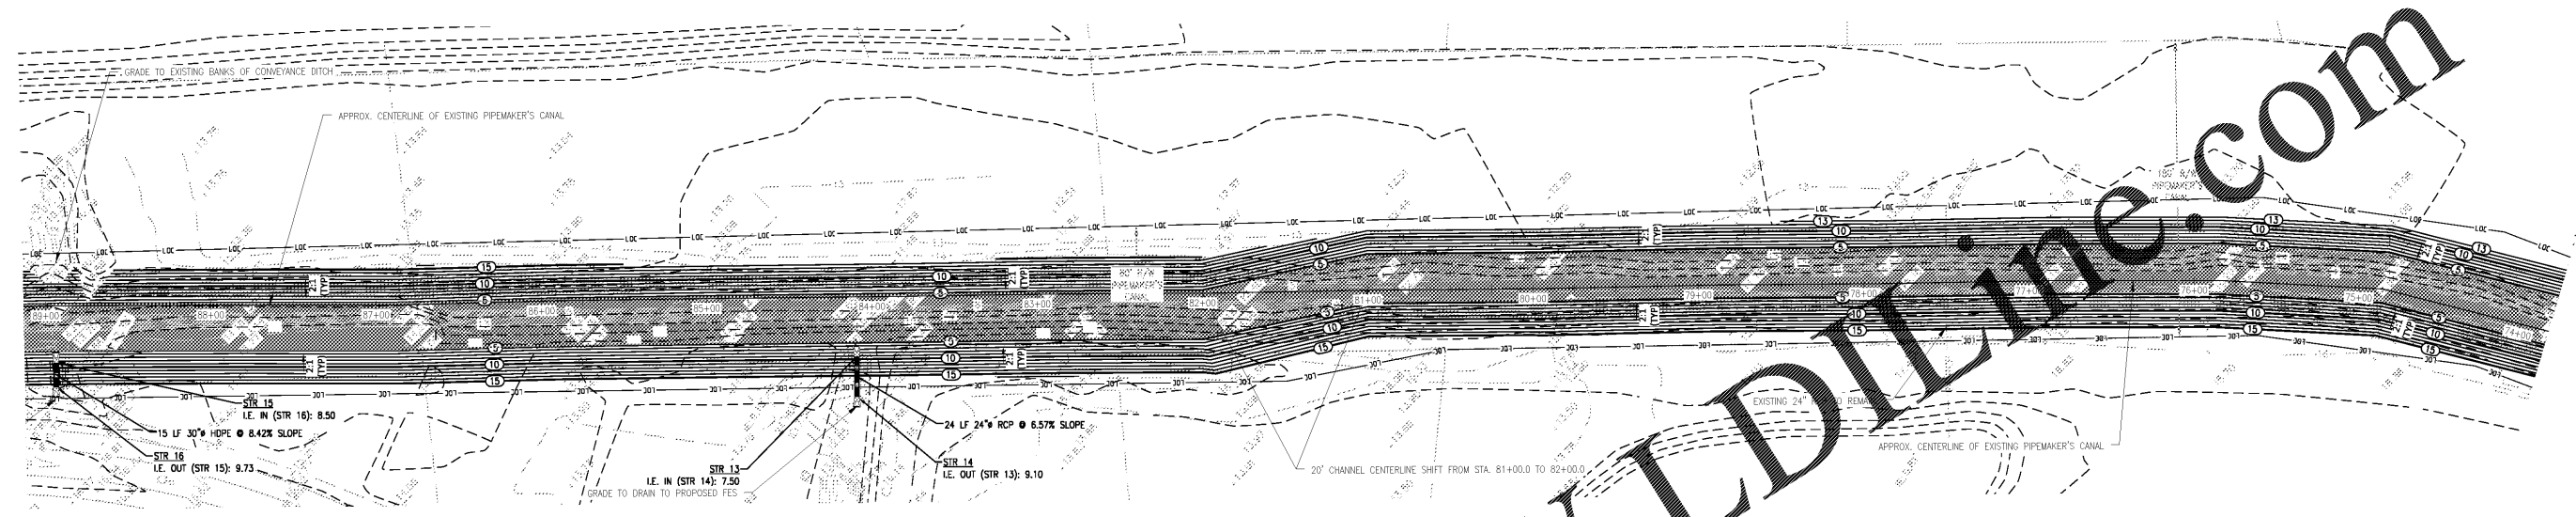

Order Plans @ www.LDLine.com

© 2018 COLEMAN COMPANY, INC. DATE PLOTTED: 12/29/2020 10:11 AM BY: Randy Richter DRAWING PATH: G:\2020\20-265\000\DWG\Civil\20-265-C Pipe-maker Canal POOLER PREVIEW US 12/29/20.dwg