

 


REVISIONS:


CIVIL CONSTRUCTION PLANS FOR  
**PIPE MAKER'S CANAL IMPROVEMENTS**  
LOCATED IN POOLER, GA  
PREPARED FOR CITY OF POOLER

JOB NUMBER: 20-265  
DATE: 06/05/20  
DRAWN BY: RAR  
CHECKED BY: TGB  
SCALE: AS NOTED

PLAN AND PROFILE

SHEET:  
**C1.3**

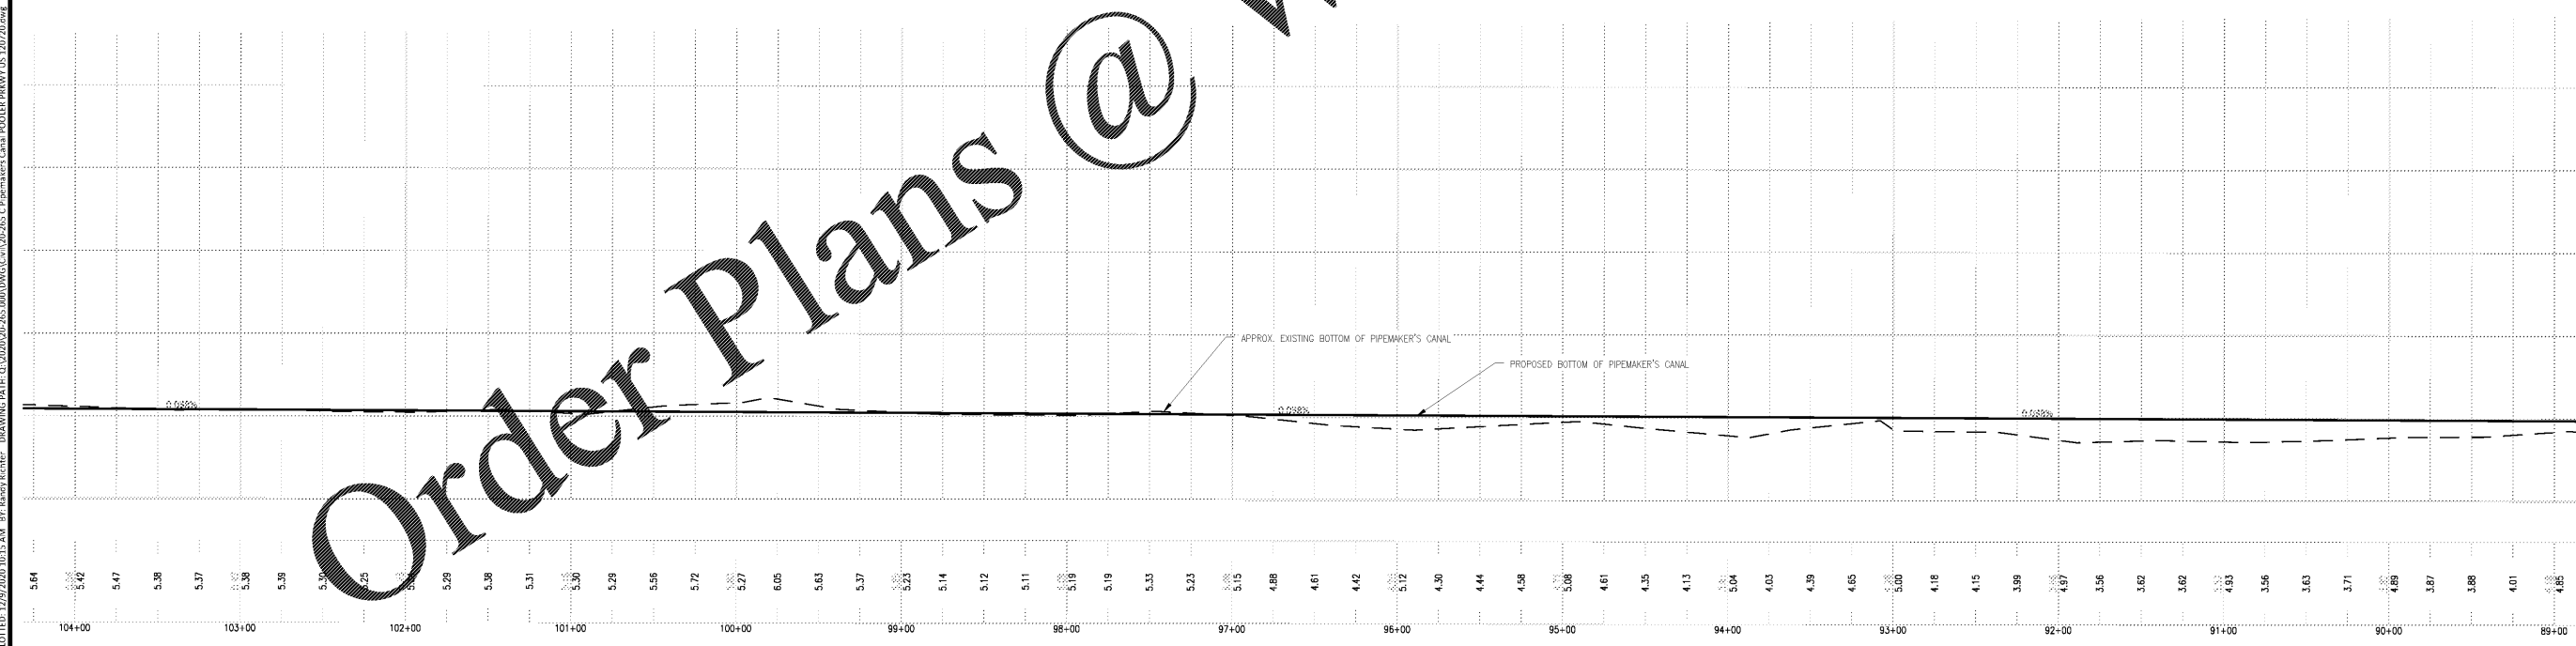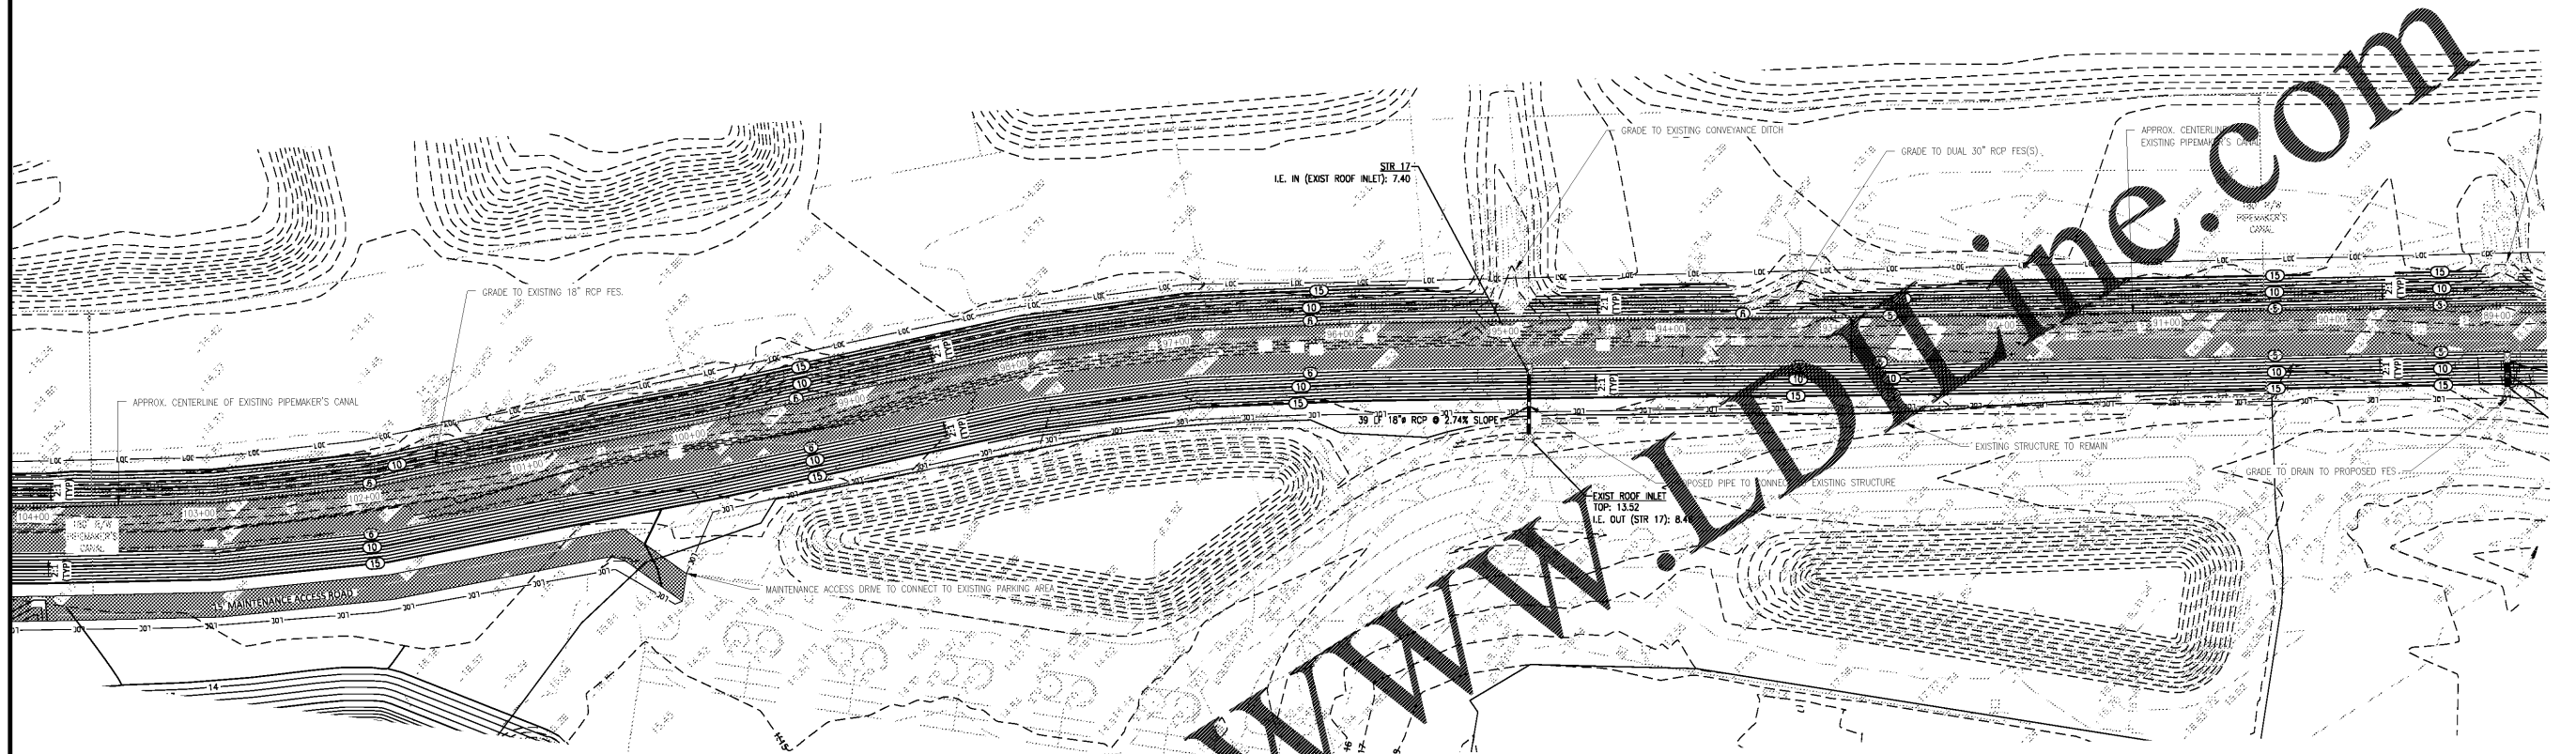

© 2018 COLEMAN COMPANY, INC. DATE PLOTTED: 12/29/2020 10:13 AM BY: Randy Richter. DRAWING PATH: G:\2020\20-265\000\DWG\Civil\20-265-C Pipe-maker Canal POOLER PREWY.US 12/29/20.dwg