



© 2018 COLEMAN COMPANY, INC. DATE PLOTTED: 12/07/2020 10:18 AM BY: Brady Richter DRAWING PATH: G:\2020\20-265\000\DWG\Civil\20-265-C PipeMaker Canal Pooler Preview US 120720.dwg

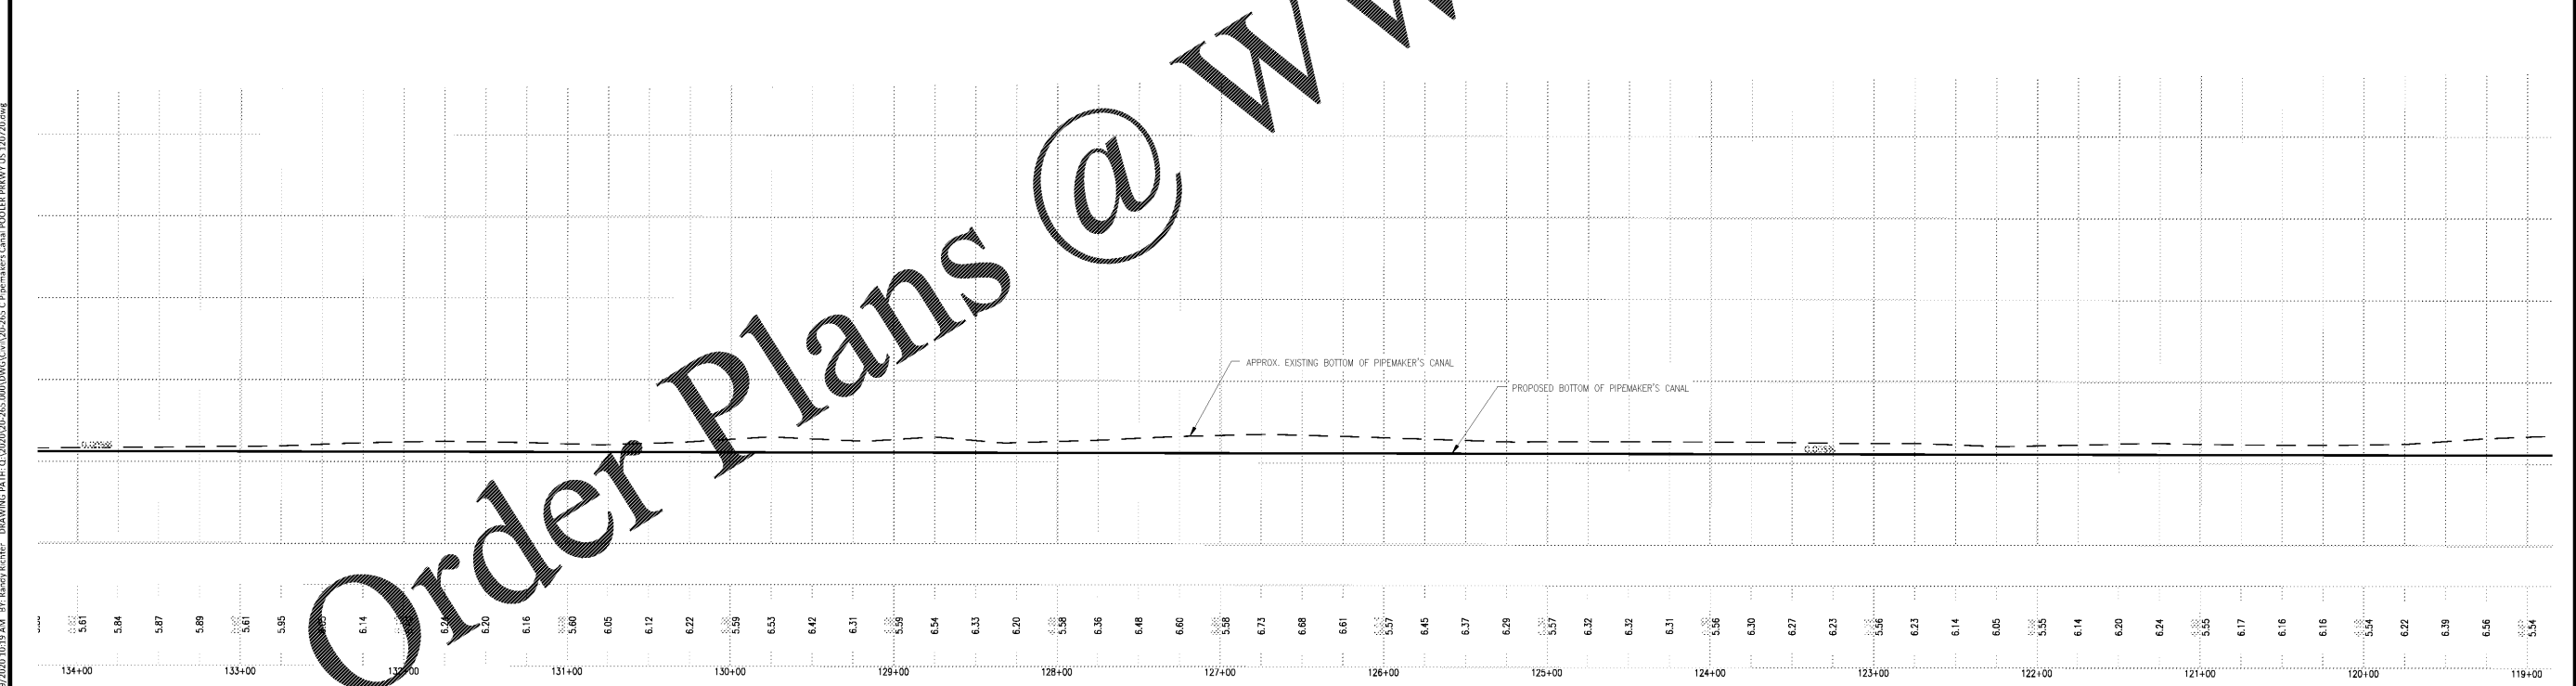

Order Plans @ www.LDilling.com

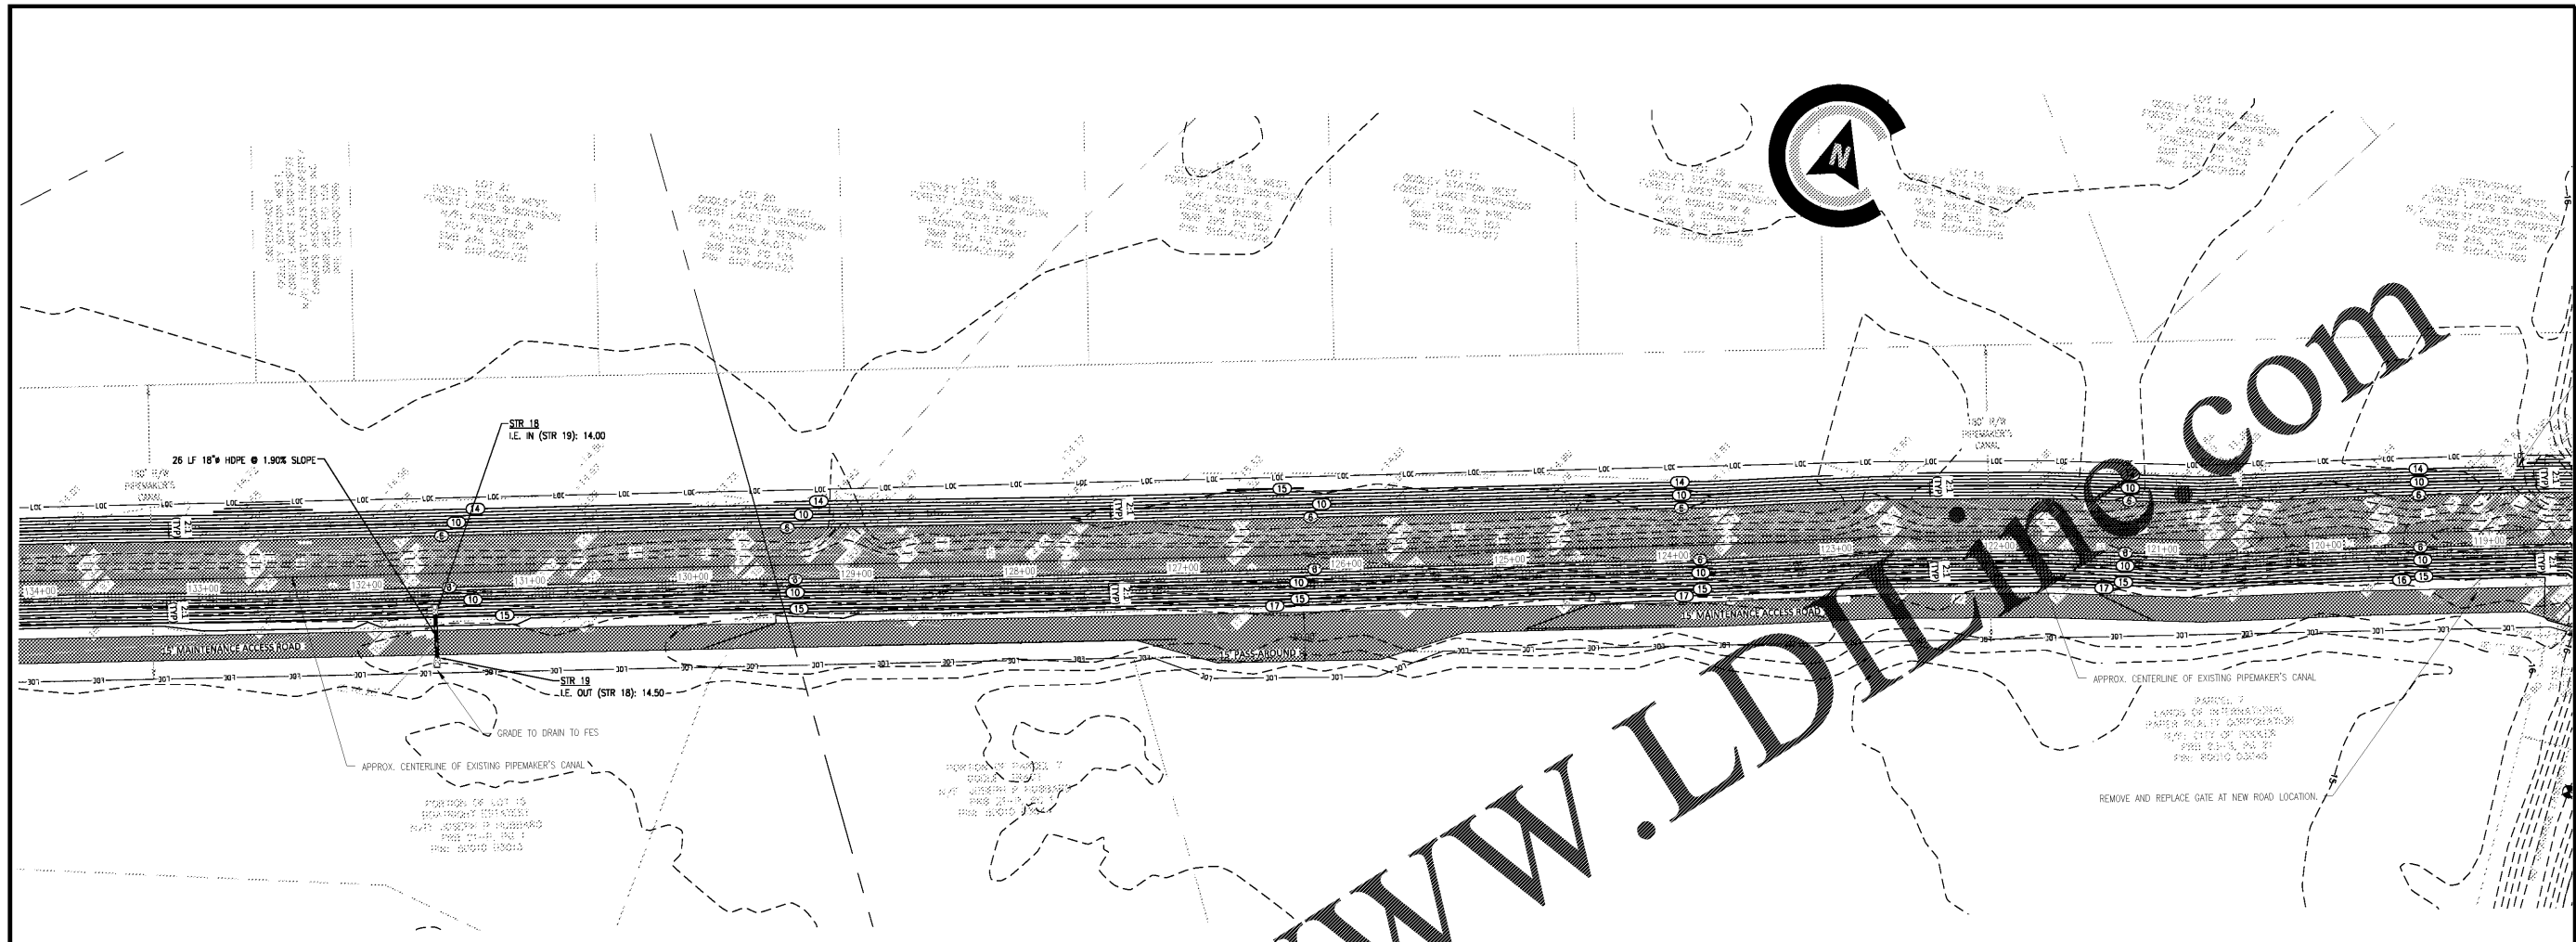

COLEMAN COMPANY
ENGINEERS • SURVEYORS
Savannah, Georgia (912) 260-3841 | CCI-SAV.COM

RELEASED FOR CONSTRUCTION

REVISIONS:

**CIVIL CONSTRUCTION PLANS FOR
PIPE MAKER'S CANAL IMPROVEMENTS**
LOCATED IN POOLER, GA
PREPARED FOR CITY OF POOLER

JOB NUMBER: 20-265
DATE: 06/05/20
DRAWN BY: RAR
CHECKED BY: TGB
SCALE: AS NOTED

PLAN AND PROFILE

SHEET:
C1.5

