


TOTAL ESTIMATED LOAD = 398 CFH  
 TOTAL ESTIMATED LENGTH = 70'-0"  
 FLORIDA BUILDING CODE 2017 - FUEL GAS TABLE 402.4.2  
 INLET PRESSURE = LESS THAN 2 PSI  
 PRESSURE DROP = 0.5 IN. W.C.  
 SPECIFIC GRAVITY = 0.7

**GAS PIPING RISER**  
N.T.S.

**2 DRAIN PIPING RISER**  
N.T.S.

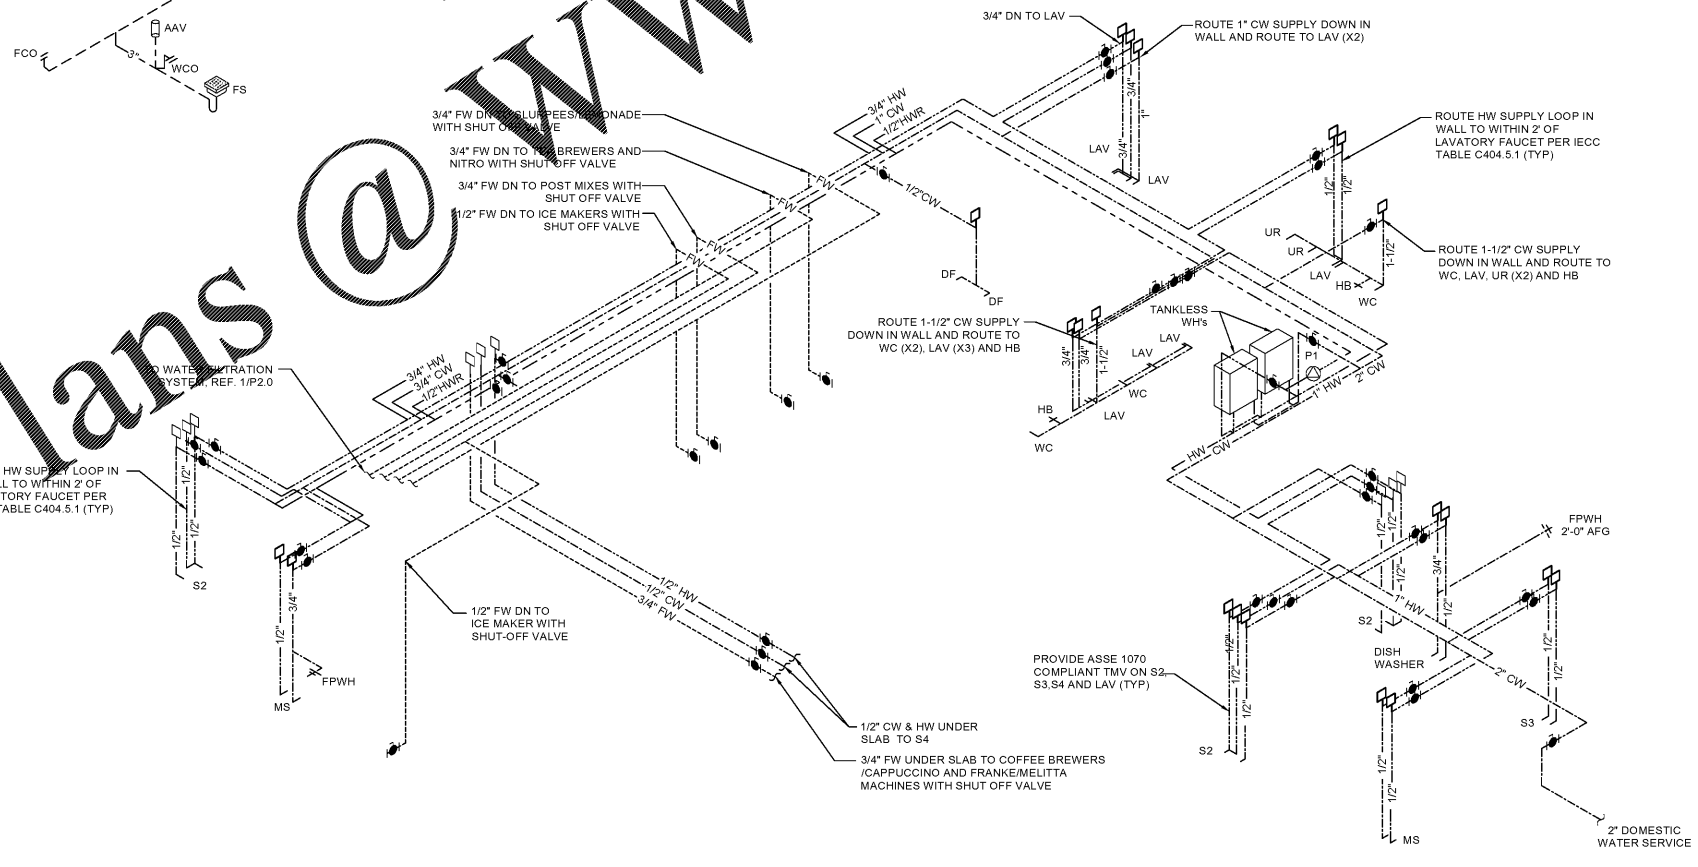

**1 WATER PIPING RISER**  
N.T.S.

Order Plans @ [www.LDILine.com](http://www.LDILine.com)


1925 Prospect Ave.  
 Orlando, FL 32814  
 P (407) 661-9100  
 P (407) 661-9101  
[www.ep.com](http://www.ep.com)  
 Florida Corporate Certificate #AA 0308236



CLIENT NAME  
**BLACKFIN PARTNERS INVESTMENTS, INC.**  
 4400 PCA BLVD, SUITE 600  
 PALM BEACH GARDENS, FL 33410

PROJECT NAME  
**7-ELEVEN #1795 - OCALA, FL**  
 9000 BLOCK OF SE MARICAMP ROAD  
 OCALA, FL 34470

SHEET TITLE  
**PLUMBING RISER DIAGRAMS**

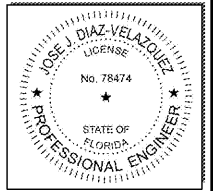

PROJECT NO.	2200355
DATE	12/17/2020
DRAWN	FD
CHECKED	JD

RELEASE	
DATE	
BY	
REASON	