



3 STANDARD 7-ELEVEN IP CCTV TOPOLOGY
N.T.S.

— CAT6
- - - 18/2
***MAXIMUM CAT6 CABLING DISTANCE FOR POE DEVICES CANNOT EXCEED 325 FEET

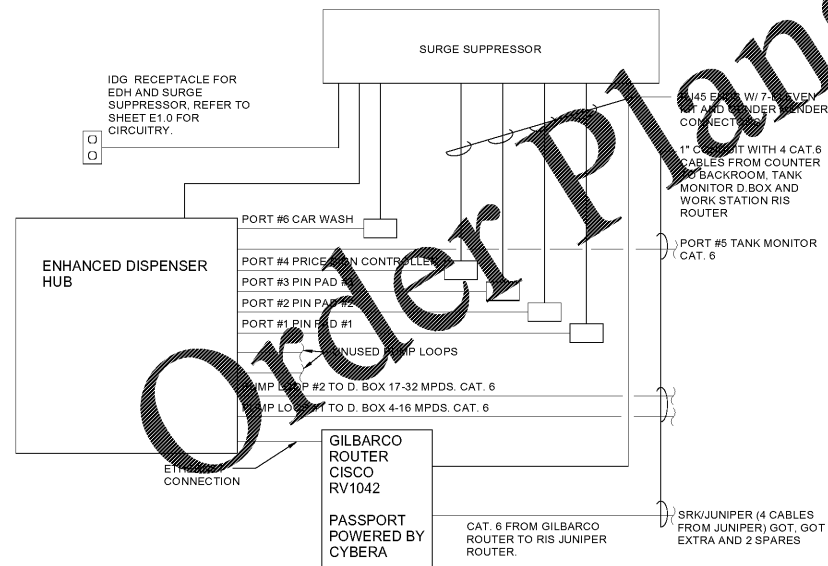


2 ENHANCED DISPENSER HUB (E.D.H.)
N.T.S.

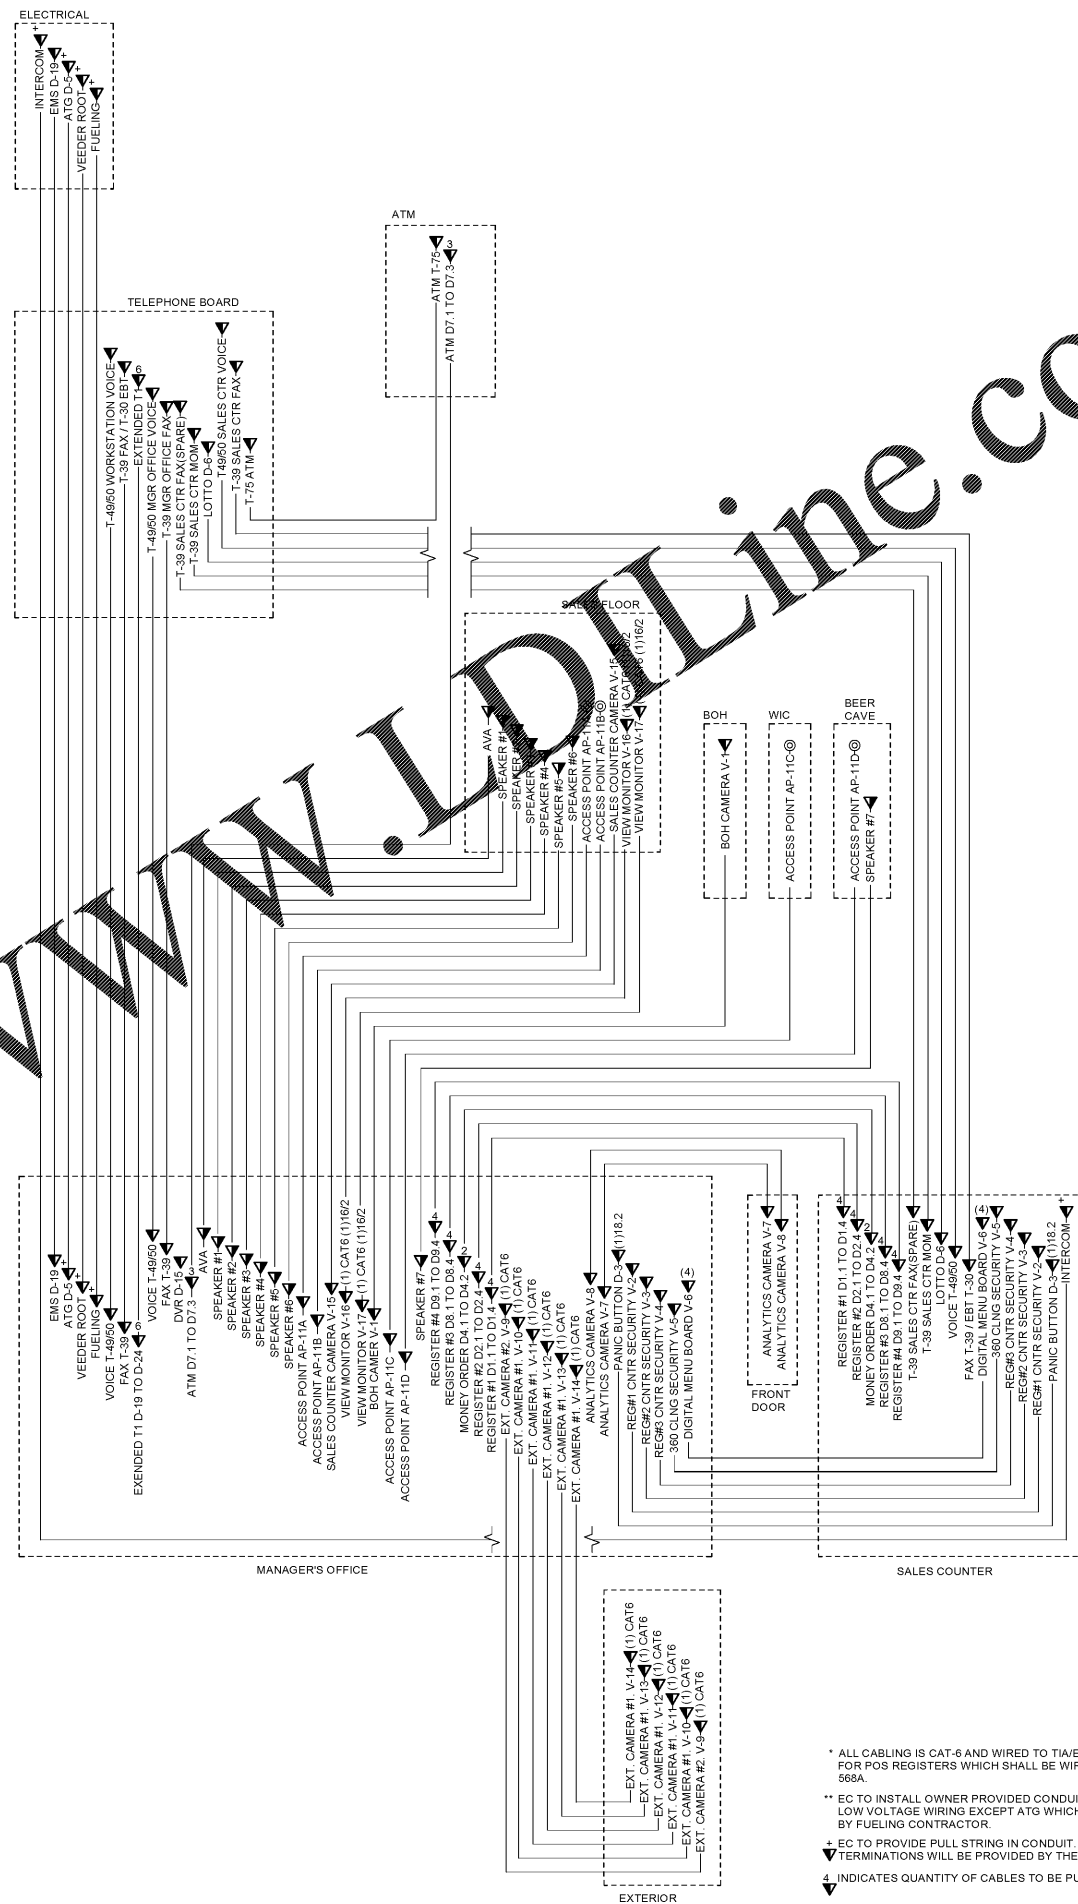

1 LOW VOLTAGE RISER DIAGRAM
1/4" = 1'-0"

- * ALL CABLING IS CAT-6 AND WIRED TO TIA/EIA 568B EXCEPT FOR POS REGISTERS WHICH SHALL BE WIRED TO TIA/EIA 568A.
- ** EC TO INSTALL OWNER PROVIDED CONDUIT AND BOXES FOR ALL LOW VOLTAGE WIRING EXCEPT ATG WHICH IS TO BE PROVIDED BY FUELING CONTRACTOR.
- 4 EC TO PROVIDE PULL STRING IN CONDUIT. WIRING AND TERMINATIONS WILL BE PROVIDED BY THE FUELING CONTRACTOR.
- 4 INDICATES QUANTITY OF CABLES TO BE PULLED.

CLIENT NAME	BLACKFIN PARTNERS INVESTMENTS, INC. 4400 PCA BLVD, SUITE 600 PALM BEACH GARDENS, FL 33410
PROJECT NAME	7-ELEVEN #41795 - OCALA, FL 9000 BLOCK OF SE MARICAMP ROAD OCALA, FL 34470
SHEET TITLE	LOW VOLTAGE DETAILS

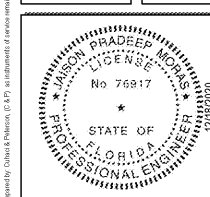

PROJECT NO.	2200385
DATE	12/17/2020
DRAWN	SP
CHECKED	JS

WWW.LDLINE.COM

Order Plans @

NOTE: IN EXISTING STORES, VERIFY THE EXISTENCE OF A CAT6 CABLE WITH RJ45 CONNECTORS ON EACH END OF THE CABLE AS THE CONNECTION FROM THE AUTOMATIC TANK MONITOR (ATG) TO THE IN STORE PROCESS OR (ISP).