



# 7-ELEVEN

**NEW STORE W/ FUELING**  
**STORE NO. 41795**  
**9000 BLOCK OF SE MARICAMP ROAD**  
**Ocala, FL 34470**

 
## SHEET INDEX

FUELING CANOPY AND UNDERGROUND STORAGE TANKS	
Rev. #	Description
G0.0	FUELING CANOPY COVER SHEET AND INDEX
G0.1	FUELING ARCHITECTURAL SITE PLAN
G0.2	FUELING TRUCK ROUTE
G1.0	FUELING PIPING AND TANK PLAN
G3.0	TANK SECTIONS
G4.0	TANK SUMP DETAILS
G4.1	TANK SUMP DETAILS
G5.0	DISPENSER AND SUMP DETAILS
G6.0	REMOTE VENT AND DETAILS
G6.1	FUELING DIMENSIONAL PLAN
G7.0	EQUIPMENT SCHEDULES
G7.1	EQUIPMENT SCHEDULES
G8.0	FUELING CANOPY LAYOUT
G8.1	SIGNAGE DETAILS
G9.0	UST ELECTRICAL PLAN, ONE-LINE DIAGRAM AND PANEL SCHEDULE
G9.1	N.E.C. CLASSIFICATION
G10.0	MISCELLANEOUS ELECTRICAL DETAILS
G11.0	ISOLATION RELAY BOX DETAIL
G12.0	SITE MONITORING EQUIPMENT DIAGRAM
G13.0	FUELING SPECIFICATIONS
G14.0	FUELING SPECIFICATIONS
G15.0	FUELING SPECIFICATIONS
G16.0	FUELING SPECIFICATIONS
G17.0	FUELING SPECIFICATIONS
CS1	CANOPY STRUCTURAL NOTES AND PLANS (20'-0" X 182'-0")
CS2	CANOPY STRUCTURAL SECTIONS AND DETAILS (20'-0" X 182'-0")
AB1	CANOPY FOUNDATION SECTIONS AND DETAILS (20'-0" X 182'-0")




Rev. #	Date	Description
	Proto 12-01-2020	

7-ELEVEN, INC.  
 3200 HACKBERRY ROAD, IRVING TEXAS 75063  
 7-ELEVEN #41795  
 9000 BLOCK OF SE MARICAMP ROAD  
 Ocala, FL 34470  
 FUELING CANOPY COVER SHEET AND INDEX

### VICINITY MAP



### SITE LOCATION MAP

 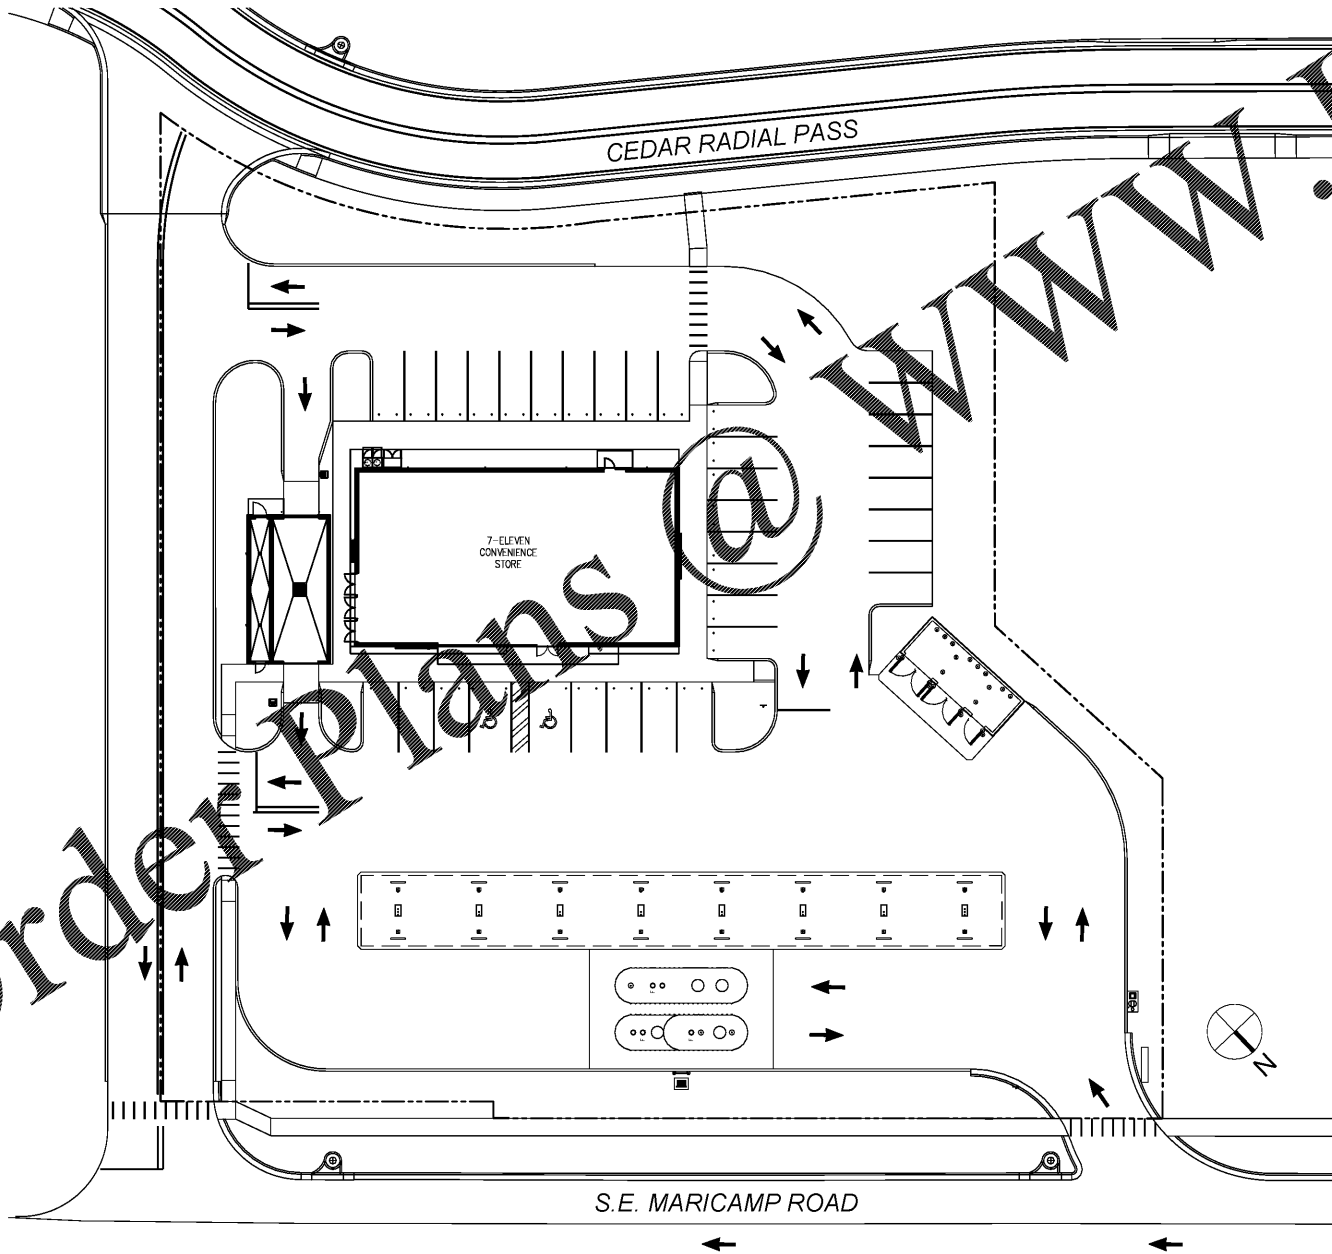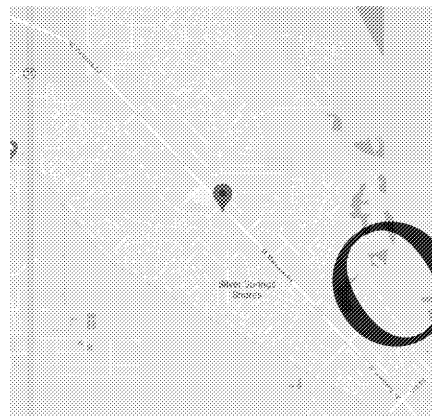

### PROJECT DATA

BUILDING CODE: 2017 FLORIDA BUILDING CODE (6TH EDITION)  
 MECHANICAL CODE: 2017 FLORIDA MECHANICAL CODE (6TH EDITION)  
 PLUMBING CODE: 2017 FLORIDA PLUMBING CODE (6TH EDITION)  
 ELECTRICAL CODE: 2017 NATIONAL ELECTRICAL CODE  
 FIRE CODE: 2017 FLORIDA FIRE CODE (6TH EDITION)  
 FUEL GAS CODE: 2017 FLORIDA FUEL GAS CODE (6TH EDITION)  
 NFPA 30A CODE FOR MOTOR FUEL DISPENSING FACILITIES AND REPAIR GARAGES-2015 EDITION  
 NFPA 1 UNIFORM FIRE CODE HANDBOOK

### SUMMARY OF WORK

- GRADING AND SITEWORK
- ASSOCIATED UNDERGROUND TANKS AND PIPING
- FUELING STATION DESCRIPTION:
  - (6) NEW GILBARCO 3+0 DISPENSERS
  - (2) NEW GILBARCO 3+1 DISPENSERS FOR DIESEL
  - (1) 10' DIA. 20K GAL. DW FIBERGLASS UST FOR UNLEADED FUEL
  - (1) 10' DIA. 20K GAL. SPLIT DW FIBERGLASS UST - 12K DIESEL/8K PREMIUM
  - (2) 2.0 hp VARIABLE SPEED MANIFOLDED STP FOR RUL TANK
  - (1) 2.0 hp VARIABLE SPEED STP FOR PUL TANK
  - (1) 1.5 hp FIXED SPEED STP FOR DIESEL
  - (3) ATG's (1 PER STP SUMP)
  - (3) PRODUCT FILL BUCKETS (1 EACH UST)
  - 1.5" FLEX PIPING IN 4" CHASE PIPING FOR RUL, PUL AND DIESEL FUELS
  - 2" SW FRP VENT PIPING (UST'S TO REMOTE VENT SUMP)
  - (1) NEW BRAVO VENT BOX FOR RUL, PUL AND DIESEL
  - (1) NEW 182'-0" X 20'-0" FUELING CANOPY FOR EIGHT (8) DISPENSERS

### PROJECT DIRECTORY

OWNER: 7-ELEVEN INC.  
 3200 HACKBERRY ROAD  
 IRVING, TX 75063


MEP ENGINEER: CORE STATES GROUP  
 1700 INDUSTRIAL DRIVE, SUITE B  
 ROGERS, AR 72756  
 CONTACT: DAVID LEIFFER  
 479.986.4400  
 EMAIL: DLEIFFER@CORE-STATES.COM

### DEVIATIONS

- NON-PROTO DISPENSER HOOK ISOLATION BOXES FROM FRANKLIN
- FUELING
- NON-PROTO 8 IN-LINE CANOPY LAYOUT
- NON-PROTO TANK LOCATION
- NON-PROTO VENT RISER LOCATION
- NON-PROTO AIR/VAC LOCATION
- NON-PROTO ENTRANCE DUE TO SITE RESTRICTIONS
- NON-PROTO (2) STP SUMPS AT RUL TANK

### REFERENCE SYMBOLS

	- NORTH ARROW		- ROOM TAG
	- HEIGHT ELEVATION INDICATOR		- REVISION DELTA
	- DOOR TAG		- SPOT ELEVATION INDICATOR
	- ENLARGED DETAIL INDICATOR		- KEY NOTE INDICATOR
	- GRID LINE INDICATOR		- FINISH INDICATOR
	- WINDOW TAG		- SECTION CUT INDICATOR
	- WALL TAG		- ELEVATION INDICATOR
			- EQUIPMENT TAG (FOR LIST REF G7.0)

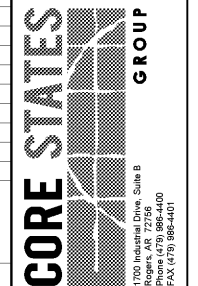

Job#: SEI-31123	Scale: AS NOTED	Date: 01/07/2020	Drawn By: TJS	Checked By: CVK
-----------------	-----------------	------------------	---------------	-----------------

Documents prepared by Core States Group are to be used for the specific project for which they are intended. Any extension of use to other projects, by owner or otherwise, without the express, written consent of Core States Group is prohibited. Core States Group shall not be held responsible for any errors or omissions in the drawings, specifications, or other documents prepared by Core States Group unless specifically intended, user will hold Core States Group harmless from all claims and losses.



SHEET: **G0.0**  
 FUELING - USA