



CAR WASH EXHAUST FAN SCHEDULE								
MARK	MANUFACTURER	MODEL	CFM	E.S.P. (IN. WC)	RPM	MOTOR HP	V/Ph	CONTROL
EF-1	GREENHECK	SE1-14-436-A3	2585	0.125"	1750	1/3	120/1	T-STAT

- NOTES:
- A. PROVIDE INTEGRAL GRAVITY BACKDRAFT DAMPER, MODEL WD-320, AND DAMPER GUARD.
 - B. PROVIDE WALL HOUSING AND GUARD.
 - C. PROVIDE FACTORY MOUNTED DISCONNECT.
 - D. PROVIDE INSECT SCREEN.
 - E. PROVIDE HONEYWELL MODEL T6169B4017AU THERMOSTAT, SET AT 80°F.
 - F. COORDINATE WITH LOUVER LOCATION FOR MOUNTING HEIGHT.
 - G. INSTALL PER MANUFACTURER'S RECOMMENDATIONS.
 - H. TO BE PROVIDED BY 7-ELEVEN AND INSTALLED BY CONTRACTOR. FOR ADDITIONAL INFORMATION CONTACT CHAD LITERSKY (214) 350-6871 EXT. 2140 WITH BARTOS INDUSTRIES.

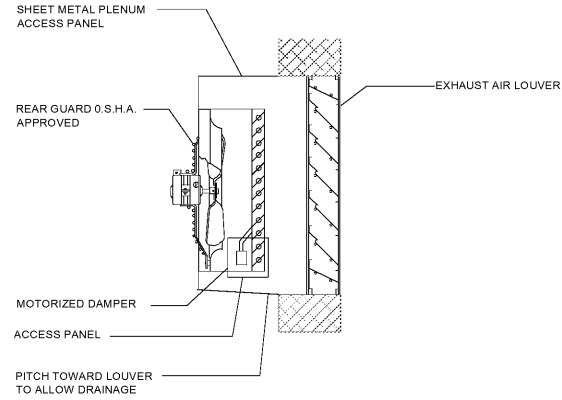

2 FAN DETAIL
Scale: NTS

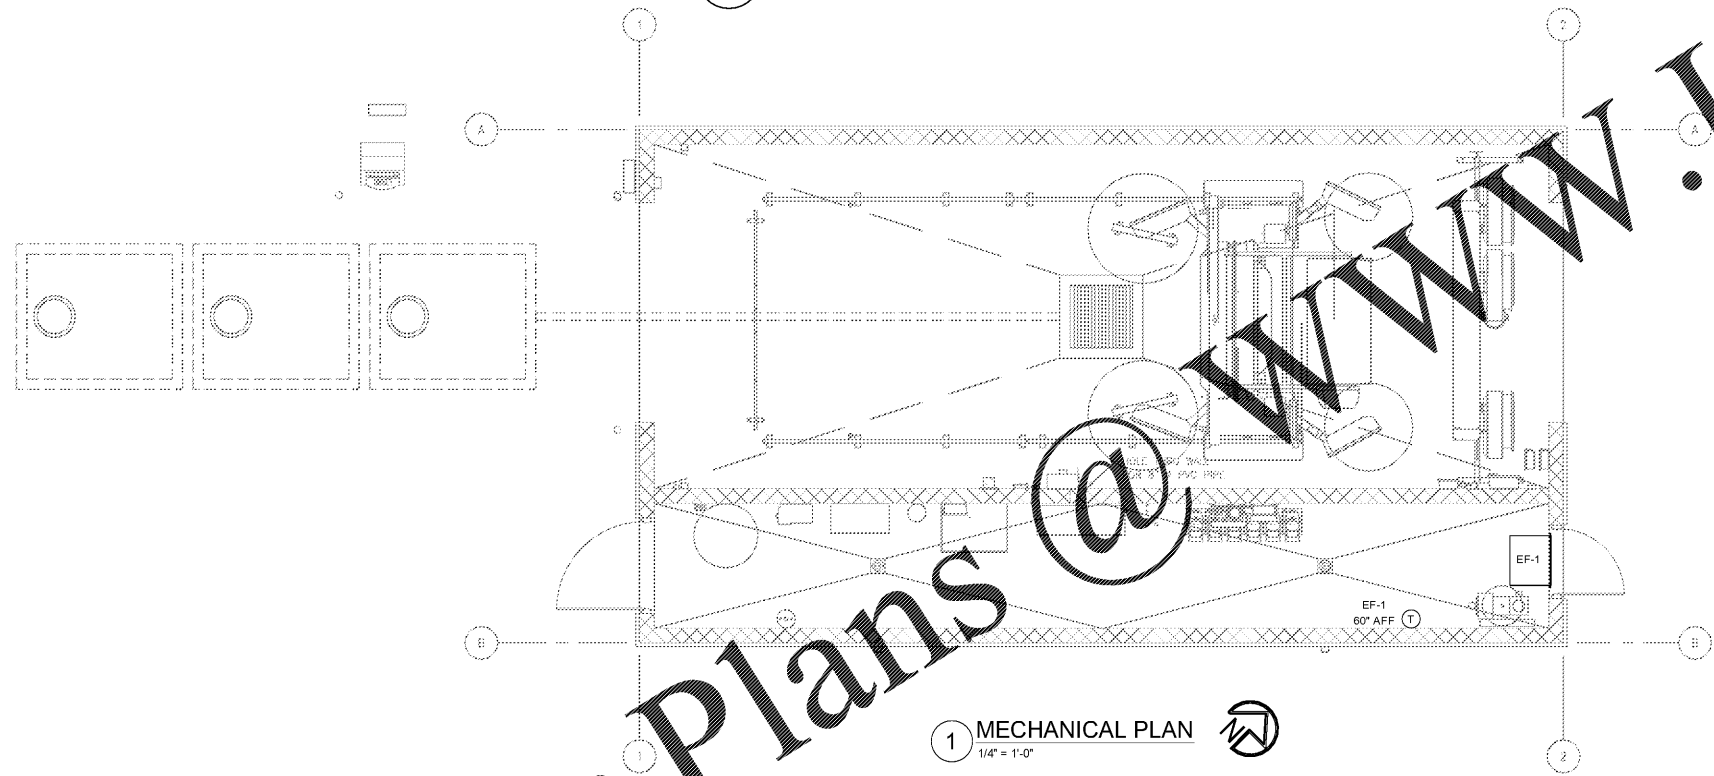

1 MECHANICAL PLAN
1/4" = 1'-0"

Order Plans @ WWW.LDILine.com


1925 Prospect Ave.
Orlando, FL 32814
P (407) 661-9100
P (407) 661-9101
www.ep.com
Florida Corporate Certificate #AA 000626

4
Cuhaci & Peterson
Architects Engineers Planners

CLIENT NAME
BLACKFIN PARTNERS INVESTMENTS, INC.
4400 PCA BLVD, SUITE 600
PALM BEACH GARDENS, FL 33410

PROJECT NAME
7-ELEVEN #41795 - OCALA, FL
9000 BLOCK OF SE MARICAMP ROAD
OCALA, FL 34470

SHEET TITLE
CAR WASH MECHANICAL PLAN

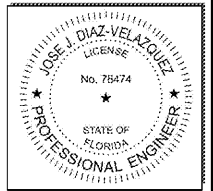

PROJECT NO.	2200355
DATE	12/17/2020
DRAWN	FD
CHECKED	JD

RELEASE	

CWM1.0