


ALL DESIGNS, DRAWINGS AND SPECIFICATIONS DEPICTED ON THIS SHEET ARE THE PROPERTY OF D3 STUDIO, PLLC. ANY UNAUTHORIZED USE OR REPRODUCTION IS SUBJECT TO LEGAL PROSECUTION. POSSESSION IN ANY FORM CONSTITUTES ACCEPTANCE OF THESE CONDITIONS. COPYRIGHT 2021

ABOVE SLAB PLUMBING SCHEDULE										
ITEM	ROUGH-IN HEIGHT	QTY	CW	HW	SANITARY WASTE	GAS SIZE	GAS BTU/H	ITEM	DESCRIPTION	REMARKS
P-9-C	14"	1	1/2"					9	WORKTABLE w/SINK	BTC AT FAUCET
P-9-H	14"	1		1/2"				9	WORKTABLE w/SINK	BTC AT FAUCET
P-9.1-C	14"	1	1/2"					9.1	WORKTABLE w/SINK	BTC AT FAUCET
P-9.1-H	14"	1		1/2"				9.1	WORKTABLE w/SINK	BTC AT FAUCET
P-15-C	12"	3	1/2"					15	HAND SINK	BTC AT FAUCET
P-15-H	12"	3		1/2"				15	HAND SINK	BTC AT FAUCET
P-15-W	24"	3			1-1/2"			15	HAND SINK	BTC AT FAUCET
P-23-C	96"	1						23	ICE MAKER	WALL ROUGH-IN LOCATION. SEE IN-GROUND PLUMBING SHEET FOR STUD OF ROUGH-IN BRANCH THRU FLEX WATER FILTER. MAKE FINAL CONNECTION AT UNIT.
P-53-C	12"	1			3/4"			53	DISHWASHER	
P-74-C	16"	2	1/2"					74	3-COMPARTMENT SINK	BTC AT FAUCET
P-74-H	16"	2		1/2"				74	3-COMPARTMENT SINK	BTC AT FAUCET
P-76-C	36"	1	1/2"					76	COMBI OVEN	

- KEYED NOTES THIS SHEET**
- EXTEND NEW CW PIPING AND CONNECT TO EXISTING CW PIPING IN THIS AREA. VERIFY EXACT LOCATION AND SIZE OF EXISTING PIPING IN FIELD.
 - CONNECT 1/2" CW TO ICE MACHINE WITH BALL VALVE AND WATTS SERIES LF7 DUAL CHECK VALVE. VERIFY EXACT LOCATION AND SIZE OF CONNECTION WITH EQUIPMENT SUPPLIER.
 - CONNECT 1/2" CW TO BEVERAGE DISPENSER WITH BALL VALVE AND WATTS SERIES SD-3 DUAL CHECK VALVE. VERIFY EXACT LOCATION AND SIZE OF CONNECTION WITH EQUIPMENT SUPPLIER.
 - PROVIDE TMV ABOVE SINK SEE 10" F.
 - CONNECT 1/2" CW TO STEAMER WITH BALL VALVE AND WATTS SERIES LF7 DUAL CHECK VALVE. VERIFY EXACT LOCATION AND SIZE OF CONNECTION WITH EQUIPMENT SUPPLIER.
 - EXTEND 1/2" CW TO DISHWASHER FROM HW SUPPLY. PROVIDE BALL VALVE AND PROVIDE WATTS SERIES LF7 DUAL CHECK VALVE. UNLESS DISHWASHER HAS INTEGRAL BACKFLOW PREVENTER.

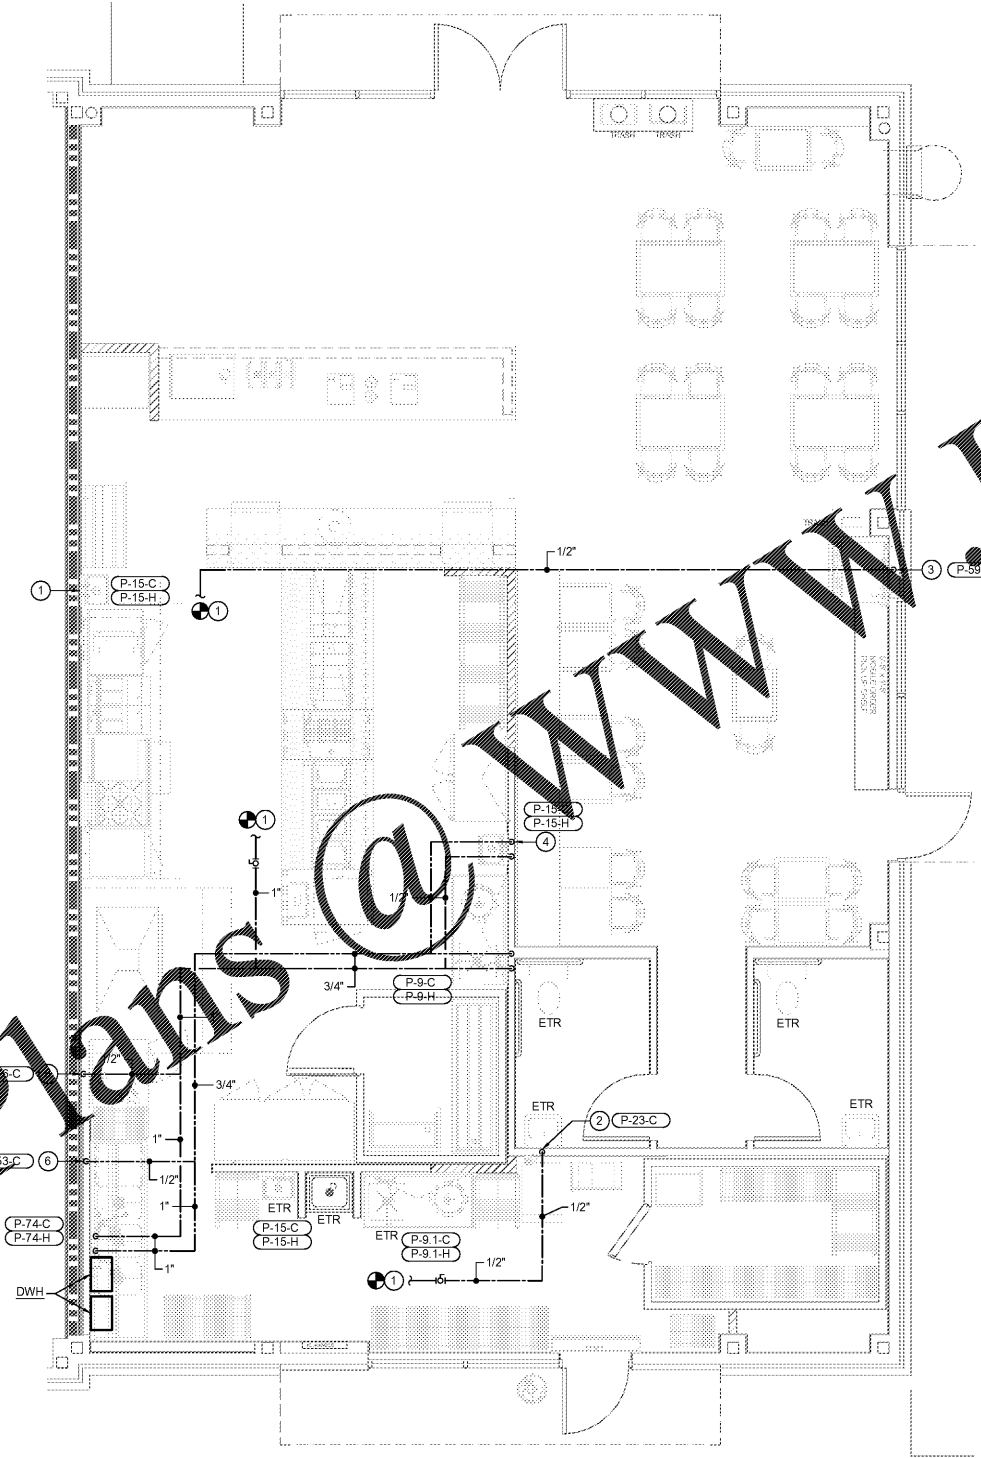


Order Plans @ www.LDILine.com

2 WATER PLAN
P1.02 SCALE: 1/4" = 1'-0"

- GENERAL NOTES THIS SHEET**
- SEE FIXTURE SCHEDULE ON SHEET P0.01 FOR SIZES OF DOMESTIC WATER CONNECTIONS TO INDIVIDUAL FIXTURES.
 - THE PLUMBING CONTRACTOR SHALL FIELD VERIFY EXISTING CONDITIONS INCLUDING DIRECTION OF FLOW, INVERTS, AND TIE-IN LOCATIONS PRIOR TO ROUTING ANY PIPING. SAWCUT EXISTING SLAB, WALL OR CEILING CONSTRUCTION AS REQUIRED. AREAS TO BE SAWCUT SHALL BE APPROVED BY ARCHITECT PRIOR TO CUTTING. ALL SAWCUT AND ALTERED SURFACES SHALL BE FILLED, PATCHED, PAINTED, AND REPAIRED TO MATCH ADJACENT SURFACES.

d3 studio
PLANNING • ARCHITECTURE • INTERIORS
1318 CENTRAL AVENUE :: SUITE A-10
CHARLOTTE, NC 28205
WEBSITE :: www.d3studio.com

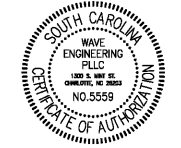

FOR CONSTRUCTION

Viva Chicken
PERUVIAN ROTISSERIE JOINT
1139 WOODRUFF RD.
-SUITE B
GREENVILLE, SC
29607

REVISION		
no.	date	comment

DRAWN BY SBC
CHECKED BY BRD
SUBMITTAL DATE 02.08.2021
PROJECT NUMBER 02-2011

PLUMBING WATER PLAN

P1.02