



ALL DESIGNS, DRAWINGS AND SPECIFICATIONS DEPICTED ON THIS SHEET ARE THE PROPERTY OF D3 STUDIO, PLLC. ANY UNAUTHORIZED USE OR REPRODUCTION IS SUBJECT TO LEGAL PROSECUTION. POSSESSION IN ANY FORM CONSTITUTES ACCEPTANCE OF THESE CONDITIONS. COPYRIGHT 2021

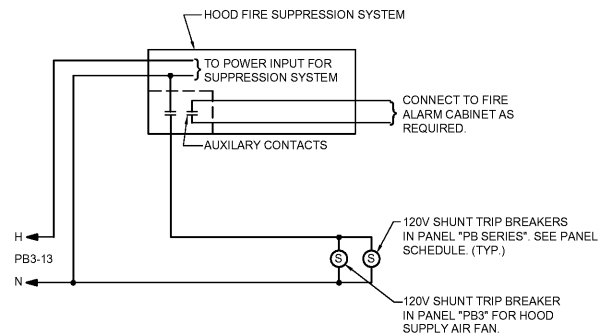

2 HOOD CONTROL AND WIRING DETAIL
E-2.1 NO SCALE

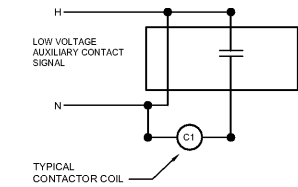

CONTACTOR	COL VOLTAGE	POLES	CIRCUITS SWITCHED
C1	120	6	PB-24; PB2-11,19,41


3 HOOD EQUIPMENT SHUNT DETAIL
E-2.1 NO SCALE

GENERAL NOTES THIS SHEET

- WORKING SPACE CLEARANCES TO BE MAINTAINED AT ELECTRICAL PANELS/EQUIPMENT PER NEC 110.26 SEE FLOOR PLAN THIS SHEET AND DETAIL 2/E-3.01.

KEYED NOTES THIS SHEET

- THE CONTRACTOR SHALL COORDINATE EXACT REQUIREMENTS FOR COOLER EVAPORATOR AND CONDENSER WITH MANUFACTURE PRIOR TO ROUGH-IN.
- EXISTING SHOW WINDOW CIRCUITS TO REMAIN. EXISTING GENERAL USE POWER AND RECEPTACLES ALSO TO REMAIN. CONTRACTOR TO FIELD VERIFY QUANTITY AND REPLACE WITH COLOR AS DESIRED BY ARCHITECT/OWNER/INTERIOR DESIGNER.
- COORDINATE LOCATION OF ELECTRIC HEATERS WITH PLUMBER/CONTRACTOR PRIOR TO ROUGH-IN WORK.
- COORDINATE ELECTRICAL CONNECTIONS TO AIR CURTAINS PER MANUFACTURER'S INSTALLATION INSTRUCTIONS PRIOR TO ROUGH-IN.
- BRING FROM OUTLET TO FACE OF FURNITURE. PROVIDE WIRING AS REQUIRED FOR THE SOLID STATE COOLING UNIT FOR EACH HEATER. ELECTRICAL HEATER TO BE SUPPLIED BY ELECTRICAL CONTRACTOR. COORDINATE LOCATION OF CONTROL DEVICES WITH ARCHITECT. CONTROL UNIT IS BY MECHANICAL CONTRACTOR.
- PROVIDE FURRING FOR 6" PANEL AS REQUIRED FOR INSTALLATION.
- CONDUIT FROM EACH POS LOCATION RAN UNDERSLAB TO ABOVE ACCESSIBLE CEILING AT THE OWNER SUPPLIED TELCOM CABINET.
- EXISTING ROOM TO REMAIN. SEE NOTE 2.
- EXISTING RTU UNITS TO REMAIN. EXISTING SMOKE DUCT DETECTORS TO REMAIN.
- EXISTING WATER HEATERS TO REMAIN.

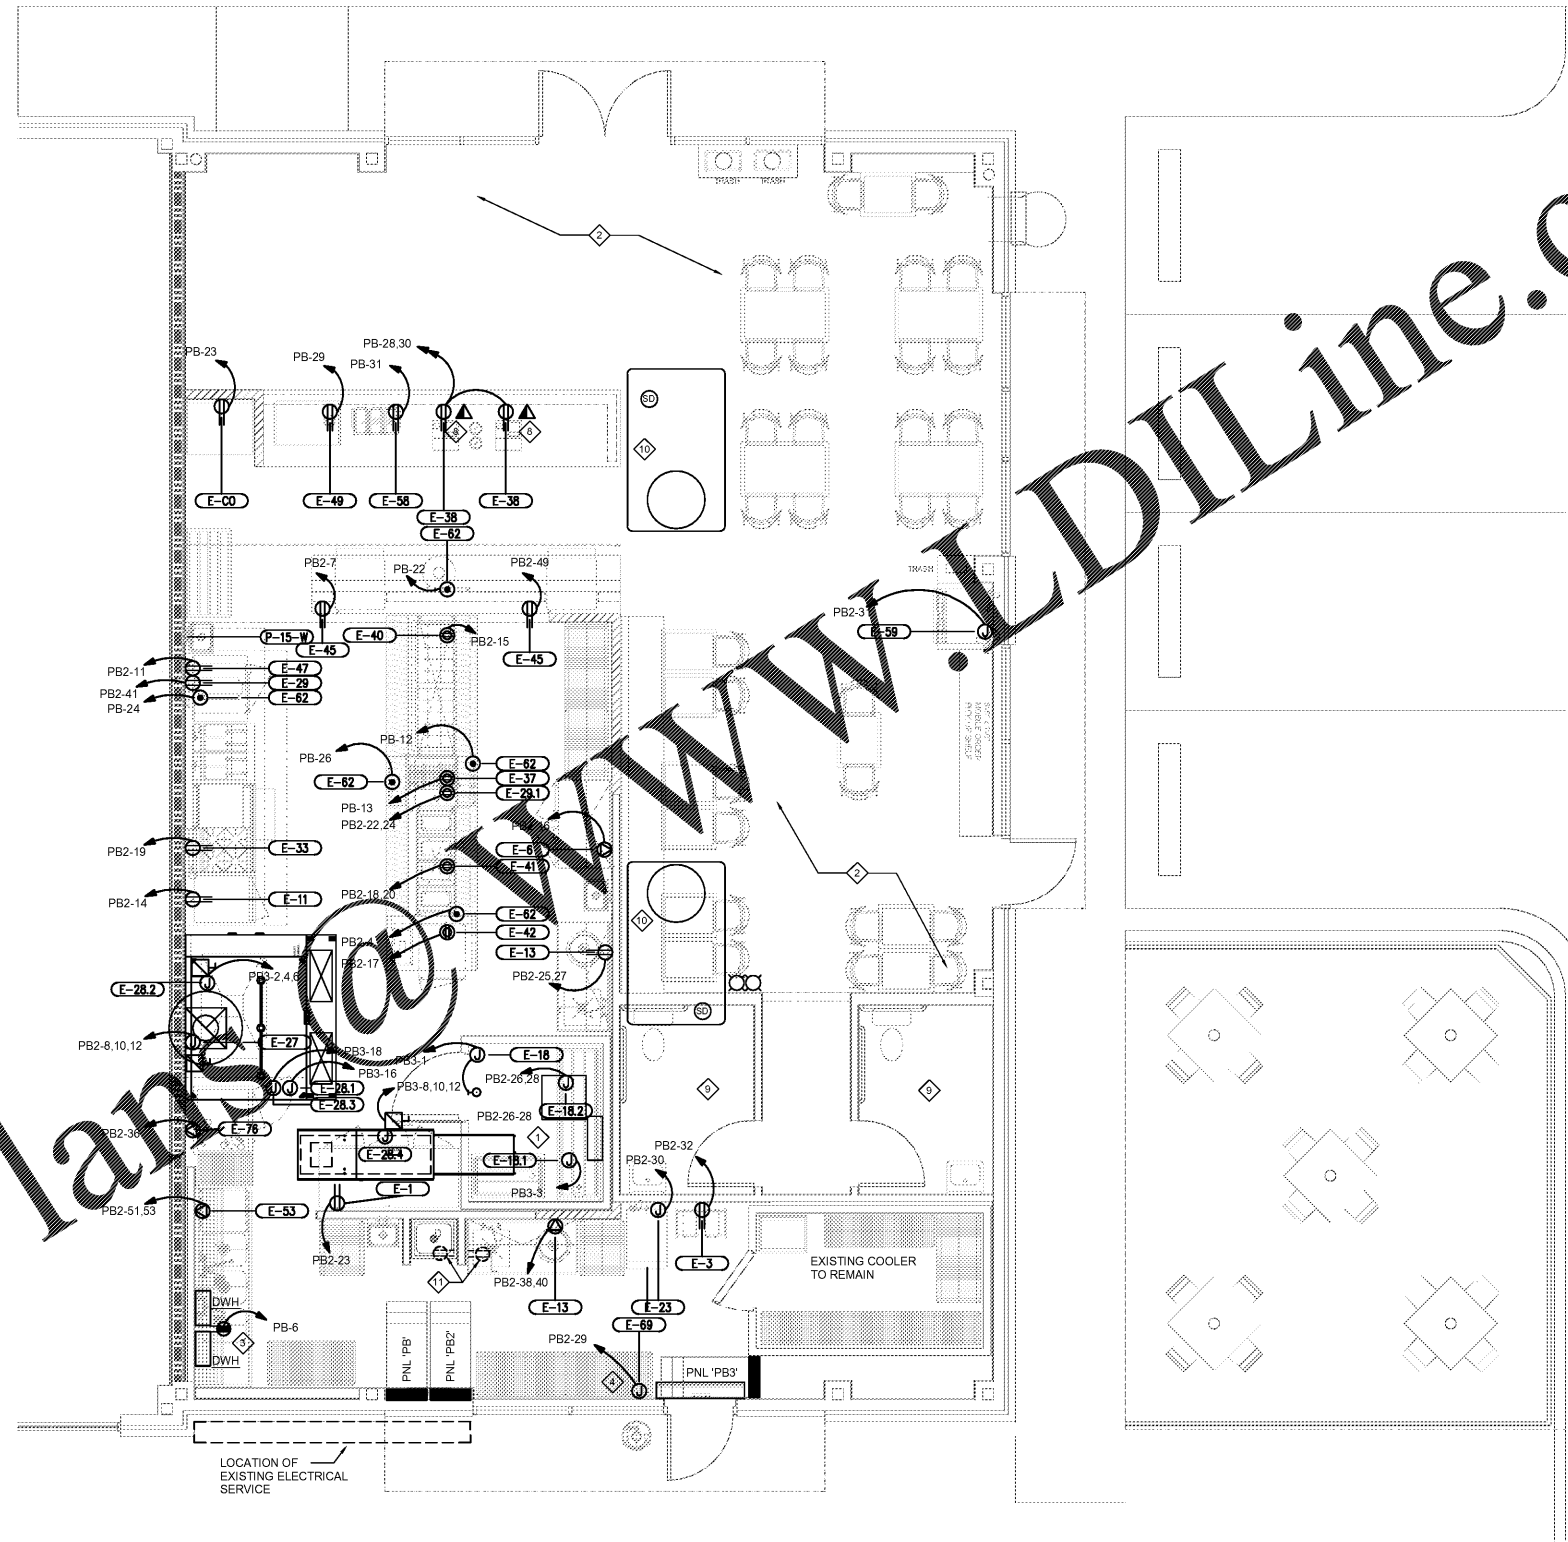


1 POWER PLAN
E2.01 SCALE: 1/4" = 1'-0"

Copyright Plans@www.LDILine.com



WAVE ENGINEERING
3540 TOWNSEND WAY, SUITE 800
CHARLOTTE, NC 28277
919.262.7128
INFORM@WAVEENGINEERING.COM
WAVE PROJECT #00178

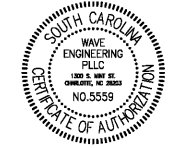

FOR CONSTRUCTION

Viva Chicken.
PERUVIAN ROTISSERIE JOINT
1139 WOODRUFF RD.
-SUITE B
GREENVILLE, SC
29607

REVISION		
no.	date	comment

DRAWN BY: GKG
CHECKED BY: BRD
SUBMITTAL DATE: 02.08.2021
PROJECT NUMBER: 02-2031

POWER PLAN

E2.01