


- NOTE:**
- COORDINATE WITH STRUCTURAL, PLUMBING, MECHANICAL AND ELECTRICAL FOR ALL ITEMS PROVIDED BY THOSE DISCIPLINES. CONTRACTOR SHALL BE RESPONSIBLE FOR LAYING OUT ALL CEILING MOUNTED ELEMENTS WITH ALL OTHER CEILING MOUNTED EQUIPMENT AND STRUCTURE AND CORRECTING ANY INTERFERENCE PRIOR TO INSTALLATION.
  - PREPARE AND PAINT ALL CEILING MOUNTED ITEMS ON SALES FLOOR, INCLUDING BUT NOT LIMITED TO HVAC DIFFUSERS AND RETURNS, THREADED ROD, CONDUIT AND SPRINKLER PIPING. DO NOT PAINT EVAC CONDENSATE REMOVAL SYSTEM PINCH VALVES, OR ANY WIRELESS ACCESS POINT APPLIANCES PROVIDED BY ALDI.
  - ALL DIMENSIONS ARE TO FACE OF WALL FINISH UNLESS OTHERWISE NOTED.
  - ALL DIMENSIONS TO LIGHT LOCATIONS ARE TO CENTERLINE OF FIXTURE.
  - CAULK ALL SUSPENDED CEILING TO WALL INTERSECTIONS - SEE SPEC SECTION 079200.
  - ALL INTERIOR WALLS EXCEPT SHADED PORTIONS EXTEND TO UNDERSIDE OF DECK.
  - ATTACH POWERPOLE TO ROOF STRUCTURE WITH UNISTRUT (TYP. AT CHECKLANES AND SPOT MERCHANDISERS) - PAINT UNISTRUT TO MATCH CEILING.
  - GC TO ENSURE ALL JOIST AND JOIST GIRDER TAGS ARE PROPERLY SECURED TO JOIST WEBBING AND CONCEALED FROM VIEW PRIOR TO PAINTING.
  - NORDEON LIGHTING SYSTEM SHALL BE OWNER FURNISHED AND CONTRACTOR INSTALLED. CONTRACTOR SHALL HAVE FIVE (5) DAYS FROM DATE OF DELIVERY ACCEPTANCE TO VERIFY SHIPMENT FOR ANY DAMAGES. CORRECT QUANTITY OF FIXTURES AND PLACE A CLAIM. AFTER FIVE (5) DAYS THE CONTRACTOR SHALL BE RESPONSIBLE FOR ANY DAMAGES AND ADDITIONAL FIXTURES REQUIRED.
  - EXTEND EXISTING PARTITIONS AND GYP. TO DECK. ALL NEW PARTITIONS ARE TO EXTEND TO DECK UNLESS NOTED OTHERWISE.

LEGEND:	
EXIT SIGN	
EMERGENCY LIGHT	
2' X 4' RECESSED LIGHT FIXTURE	
1' X 4' RECESSED LIGHT FIXTURE	
4' STRIP LIGHT FIXTURE	
8' STRIP LIGHT FIXTURE	
RECESSED CAN	
WALL PACK OR SCONCE	
CANOPY / SOFFIT SQUARE	
EXTERIOR ACCENT CYLINDER	
RETURN AIR GRILLE	
SUPPLY DIFFUSER	
LINEAR DIFFUSER	
DESTRATIFICATION FAN	
DUCTLESS SPLIT FAN COIL UNIT	
ELEC. CABINET HEATER	
SHADED FIXTURES ARE NIGHT LIGHTS - SEE LIGHTING PLAN	

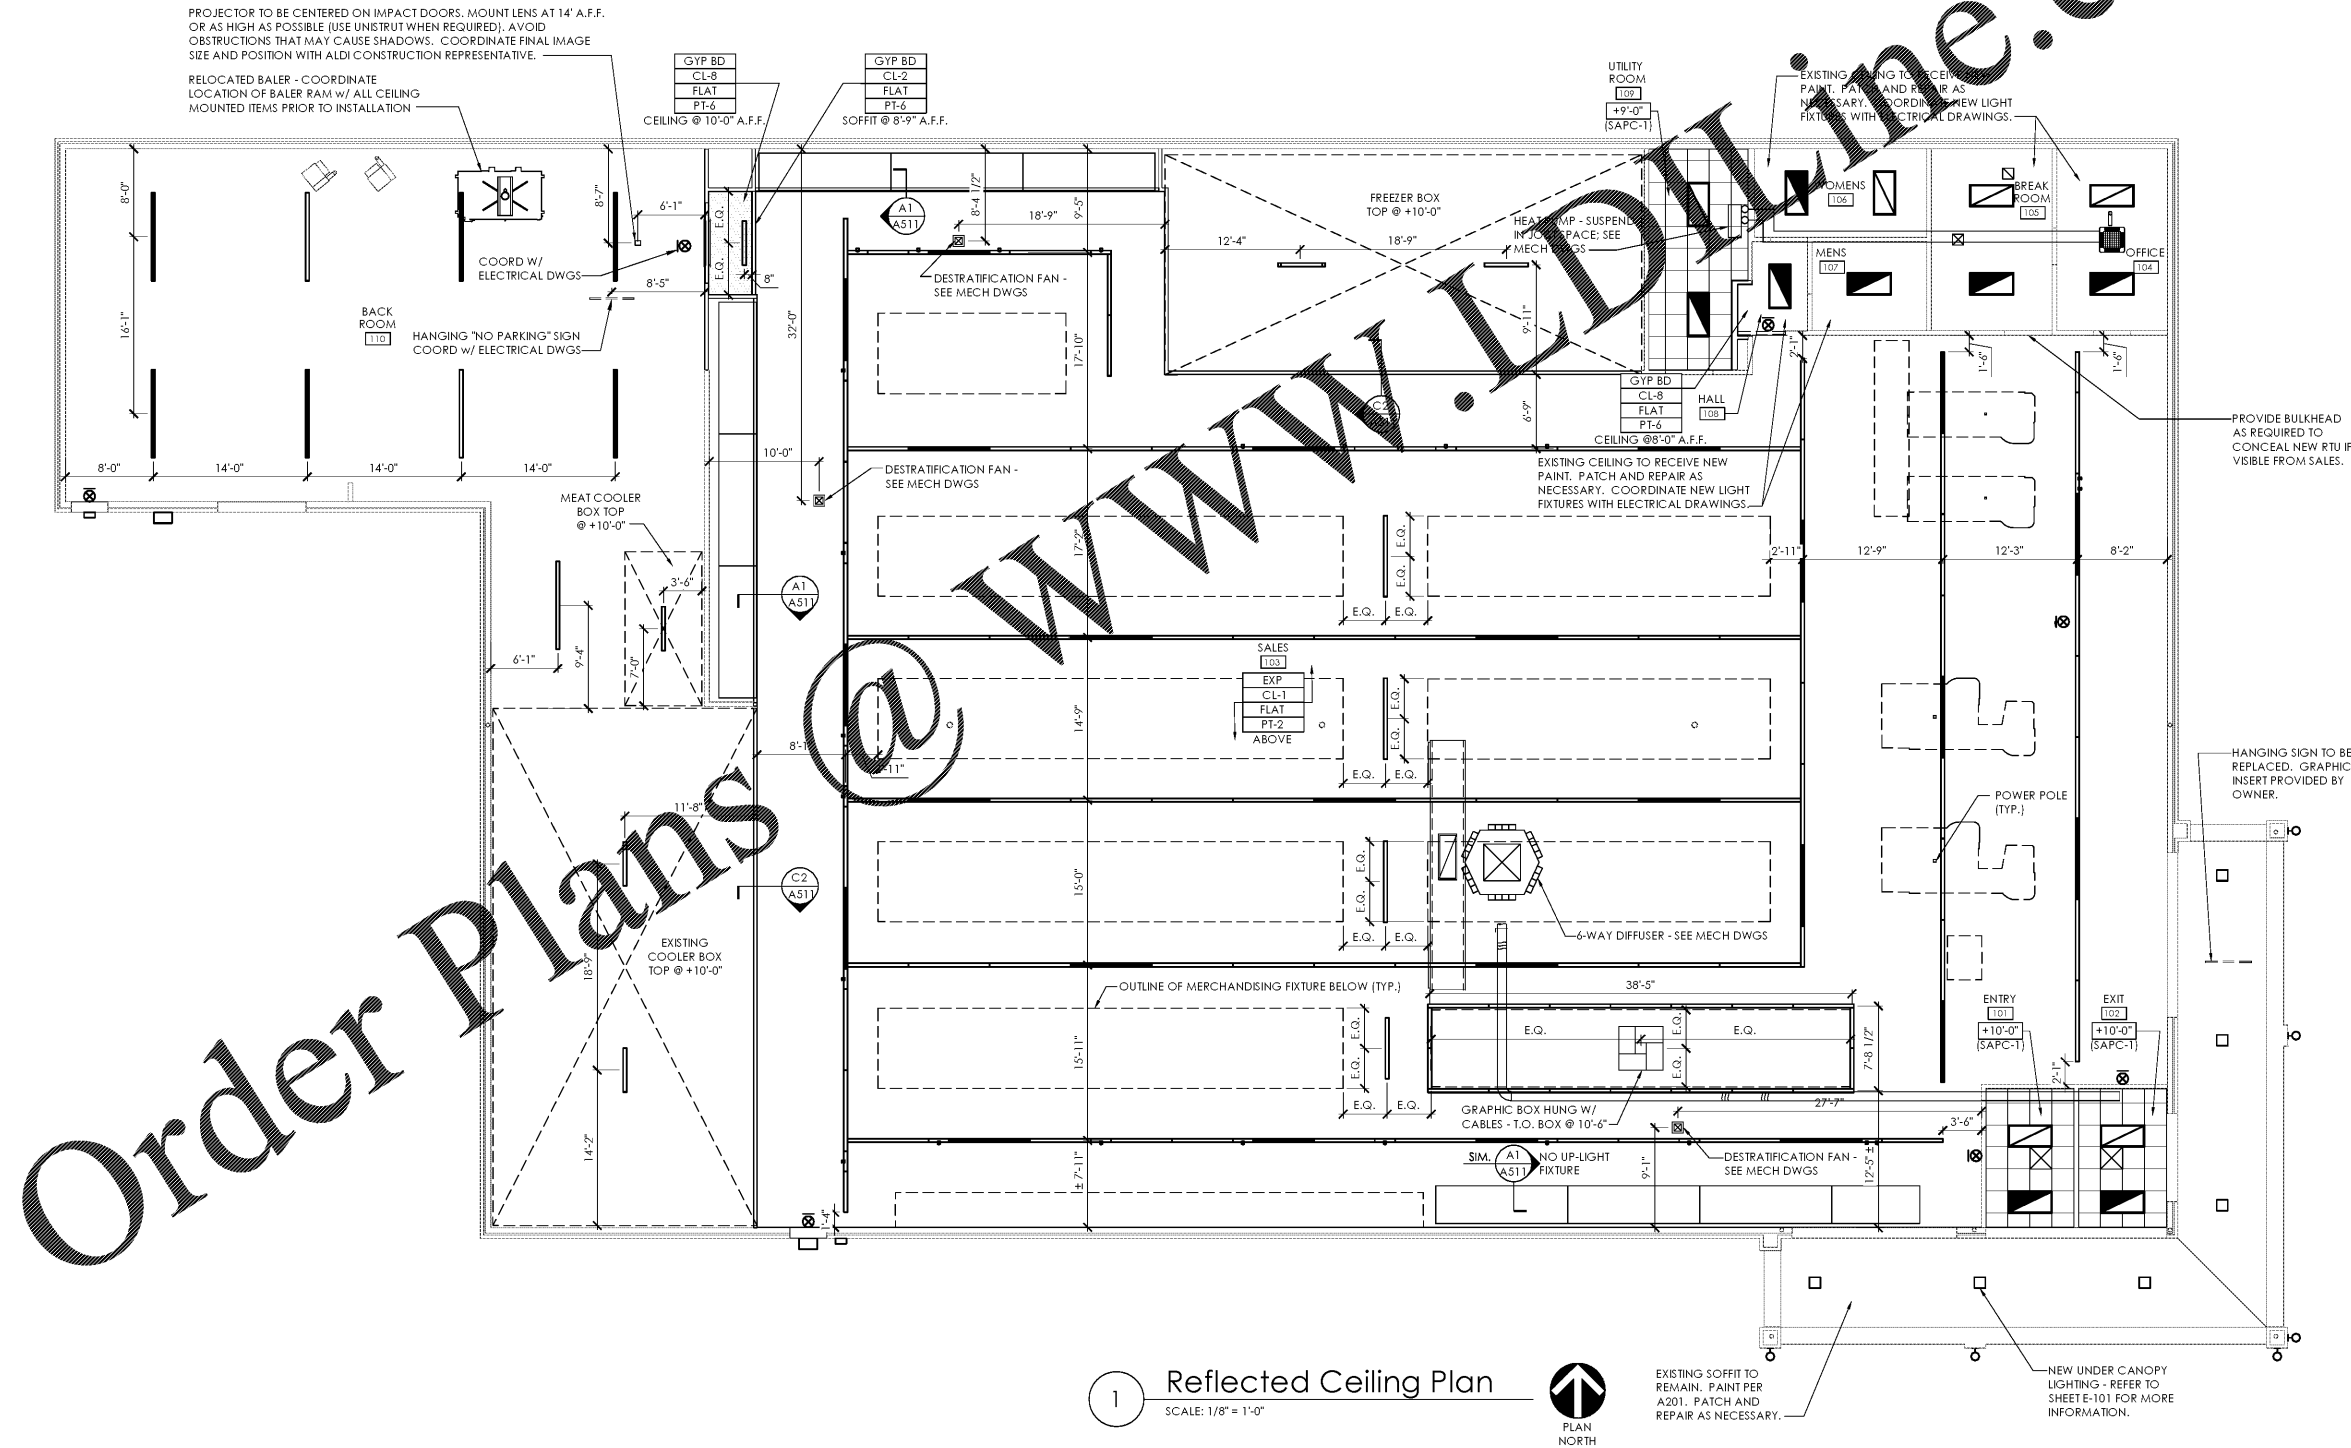

1 Reflected Ceiling Plan  
SCALE: 1/8" = 1'-0"



EXISTING SOFFIT TO REMAIN. PAINT PER A201. PATCH AND REPAIR AS NECESSARY.

NEW UNDER CANOPY LIGHTING - REFER TO SHEET E-101 FOR MORE INFORMATION.

Issued:	Date:
A Client Review Set	01/21/21
B Permit Set	02/03/21
C Bid Set	02/12/21
D	

Revisions:	Date:
1	
2	
3	
4	
5	
6	
7	
8	
9	

**DO NOT SCALE PLANS**

Copying, Printing, Software and other processes required to produce these prints on stretch or shrink the actual paper or layout. Therefore, scaling of this drawing may be inaccurate. Contact us consultants with any need for additional dimensions or clarifications.

**ms consultants, inc.**  
engineers, architects, planners  
5444 Wade Park Blvd.  
Suite 160  
Raleigh, NC 27607-4299  
phone 919.772.5565  
fax 919.779.2308

DRAWN BY: SCG/MEM  
REVIEWED BY: NAL/CMB

Seal

PROFESSIONAL OF RECORD:  
CHARLES M. BUSCH No. 14751  
EXP. DATE: 06/30/2021

**ALDI Inc.**  
1985 Old Union Church Road  
Salisbury, NC 28146  
(704) 642-0023  
(704) 642-0078 fax

ALDI Inc.  
Store No. 87  
2526 Freedom Dr  
Charlotte, NC 28208  
Mecklenburg County  
Project Name & Location:

Reflected Ceiling Plan Drawing Name:	Project No. 40452-30
Prototype Rls. 06/03/20	
Type 100x154 FMR	
Scale: As Noted	Drawing No. A-111