
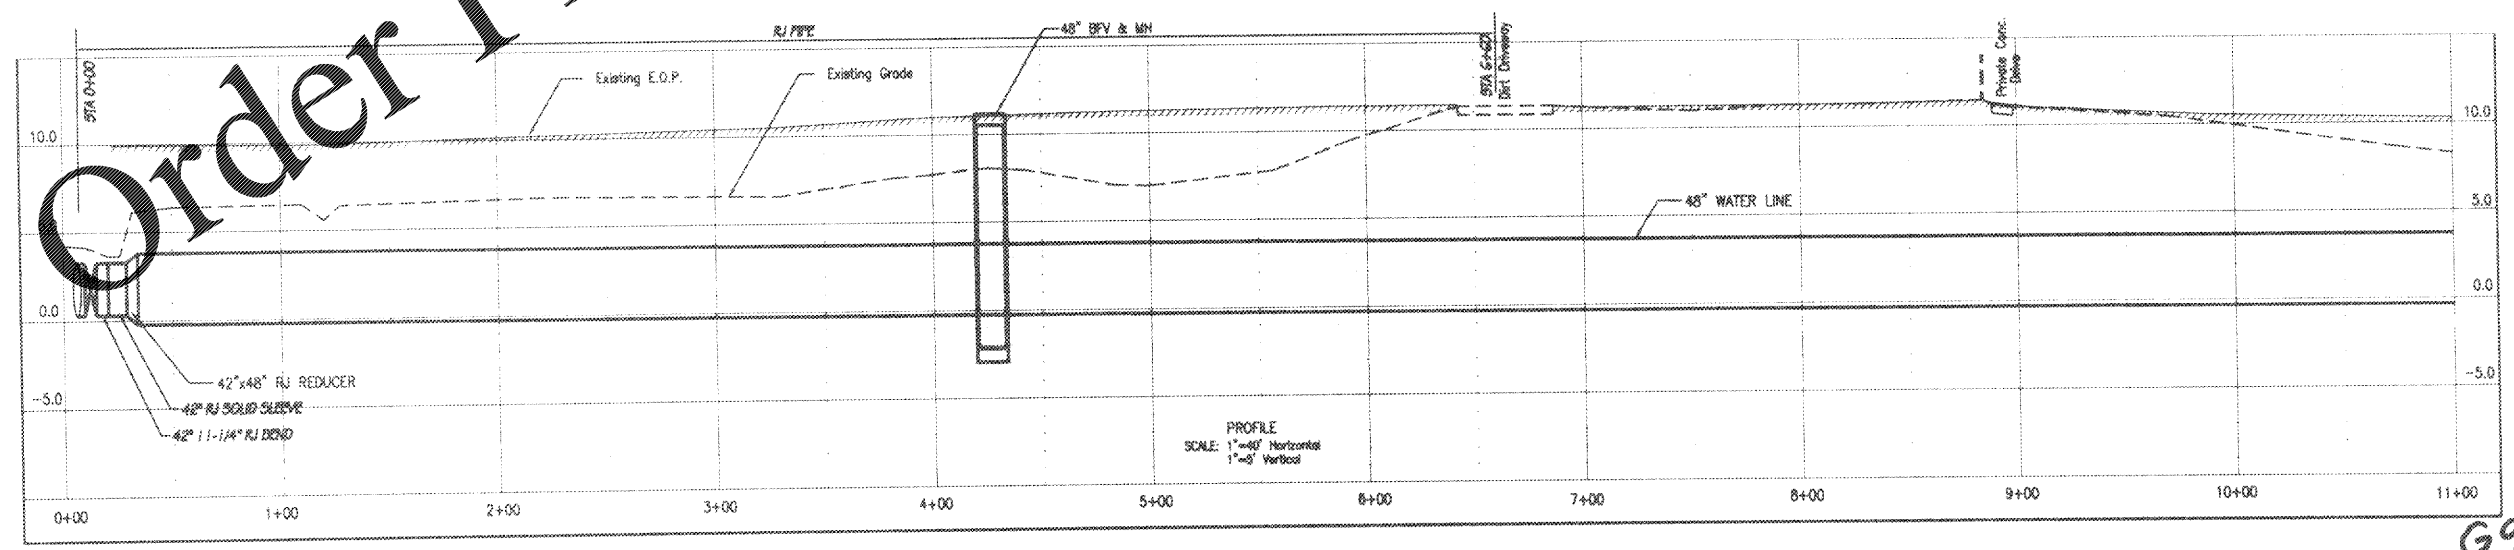
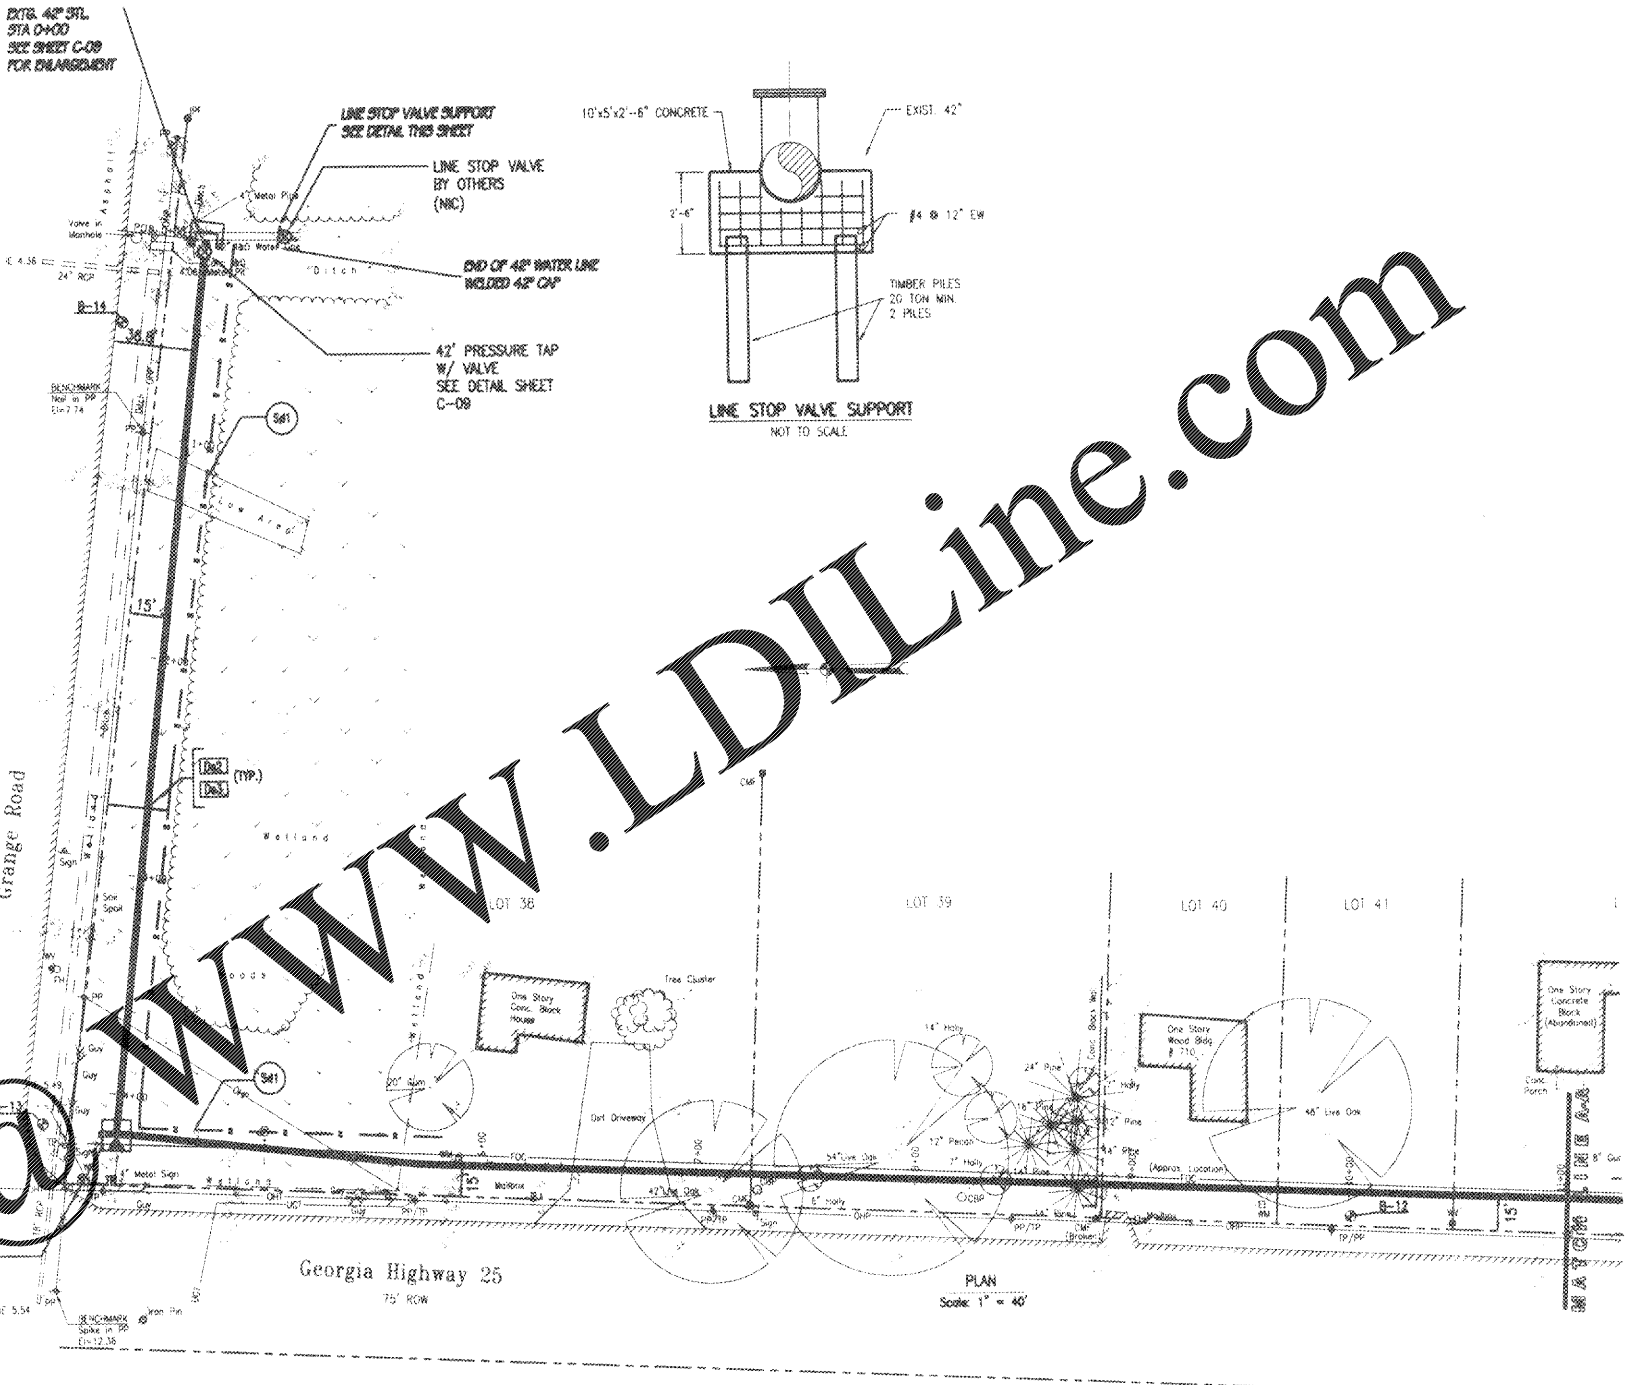


11/25/14 08:23:00 AS_BUILT/5/2013 00:00:00 14 15 20 24 2987

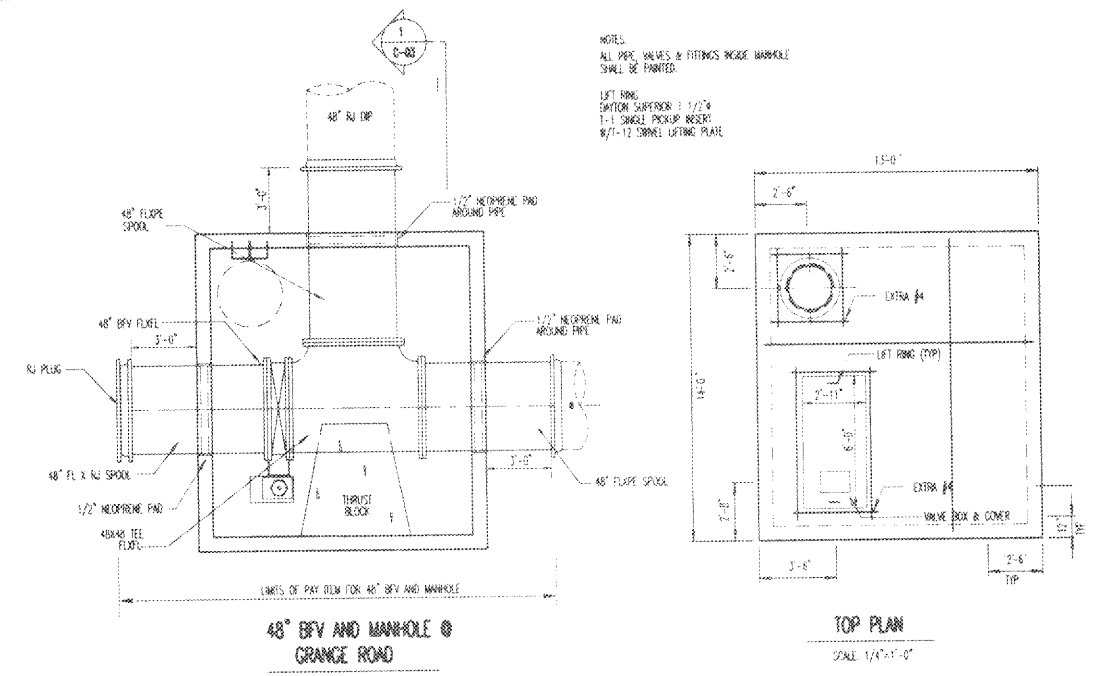

Order Plans @ www.LDILine.com

RECORD DRAWING
 JUNE 1997

HUSSEY, GAY, BELL & DEYOUNG INC.
 CONSULTING ENGINEERS

100 COMMERCIAL DRIVE
 SUITE 200
 WASHINGTON, DC 20004
 PHONE: 202-331-1000
 FAX: 202-331-1001



NO.	DATE	BY	CHKD.

U.S. WATER LINE REPLACEMENT
 FOR THE
 CITY OF SAVANNAH
 PLAN AND PROFILE

DRAWING NUMBER

C-03

G921