


3
FRANK C. HARRELL ETAL
SEE SHEET 17

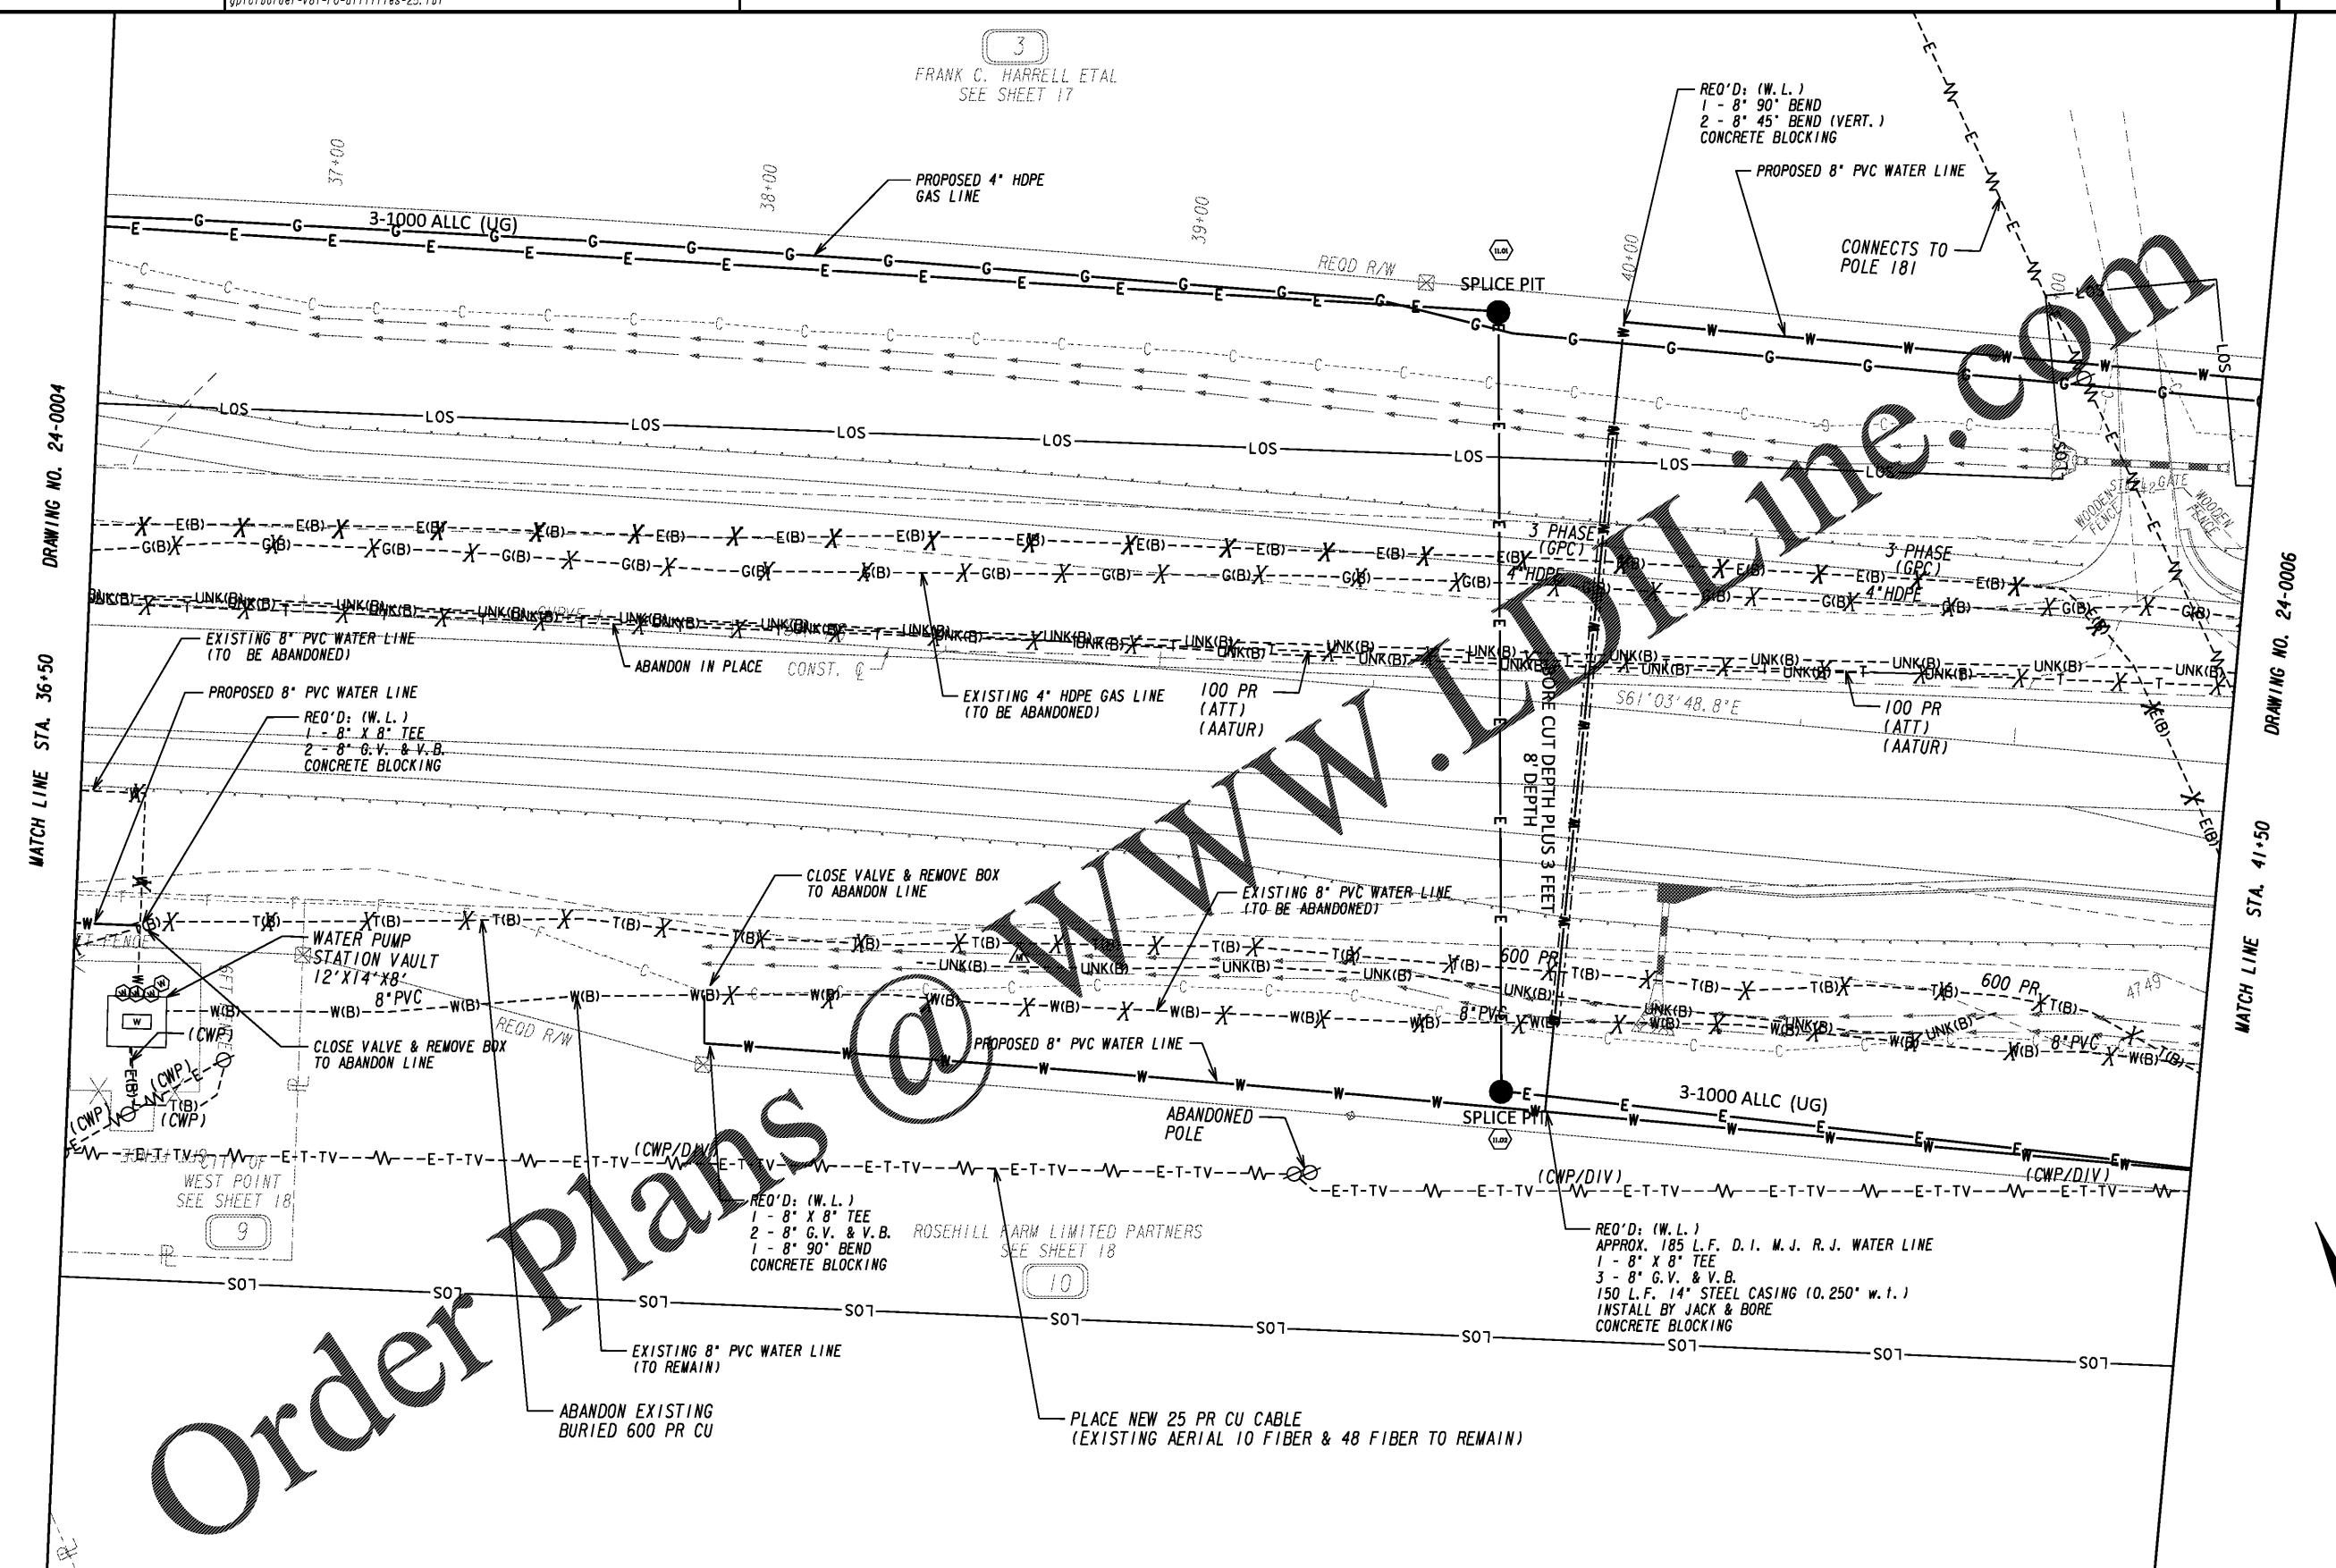

Order Plans @

Kimley»Horn

Engineering, Planning, and Environmental Consultants
Suite 350, 3930 East Jones Bridge Road
Peachtree Corners, Georgia 30092



REVISION DATES	

UTILITY PLANS		
1-85 @ SR 18 & SR 18 @ SR 103		
CHECKED:	DATE:	DRAWING No.
BACKCHECKED:	DATE:	24-0005
CORRECTED:	DATE:	
VERIFIED:	DATE:	