




Lancaster County, South Carolina  
**Heath Springs Soccer Complex**  
Lancaster County Parks & Recreation Soccer Complexes  
200 Boyd Falls Road  
Heath Springs, SC 29068

Revisions:

Proj. No.: 080703  
Date: 10/09/2020


Sheet Name:  
REFLECTED CEILING PLAN

**A-102**

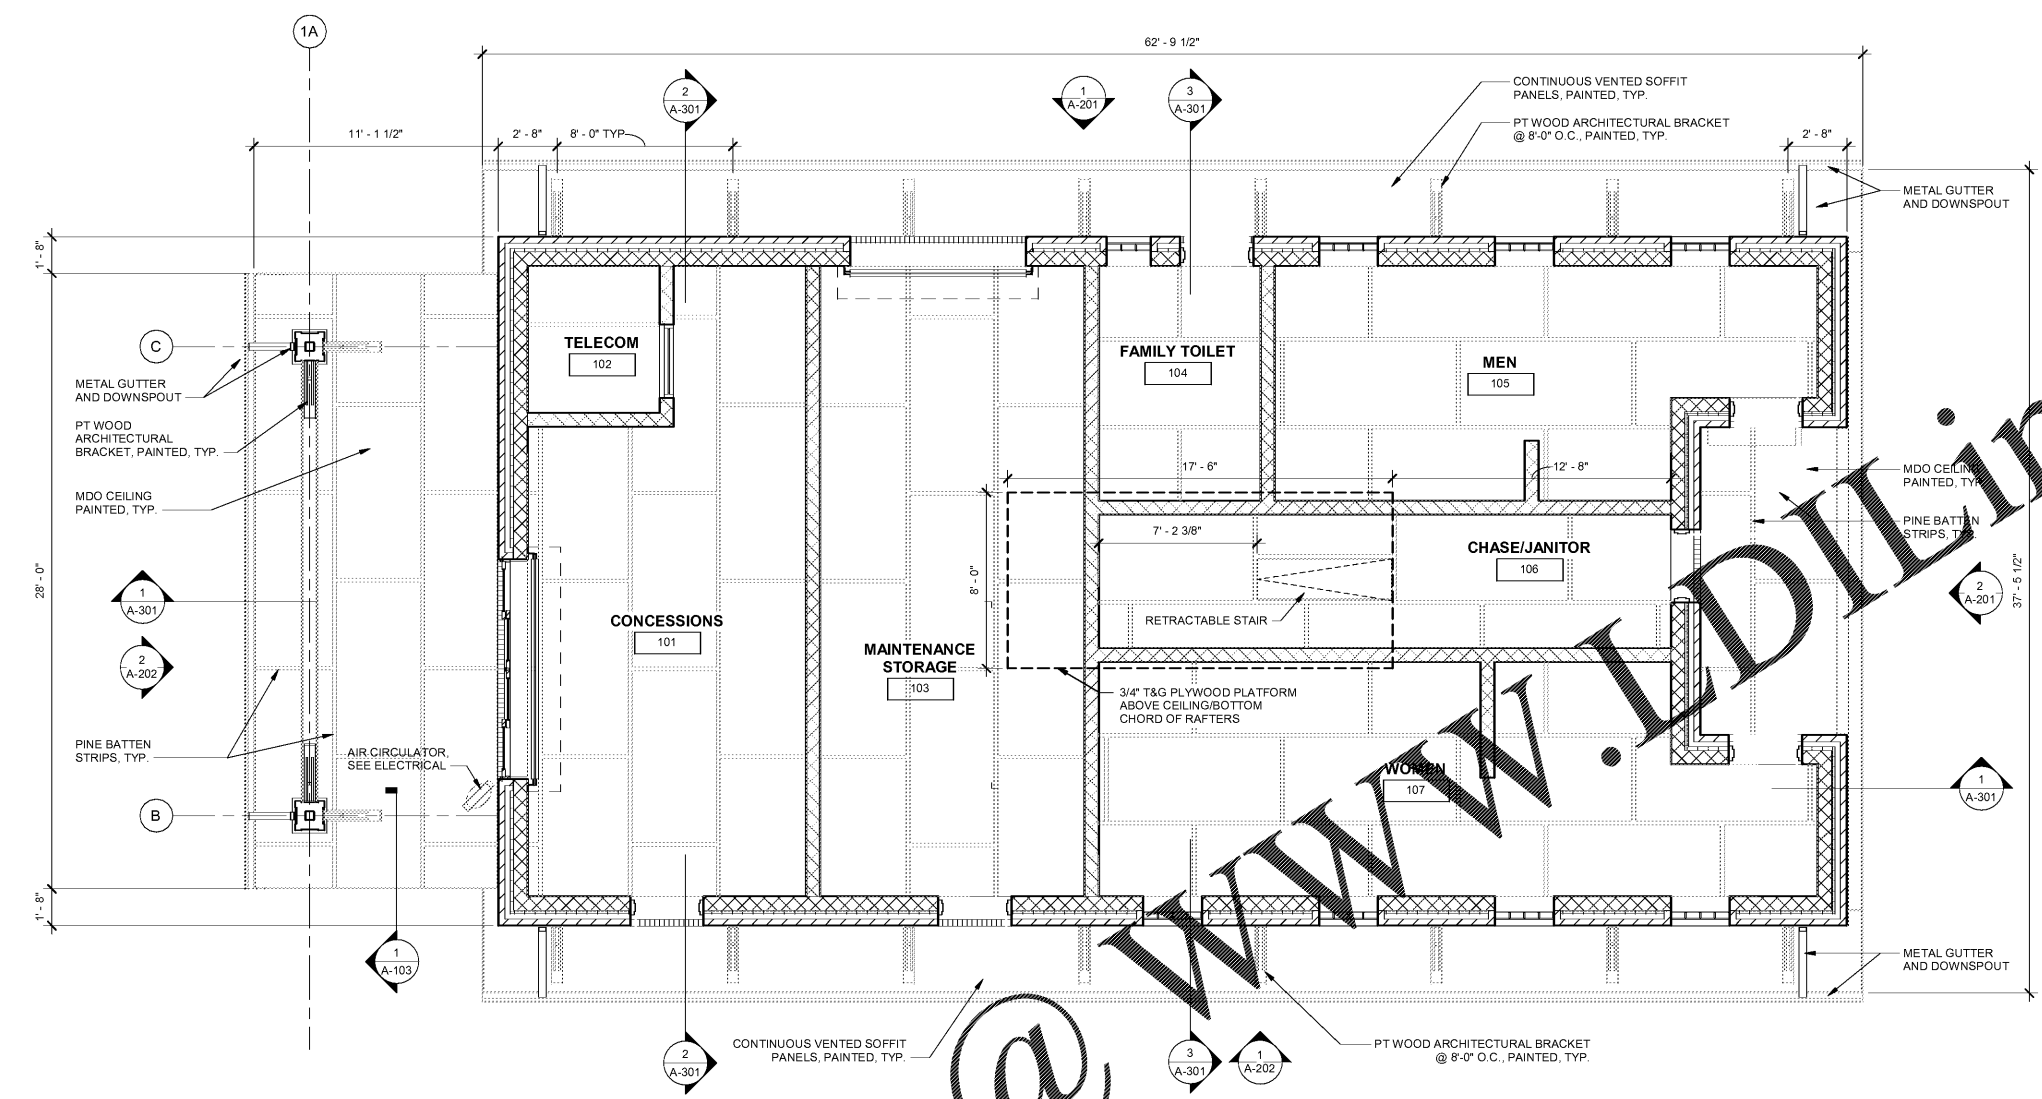

**REFLECTED CEILING PLAN**

 SCALE: 1/4" = 1'-0"



GENERAL NOTES		CEILING LEGEND	
1.	ALL CEILINGS ARE LOCATED AT BOTTOM OF ROOF TRUSSES UNLESS NOTED OTHERWISE. PROVIDE 1X4 PAINTED WOOD TRIM AT ALL TO CEILING CONDITION AT ALL INTERIOR AND EXTERIOR LOCATIONS.		MDO PLYWOOD CEILING
2.	KEEP FIXTURES, MECHANICAL DIFFUSERS AND MECHANICAL GRILLES CLEAR OF CEILING BATTENS.		SURFACE MOUNTED 4' OR 8' FLUORESCENT STRIP FIXTURE
3.	ALL CEILING MOUNTED SYSTEMS ARE SHOWN FOR COORDINATION PURPOSES ONLY.		WALL MOUNTED FLUORESCENT FIXTURE
4.	SEE ELECTRICAL DRAWINGS FOR LIGHT FIXTURES AND SPECIAL SYSTEM TYPES.		RETURN AIR GRILLE
5.	SEE MECHANICAL DRAWINGS FOR DIFFUSER AND GRILLE TYPES.		SUPPLY AIR DIFFUSER
6.	TELEPHONE CABLE AND FIRE PROTECTION SYSTEMS FOR ADDITIONAL INFORMATION OF CEILING MOUNTED DEVICES. ALL DIMENSIONS ARE CLEAR FINISHED DIMENSIONS, UNLESS OTHERWISE NOTED.		EXHAUST AIR GRILLE
			8'-0" CEILING HEIGHT TAG
			RECESSED DOWN LIGHT
			WALL MOUNTED LIGHT FIXTURE

