




10/09/2020

REFERENCE KEYNOTES:

- 305 PIPING RUN IN ATTIC SPACE ABOVE CEILING, BENEATH INSULATION LAYER.
- 306 COORDINATE WITH GENERAL CONTRACTOR ON INSULATION IN ATTIC. VERIFY BLANKET INSULATION IS DOUBLE LAYERED ON TOP OF ALL DOMESTIC WATER PIPING IN ATTIC TO PREVENT FREEZING OF PIPE.
- 308 ROUTE WATER PIPING WITH UNFINISHED CHASE SPACE.
- 309 PROVIDE FOR DRAINAGE OF WATER SUPPLY AND P-TRAP DURING WINTER.

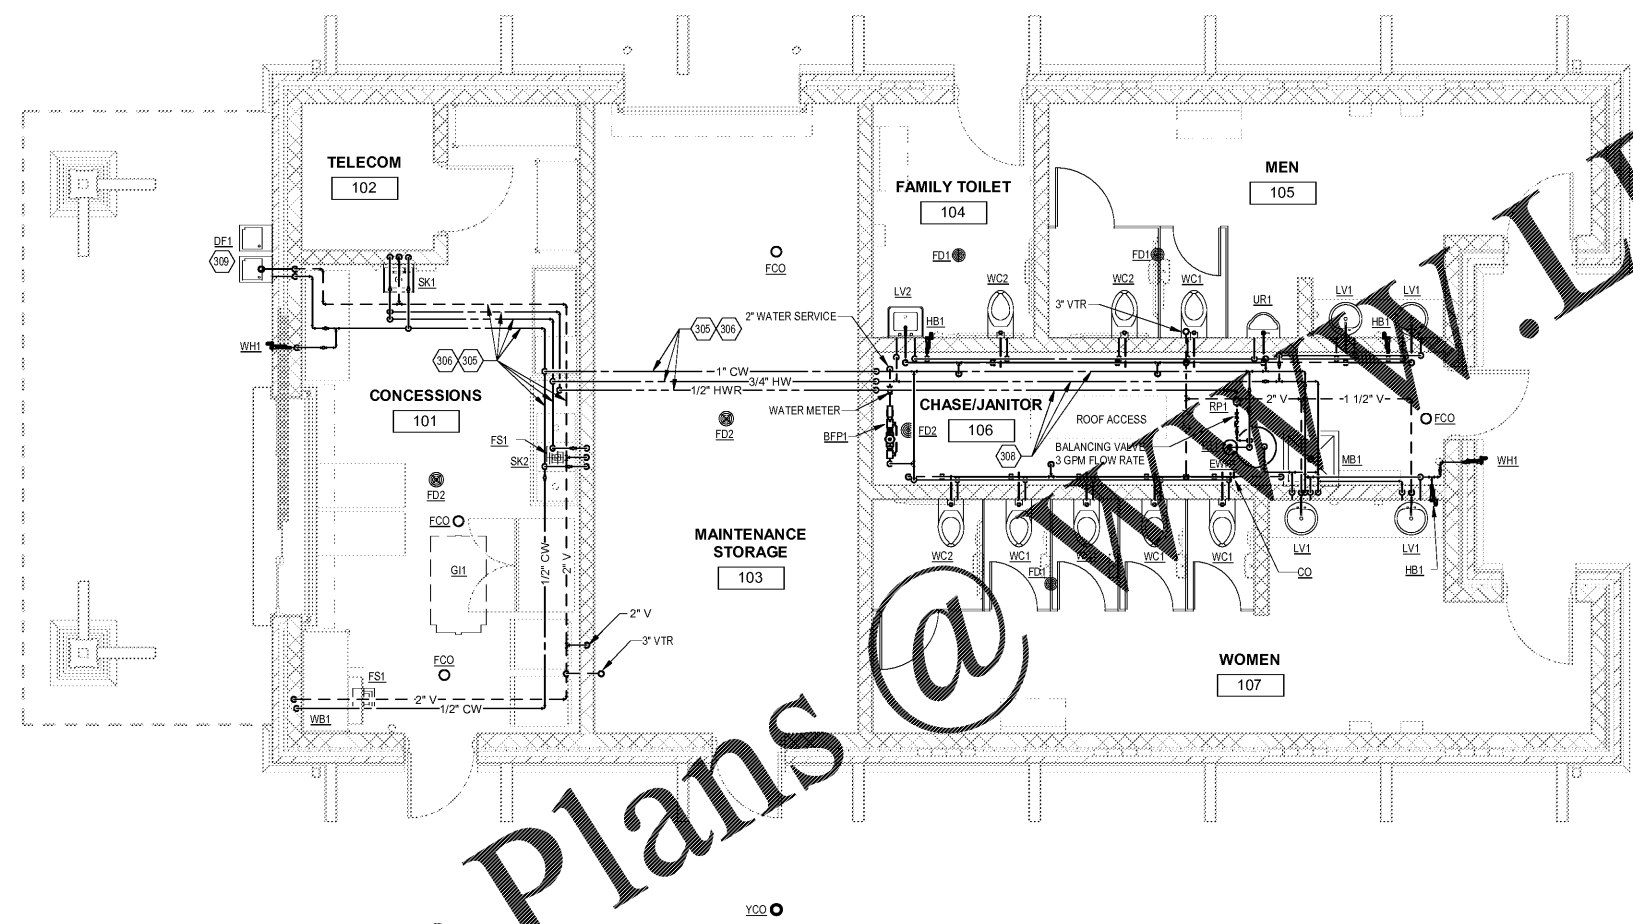

1 PLUMBING FLOOR PLAN
SCALE: 1/4" = 1'-0"

Order Plans @ www.LDILine.com

Lancaster County, South Carolina
Heath Springs Soccer Complex

200 Boyd Falle Road
Heath Springs, SC 29058

Revisions:

Proj. No.: 80703
Date: 10/09/2020

Sheet Name:
PLUMBING FLOOR PLAN

