




Lancaster County, South Carolina
Indian Land Soccer Complex
Lancaster County Parks & Recreation Soccer Complexes
10167 Harrisburg Road
Indian Land, SC 29707

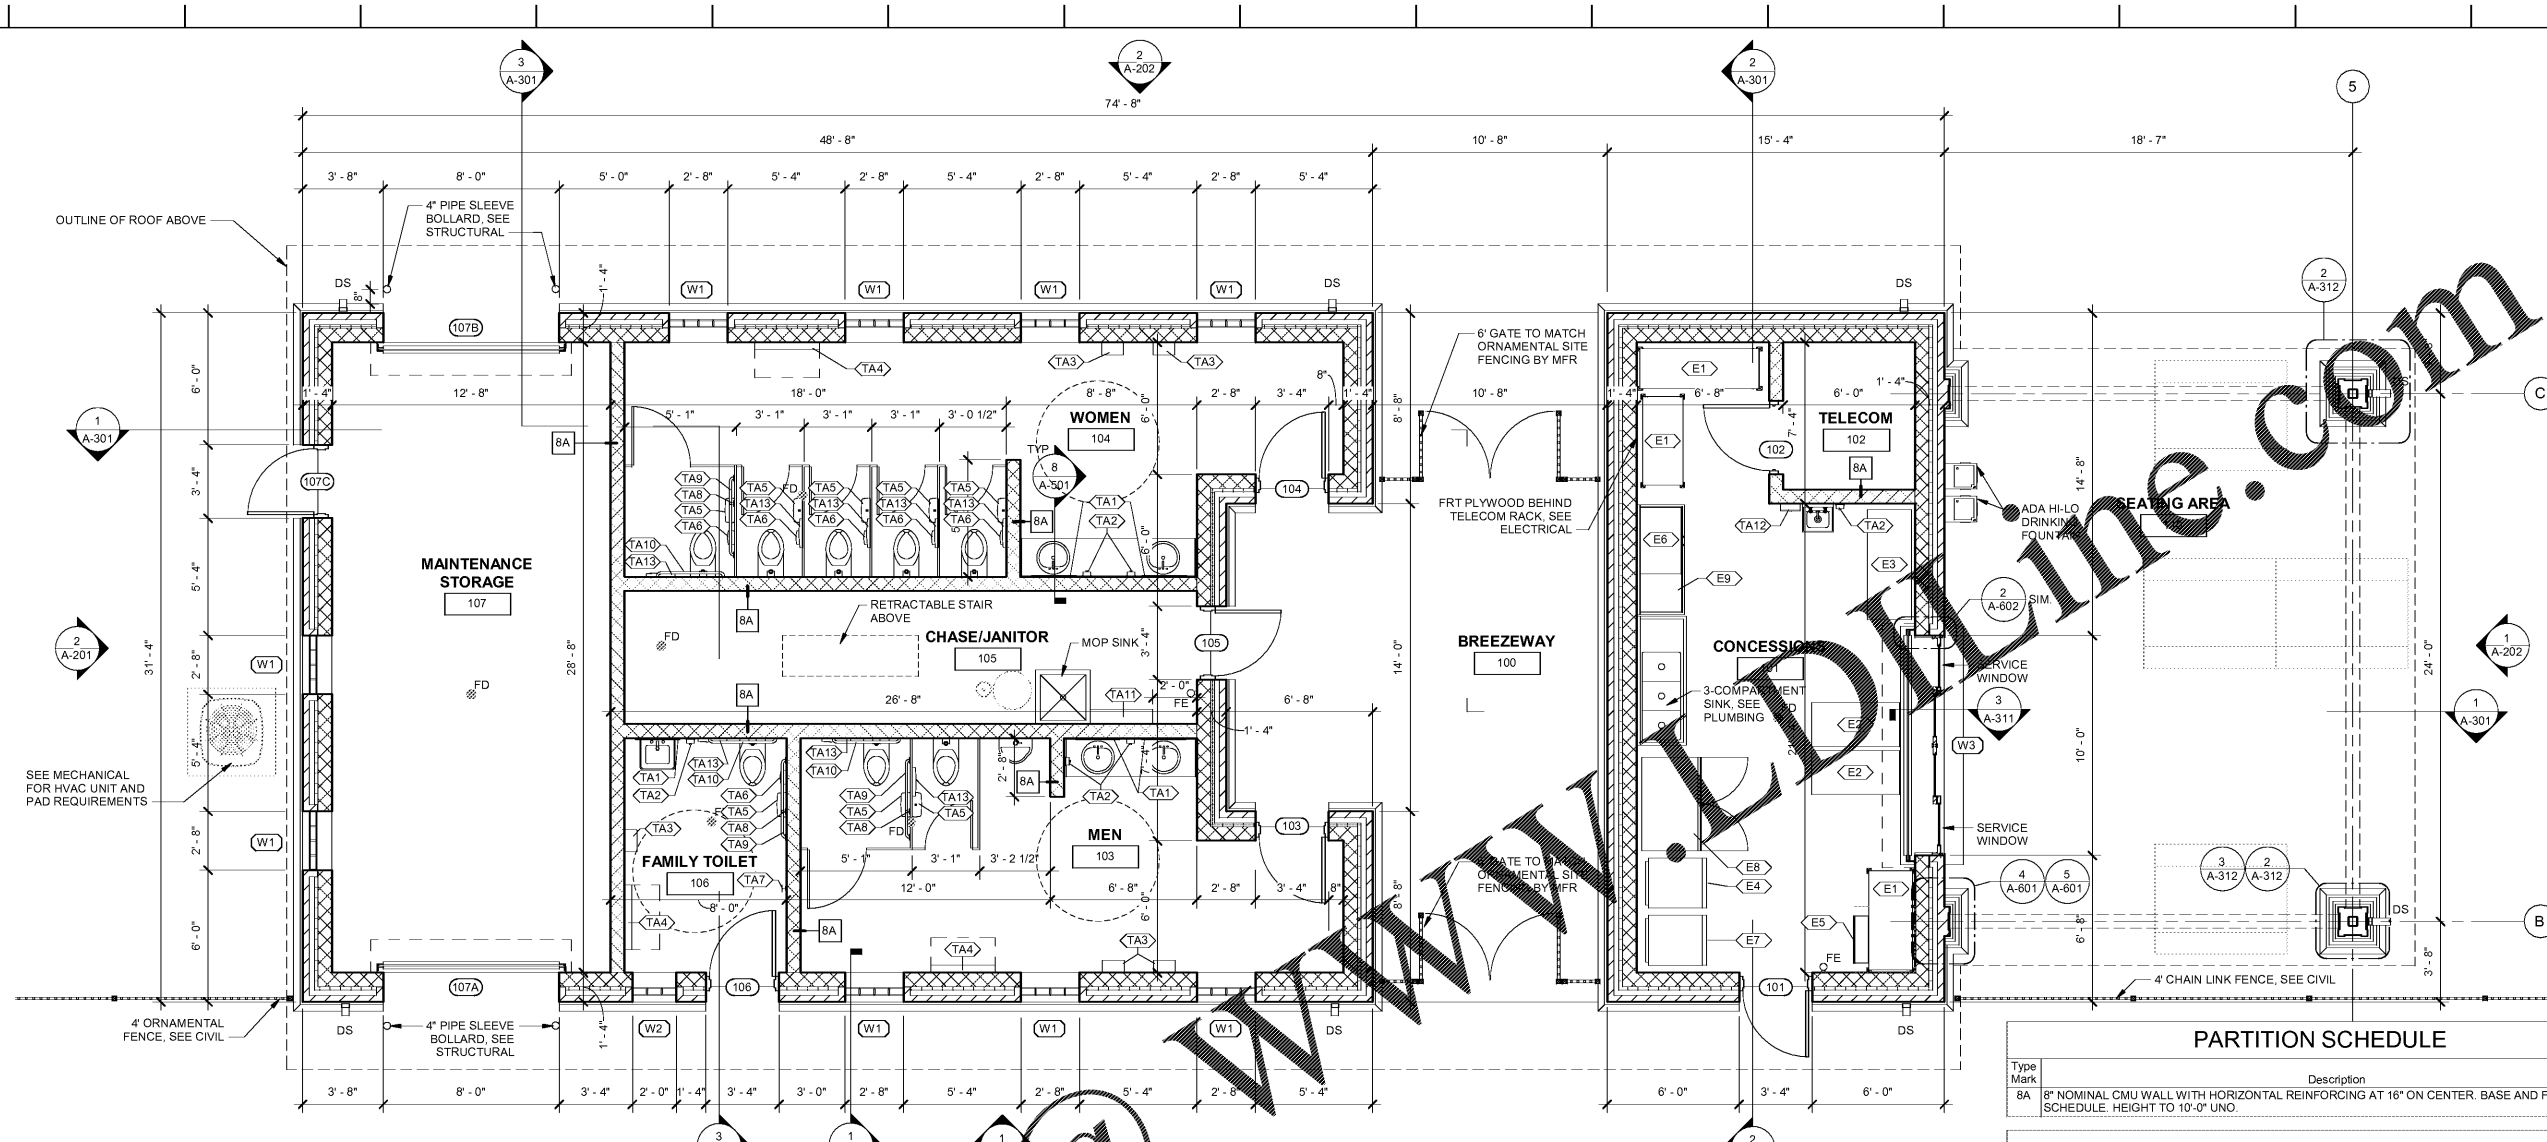

FLOOR PLAN
SCALE: 1/4" = 1'-0"

PARTITION SCHEDULE

Type Mark	Description
8A	8" NOMINAL CMU WALL WITH HORIZONTAL REINFORCING AT 16" ON CENTER. BASE AND FINISH PER SCHEDULE. HEIGHT TO 10'-0" UNO.

TOILET ACCESSORIES SCHEDULE

NO.	PRODUCT DESCRIPTION
TA1	MIRROR W/ STAINLESS STEEL ANGLE FRAME, BOBRICK B-290 2436
TA2	SURFACE MOUNTED SOAP DISPENSER, DEB PROLINE CURVE 1000 BLACK, 91128
TA3	ELECTRIC HAND DRYER, XLERATOR XL-BW
TA4	BABY CHANGING STATION, KOALA KB110-SSWM
TA5	TOILET TISSUE DISPENSER, TORK MINI JUMBO BATH TISSUE ROLL DISPENSER WITH RESERVE, 555028A
TA6	SANITARY NAPKIN DISPOSAL, BOBRICK B-270
TA7	CLOTHES HOOK WITH BUMPER, BOBRICK B-212
TA8	18" STAINLESS STEEL GRAB BAR, BOBRICK B-5806X18
TA9	42" STAINLESS STEEL GRAB BAR, BOBRICK B-5806X42
TA10	36" STAINLESS STEEL GRAB BAR, BOBRICK B-5806X36
TA11	STAINLESS STEEL SHELF WITH MOP AND BROOM HOLDERS AND HOOKS, BOBRICK B-239X34
TA12	SURFACE MOUNTED PAPER TOWEL DISPENSER, BOBRICK B-262
TA13	SURFACE MOUNTED TOILET SEAT COVER DISPENSER, BOBRICK B-4221


EQUIPMENT SCHEDULE

NO.	PRODUCT DESCRIPTION
E1	ADJUSTABLE UTILITY SHELVING SYSTEM BY OWNER
E2	STAINLESS STEEL WORK TABLE W/ SHELF, AERO 4TG-2448 OR EQ.
E3	STAINLESS STEEL WORK TABLE W/ SHELF, AERO 4TG-2460 OR EQ.
E4	COMMERCIAL GLASS-DOOR REFRIGERATOR, AVANTCO 178A23RGHC OR EQ.
E5	UNDERCOUNTER ICE MACHINE, AVANTCO 194UC210HA OR EQ.
E6	TABLE-TOP POPCORN MACHINE BY OWNER
E7	COMMERCIAL S.S. FREEZER, AVANTCO 178A19FHC OR EQ.
E8	BEVERAGE COOLER BY OWNER
E9	STAINLESS STEEL WORK TABLE W/ SHELF AND BACKSPASH, AERO 4TG-2460 OR EQ.

SYMBOL LEGEND

SYMBOL	DESCRIPTION
[Pattern]	INTERIOR MASONRY WALL
[Pattern]	EXTERIOR MASONRY / BRICK VENEER WALL

ALL CMU BLOCK CORNERS 1" BULLNOSED

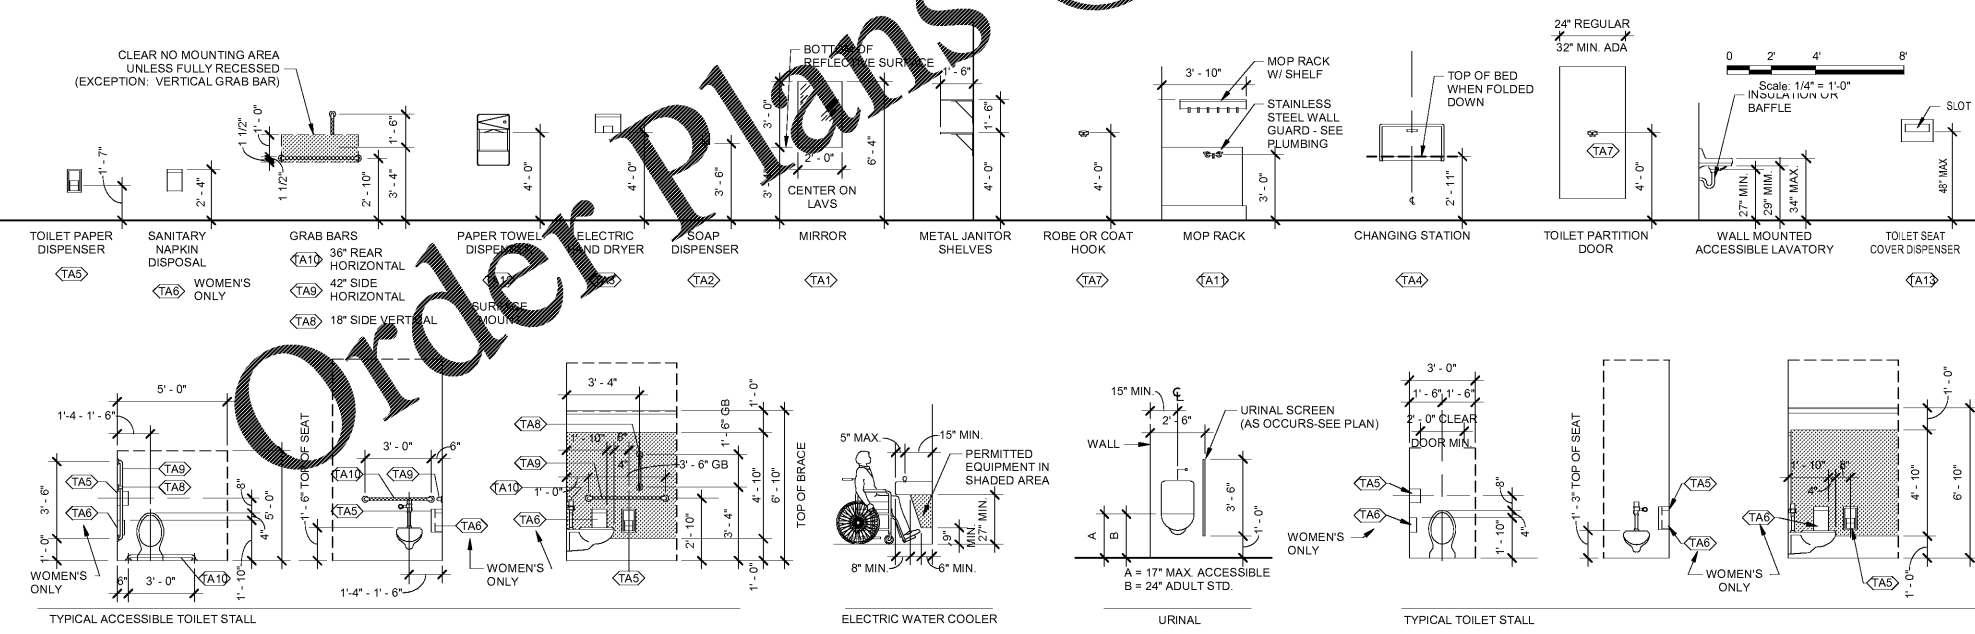

TYPICAL PLUMBING FIXTURES & TOILET ACCESSORY ELEVATIONS
SCALE: 1/4" = 1'-0"

Proj. No.: 080702
Date: 10/09/2020

Sheet Name:
FLOOR PLAN