




Revisions:

 
Proj. No.: 080702
Date: 10/09/2020

Sheet Name:
REFLECTED CEILING PLAN

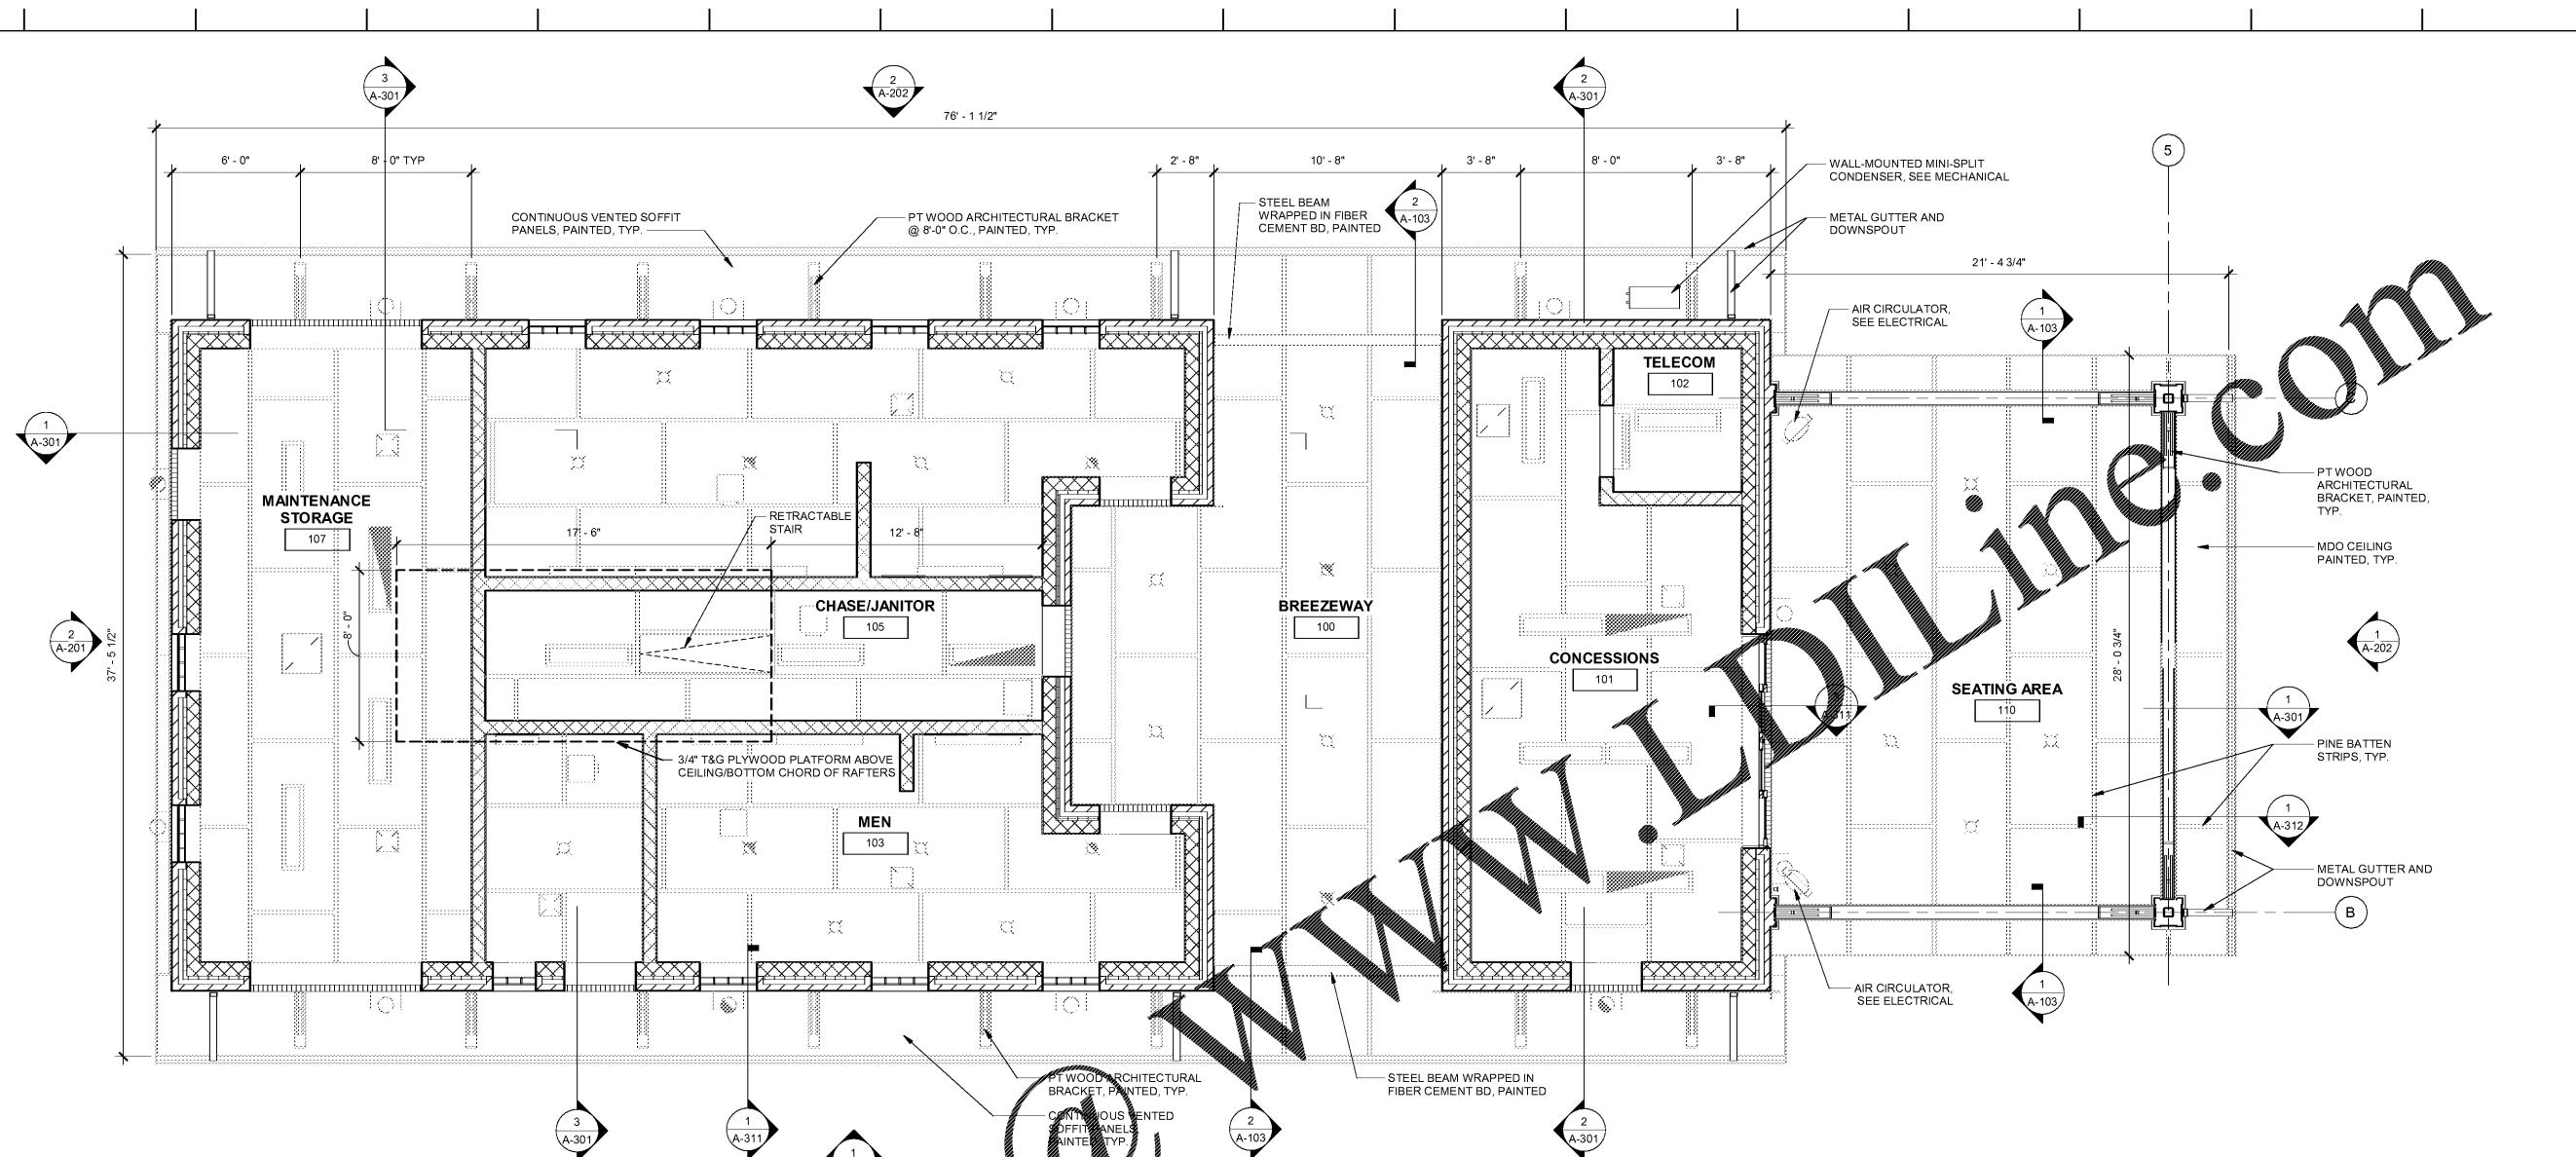

REFLECTED CEILING PLAN

SCALE: 1/4" = 1'-0"



GENERAL NOTES	CEILING LEGEND
1. ALL CEILINGS ARE LOCATED AT BOTTOM OF ROOF TRUSSES UNLESS NOTED OTHERWISE.	MDO PLYWOOD BRACKET, PAINTED, TYP.
2. PROVIDE 1X4 PAINTED WOOD TRIM AT WALL TO CEILING CONDITION AT ALL INTERIOR AND EXTERIOR LOCATIONS.	SURFACE MOUNTED 4' OR 8' FLUORESCENT STRIP FIXTURE
3. KEEP FIXTURES, MECHANICAL DIFFUSERS AND MECHANICAL GRILLES CLEAR OF CEILING BATTENS.	WALL MOUNTED FLUORESCENT FIXTURE
4. ALL CEILING MOUNTED ITEMS ARE SHOWN FOR COORDINATION PURPOSES ONLY.	RETURN AIR GRILLE
5. SEE ELECTRICAL DRAWINGS FOR LIGHT FIXTURE AND SPECIAL SYSTEM TYPES.	SUPPLY AIR DIFFUSER
6. SEE MECHANICAL DRAWINGS FOR DIFFUSERS AND GRILLE TYPES.	EXHAUST AIR GRILLE
7. SEE TELECOMMUNICATION AND FIRE PROTECTION SYSTEMS FOR ADDITIONAL INFORMATION ON CEILING MOUNTED DEVICES.	CEILING HEIGHT TAG
8. ALL RFP DIMENSIONS ARE CLEAR FINISH DIMENSIONS, UNLESS OTHERWISE NOTED.	RECESSED DOWN LIGHT
	WALL MOUNTED LIGHT FIXTURE

