
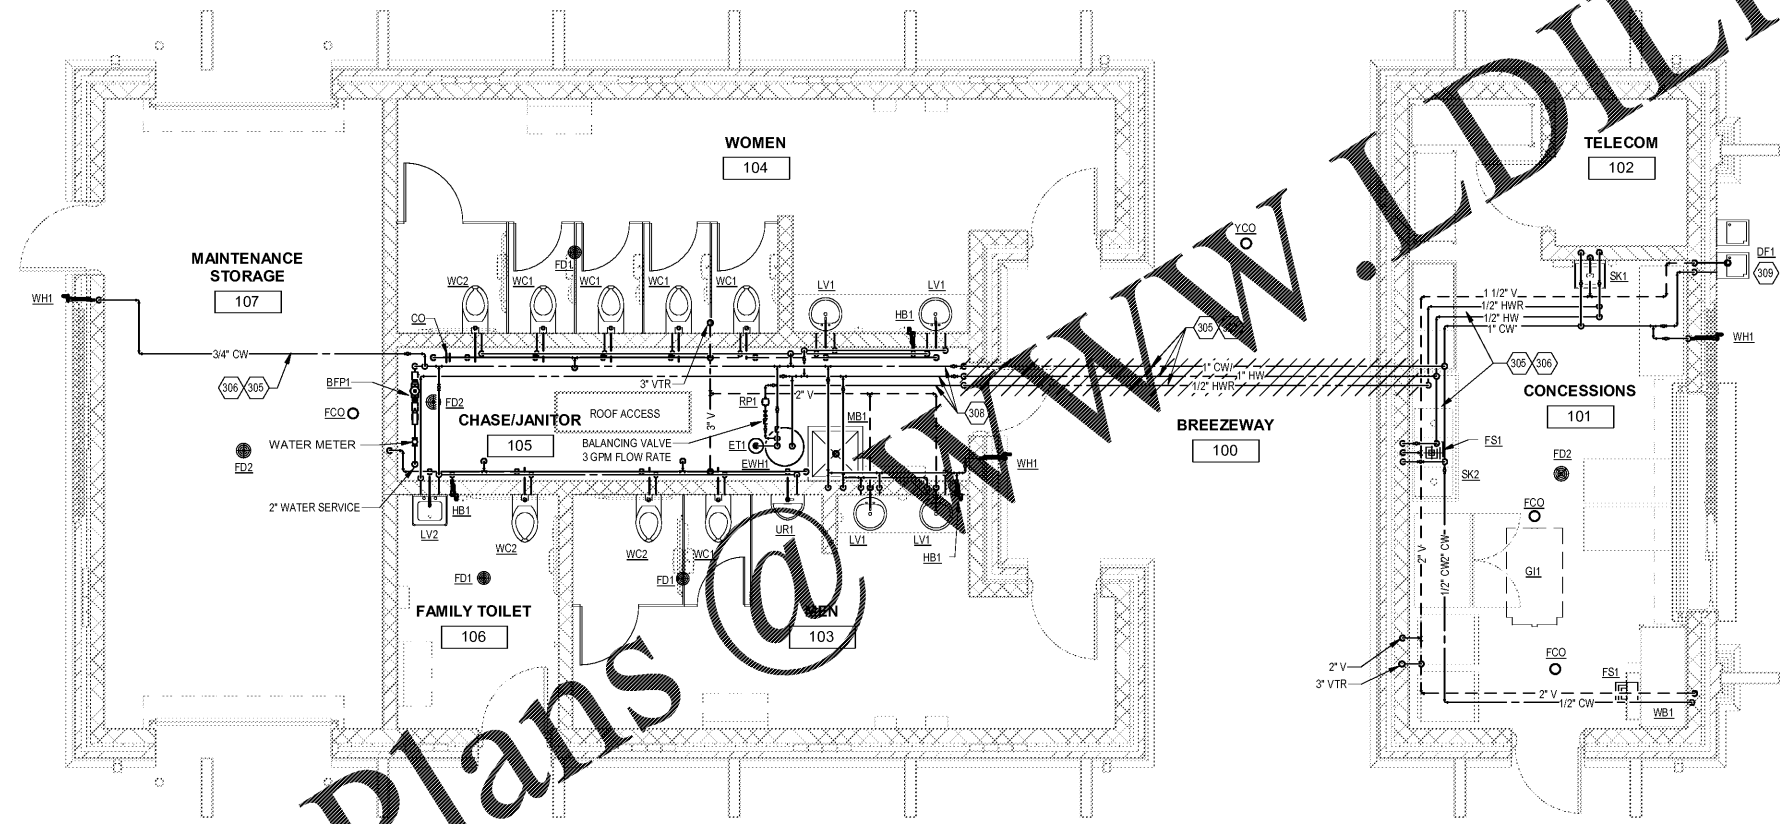


REFERENCE KEYNOTES:

- 305 PIPING RUN IN ATTIC SPACE ABOVE CEILING, BENEATH INSULATION LAYER.
- 306 COORDINATE WITH GENERAL CONTRACTOR ON INSULATION IN ATTIC. VERIFY BLANKET INSULATION IS DOUBLE LAYERED ON TOP OF ALL DOMESTIC WATER PIPING IN ATTIC TO PREVENT FREEZING OF PIPE.
- 307 PROVIDE AND INSTALL HEATING TAPE ON DOMESTIC WATER PIPING IN ATTIC RUN ABOVE BREEZEWAY SPACE FOR FREEZE PROTECTION. BASIS OF DESIGN: THERMON 3-FLX-1 SELF-REGULATING HEATING CABLE. APPROVED EQUAL START UP TEMPERATURE: 50°F. LENGTHS LESS THAN 30 FEET, 110 V, 20 A. SATISFY CODES. PROVIDE AND INSTALL STRUCTURE TO ADJUST AMBIENT SENSING THERMIST, CABLE SPLICES, END SEALS, SUPPORT BRACKET, COLUMN TAPES AND ELECTRIC TRACE LABELS TO BE APPLIED EVERY 10'. COORDINATE WITH ELECTRICAL CONTRACTOR. FOLLOW MANUFACTURER'S INSTALLATION AND WARRANTY DOCUMENTATION REQUIREMENTS.
- 308 ROUTE WATER PIPING WITHIN HEATED CHASE SPACE. PROVIDE FOR DRAINAGE OF WATER SUPPLY AND P-TRAP DURING WINTER MONTHS.

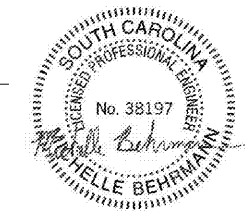

1 PLUMBING FLOOR PLAN
SCALE: 1/4" = 1'-0"

Order Plans @ www.LDILine.com

Lancaster County, South Carolina
Indian Land Soccer Complex

10167 Harrisburg Road
Indian Land, SC 29707

Revisions:

Proj. No.: 80702
Date: 10/09/2020

Sheet Name:
PLUMBING FLOOR PLAN

