

GENERAL NOTES:

A. REFER TO EQUIPMENT DATA SCHEDULE ON SHEET E-602 FOR CONNECTION REQUIREMENTS OF MECHANICAL EQUIPMENT.

REFERENCE KEYNOTES:

- 501 REFER TO DRAWING DETAIL #E-501 FOR CONTROL AND WIRING REQUIREMENTS FOR EXTERIOR LIGHTING.
- 504 CONNECT EXHAUST FAN TO UNSWITCHED LIGHTING CIRCUIT IN SAME SPACE. CONTROLS BY MECHANICAL CONTRACTOR.
- 506 PROVIDE PENDANT MOUNTING TO LOW CEILING FOR CONCESSIONS LIGHT FIXTURES. COORDINATE WITH BATTEN CEILING FINISH TOUGH-1.
- 508 PROVIDE (2) 2" CONDUITS WITH PULLSTRINGS FROM SPORTS LIGHTING CONTROL PANEL TO HANDHOLE. REFER TO SITE PLAN FOR LOCATION OF HANDHOLE.
- 510 PROVIDE (2) 2" CONDUITS WITH PULLSTRINGS FROM LIGHTING CONTROL PANEL TO HANDHOLE.
- 511 PROVIDE DEDICATED 20A-120V CIRCUIT TO IRRIGATION CONTROLLER. PROVIDE (1) 2" CONDUIT WITH PULLSTRING FROM IRRIGATION CONTROLLER TO NEAREST LANDSCAPE AREA. REFER TO SITE PLAN FOR LOCATION.
- 512 WALL MOUNTED LIGHT FIXTURES SHALL BE MOUNTED 8'-0" AFF TO BOTTOM OF FIXTURE.
- 513 LOCATED IN ATTIC ABOVE.
- 514 PROVIDE CONDUIT AND WIRING FROM UTILITY PROVIDED PAD MOUNT TRANSFORMER TO MAIN DISTRIBUTION PANEL MDP. SEE SINGLE-LINE DIAGRAM ON SHEET E-601 FOR CONDUIT AND WIRING SIZING AND QUANTITIES.
- 515 PROVIDE RECEPTACLE UNDER COUNTER FOR PLUG-IN AUTOMATIC FAUCETS.
- 516 REFER TO ARCHITECTURAL REFLECTED CEILING PLAN FOR SPACING AND LAYOUT OF RECESSED LIGHTING FIXTURES IN TYPICAL.
- 517 PROVIDE AND INSTALL SERVICE RECEPTACLE IN ATTIC SPACE FOR AHU-1.



11301 Carmel Commons Blvd
Suite 300
Charlotte, NC 28226
704.525.6284
FAX: 704.525.0115



Lancaster County, South Carolina
Heath Springs Soccer Complex

200 Boyd Falle Road
Heath Springs, SC 29068


Revisions:

- 1 County Permit Review 1 11/20/20

Proj. No.: 80703
Date: 10/09/2020

Sheet Name:
ELECTRICAL
LIGHTING, POWER
& SYSTEMS PLANS

E-101

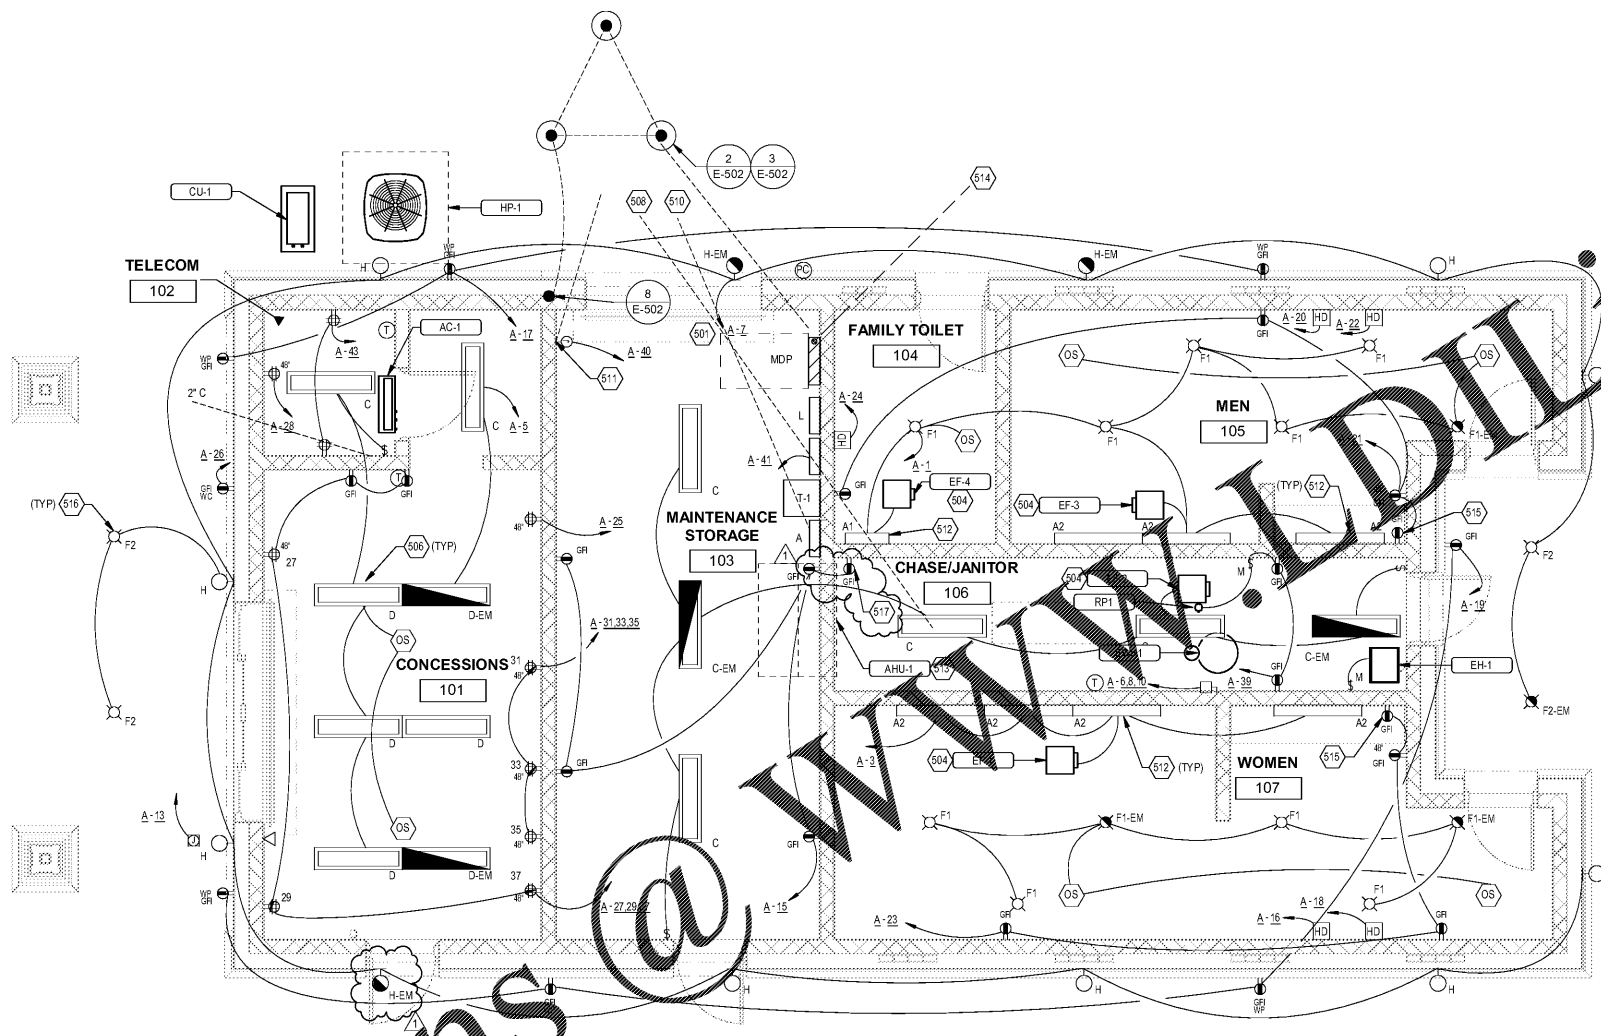

1 LIGHTING, POWER & SYSTEMS PLAN
SCALE: 1/4" = 1'-0"

Order Plans @ www.woolpert.com