 


GREENCO of Augusta, Inc.  
 Consulting Engineering  
 P. O. Box 55  
 Harlem, GA 30814  
 706-556-0405  
 706-449-0732 fax

ARCHITECTS  
 Christopher Booker & Associates, PC



670 BROAD STREET, AUGUSTA, GA 30901 | P: (706) 798-6792 | WWW.CBARARCHITECTSPC.COM

PROPOSED BUILDING SHELL &  
 DUNKIN' DONUTS PC# 362912

APS INVESTMENT, INC.

5303 WRIGHTSBORO ROAD  
 GROVETOWN, GEORGIA 30813



HVAC PLAN

DRAWN BY: JS

CHECKED BY:

DATE: JANUARY 13, 2021

REVISIONS:

JOB NO:


2052-A

SHEET NO:

M2.0

SHELL DESIGN

Order Plans @ WWW.LDILine.com

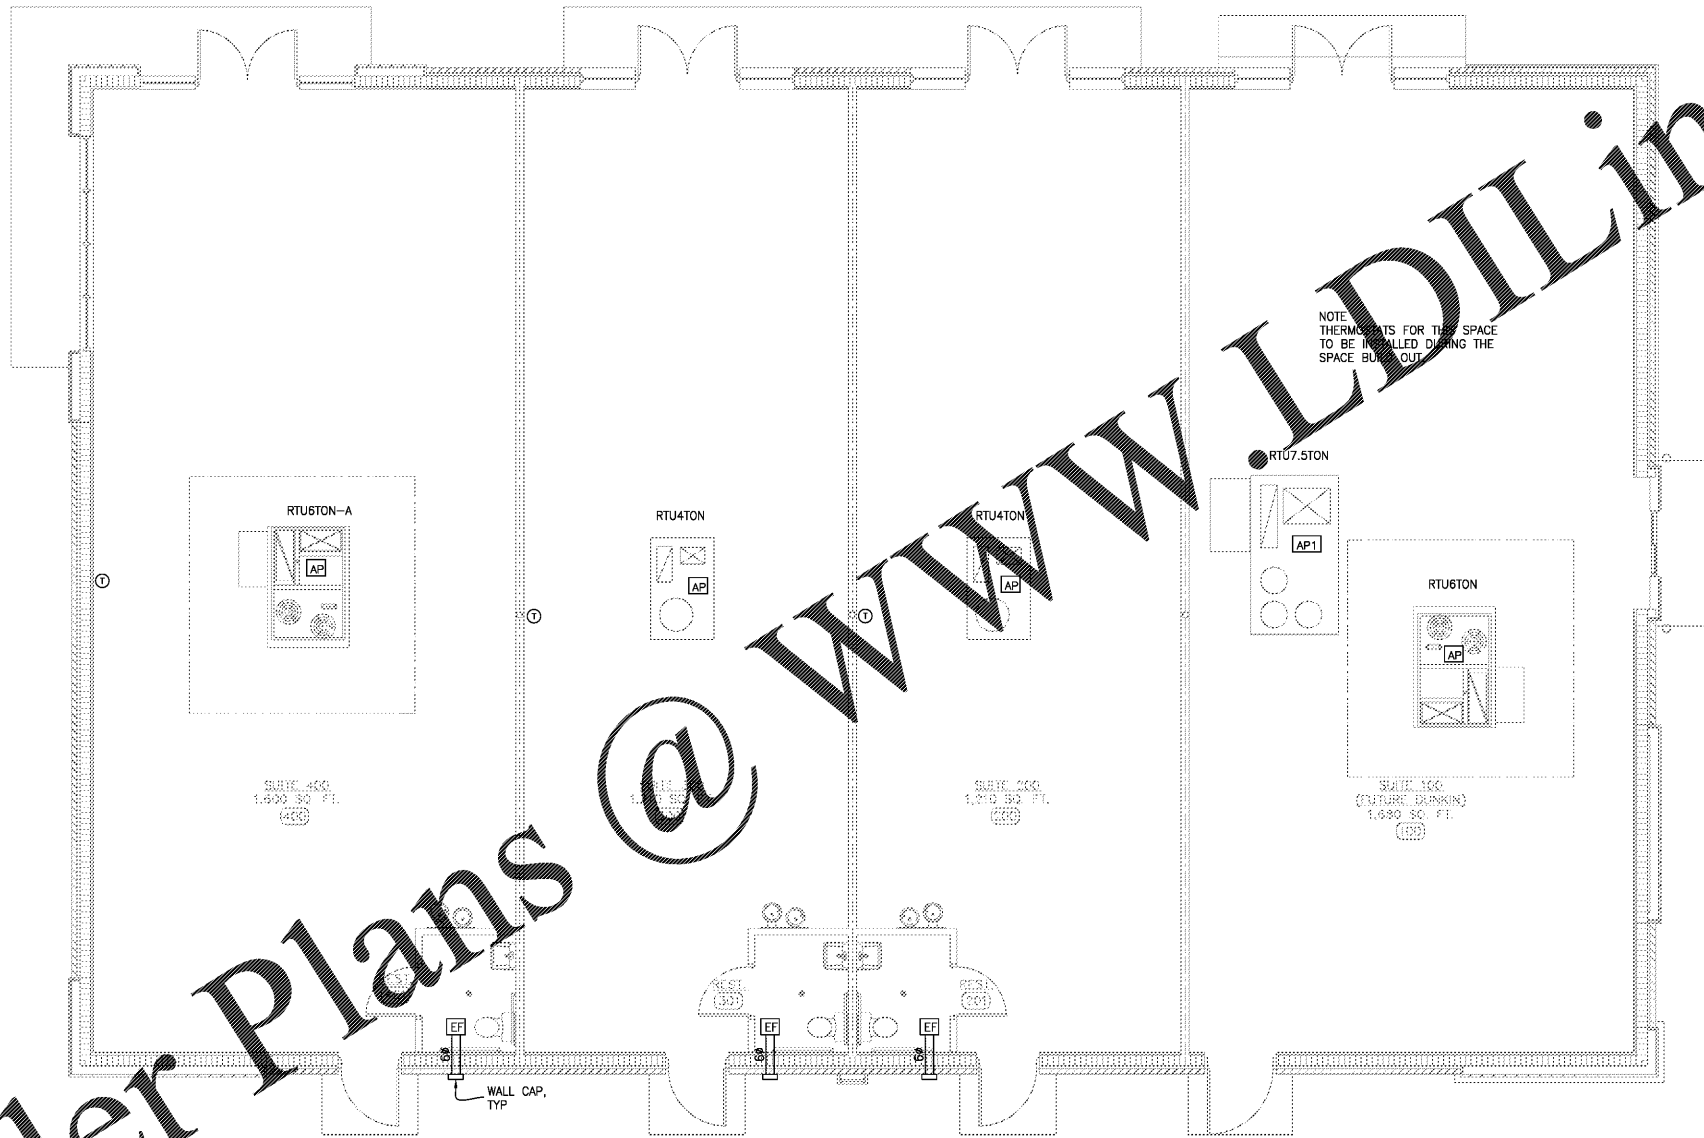

NOTE: THERMOSTATS FOR THIS SPACE TO BE INSTALLED DURING THE SPACE BUILD OUT.

RTU7.5TON

RTU6TON-A

RTU4TON

RTU4TON

RTU6TON

SUITE 400  
1,600 SQ. FT.

SUITE 200  
1,210 SQ. FT.

SUITE 100  
(FUTURE DUNKIN)  
1,650 SQ. FT.

WALL CAP.  
TYP

1 HVAC PLAN (SHELL)  
M2.0 SCALE: 3/16" = 1'-0"

