


Order Plans @ www.LDILine.com

- NOTES:**
1. REFER TO DRAWING E-3.0 FOR GENERAL NOTES AND SPECIFICATIONS.
 2. CONNECT EXIT SIGNS AND EMERGENCY LIGHTS TO A NON-SWITCH LEG (HOT) OF THE LIGHTING CIRCUIT FEEDING THIS AREA.
 3. COORDINATE LOCATION AND HEIGHT WITH DUNKIN DONUT BUILD-OUT PLANS PRIOR TO ROUGH-IN.
 4. COORDINATE LOCATION AND HEIGHT WITH ARCHITECTURAL PLANS PRIOR TO ROUGH-IN.
 5. ROUTE BOTH A SWITCHED LEG (VIA A TIMER) AND A NON-SWITCHED LEG (DIRECT FROM BREAKER) FOR THIS LIGHTING CIRCUIT.
 6. STUB 1/2" CONDUIT THRU WALL FOR FUTURE CONNECTION DURING DUNKIN DONUT'S BUILDOUT.
 7. DIMENSIONS ARE FOR REFERENCE ONLY. COORDINATE FINAL LOCATION WITH GC AND/OR OWNER PRIOR TO ROUGH-IN.
 8. UNLESS OTHERWISE NOTED, HOME RUNS FOR ALL 15 AND 20 AMP BRANCH CIRCUITS LONGER THEN 75 FEET SHALL BE AT LEAST 10 AWG.
 9. MAINTAIN 24" (MIN) HORIZONTAL OFFSET BETWEEN ELECTRICAL BOXES ON OPPOSITE SIDES OF FIRE RATED WALLS.

REFLECTED CEILING PLAN LEGEND:

LED-12	EXTERIOR STRIP LIGHT FIXTURE (LED)
LED-13	EXTERIOR SIGNITE FIXTURE WITH 18" ARM (LED)
LED-14	EXTERIOR WALL PACK (LED)
WSCX-2	EXTERIOR WALL PACK (LED)
EWS-1	EXTERIOR UNDER RECESSED LIGHT FIXTURE (LED), UNDER D/I & ENTRY CANOPY
LED-2	EXTERIOR WALL LIGHT FIXTURE (LED)
⊕	WALL MOUNTED LIGHT FIXTURE (LED)
⊙	EXIT & EMERGENCY LIGHT WITH 1/2" HR. B.B.U. - FACE ON DARK SIDE (WALL MOUNT)
⊙	EXTERIOR EMERGENCY LIGHT WITH 1/2" HR. B.B.U. (CEILING/WALL MOUNT)
⊕	HVAC SUPPLY AIR DIFFUSER
⊙	HVAC AIR RETURN

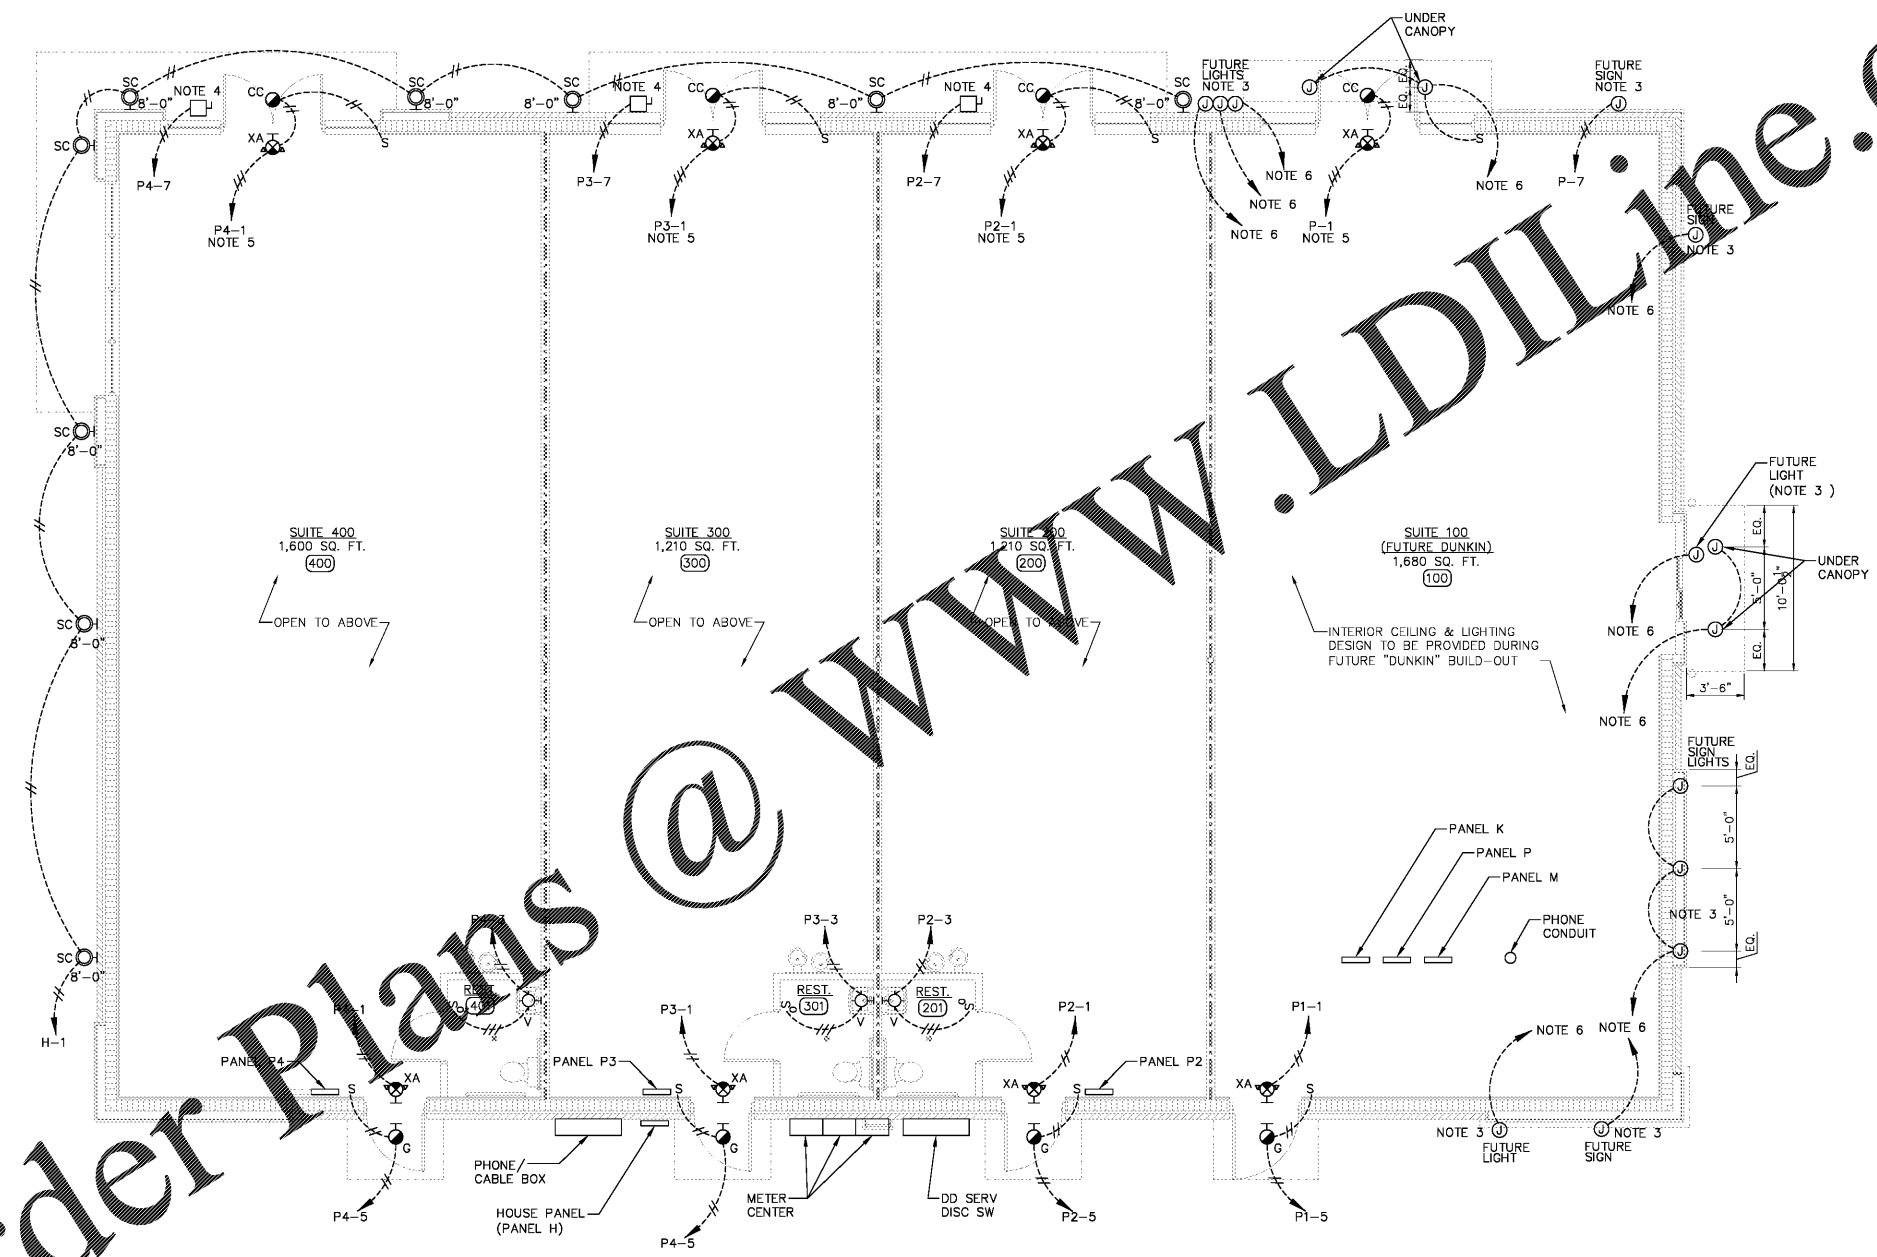

1 LIGHTING PLAN (SHELL)
E1.0 SCALE: 3/16" = 1'-0"



CLIFFORD LUSK, PE
ELECTRICAL ENGINEER
OFFICE: 803-652-7220
CELL: 803-645-3495
EMAIL: CLUSKPE@AOL.COM

SHELL DESIGN

ARCHITECTS
Christopher Booker & Associates, PC
670 BROAD STREET, AUGUSTA, GA 30901 | P: (706) 798-6792 | WWW.CBARCHITECTSPC.COM

PROPOSED BUILDING SHELL &
DUNKIN' OMNI PC# 362912
APS INVESTMENT, INC.
5303 WRIGHTSBORO ROAD
GROVETOWN, GEORGIA 30813

LIGHTING PLAN

DESIGN BY:	COL
CHECKED BY:	
DATE:	JANUARY 13, 2021
REVISIONS:	
JOB NO.:	2052-A
SHEET NO.:	E1.0