
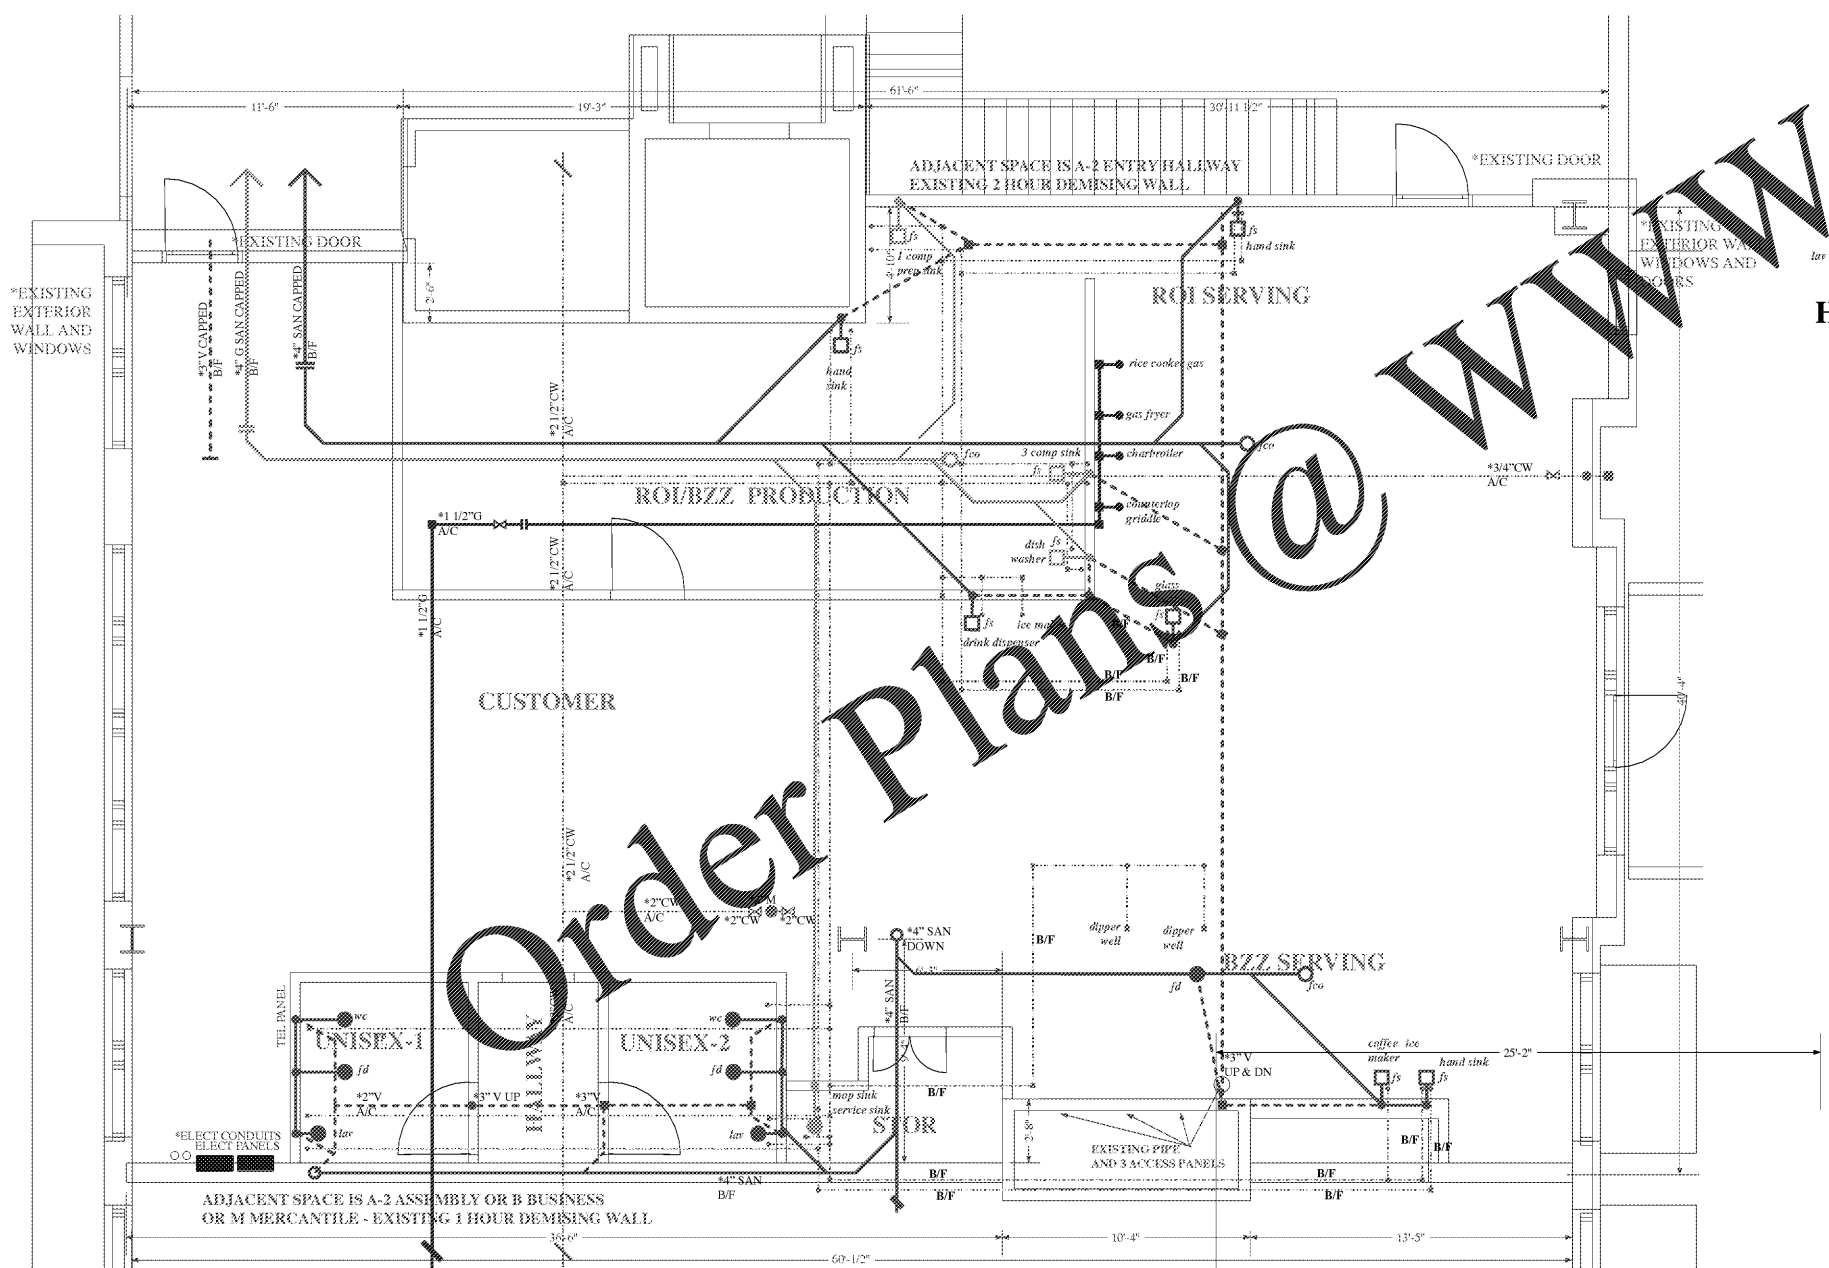
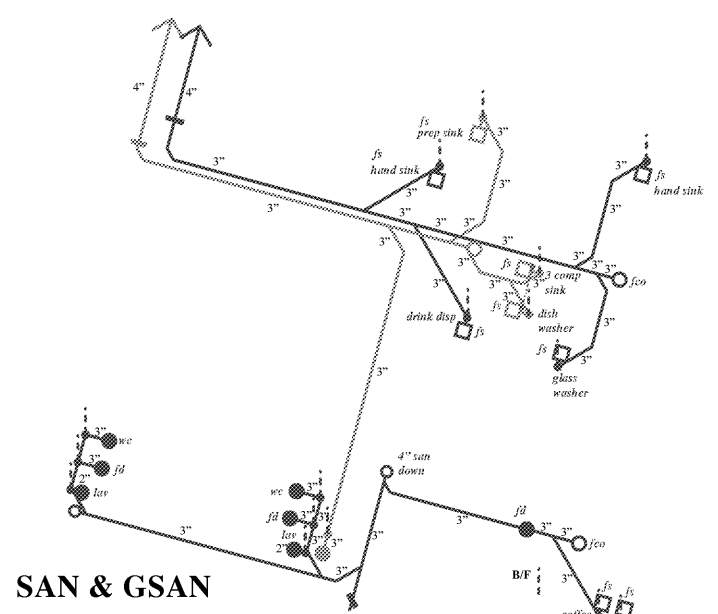
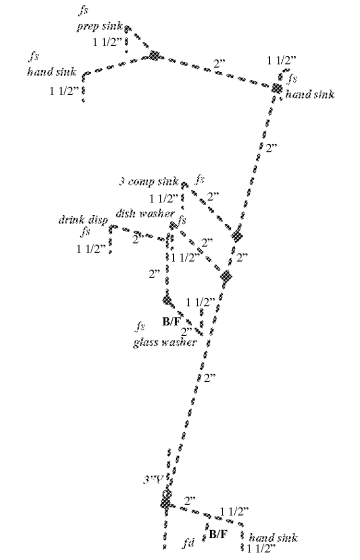
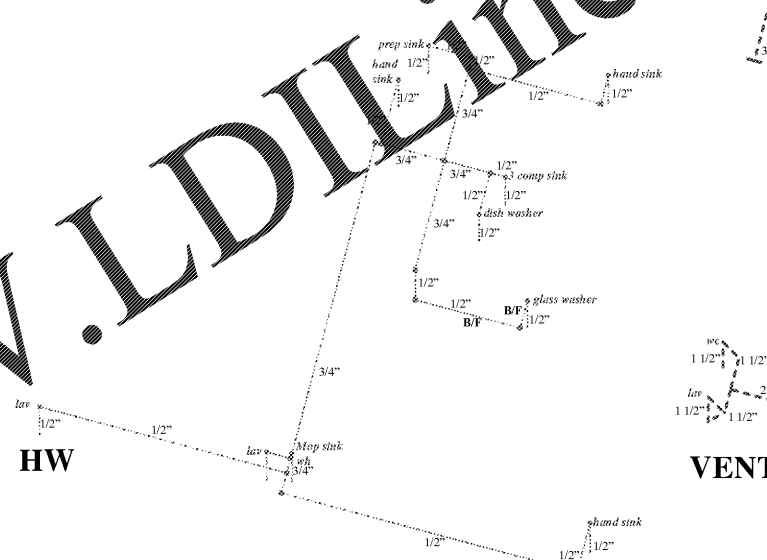
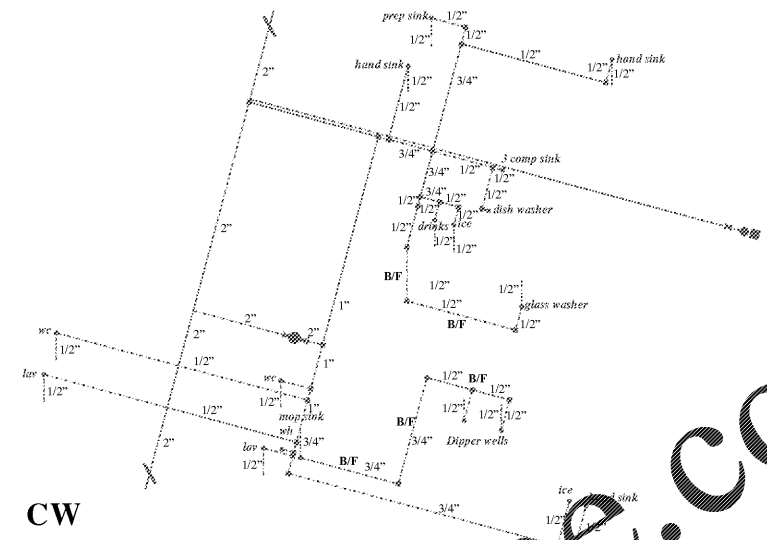


**SAMPLE
PROTOTYPE
ADAPTATION**

roibzzPROTO - Roll-On-In / Buzzed Bull Creamery
Combo SAMPLE PROTOTYPE ADAPTATION
12FEB2021

**PRELIMINARY
NOT FOR FINAL
CONSTRUCTION**

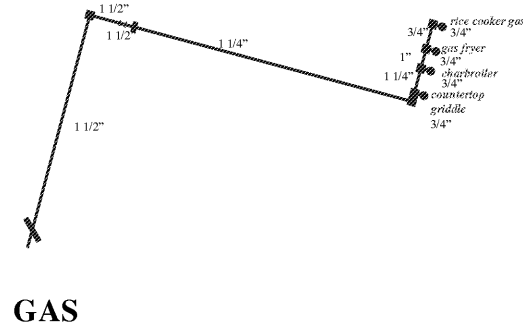

FLOOR PLAN WATER, SEWER & GAS PLAN

WWW.LDILINE.COM

Order Plans @

**SEE AE-0200 & 0201 FOR
ADDITIONAL NOTES
AND DETAILS**

**ABBREVIATIONS
A/C = ABOVE CEILING
B/F = BELOW FLOOR**

INDICATES EXISTING
PLAN TRUE
2423 SF
SCALE 1/4" = 1'-0"
AE-0202
P-3
WATER, SEWER & GAS RISER DIAGRAMS