


- CEILING NOTES:**
1. CONTRACTOR SHALL CLEAN ALL DUST AND DIRT FROM ROOF DECK, BEAMS AND JOIST, MECHANICAL EQUIPMENT, CONDUIT AND WIRES. TOUCH UP WHITE PAINT AS REQUIRED.
 2. SEE DETAIL 1/A2 FOR LIGHT MOUNTING.
 3. MOUNT NEW LIGHTS AT EXISTING LIGHT FIXTURE HEIGHT IN SALES AREA.
 4. LIGHT FIXTURES AND POWER POLES (UON) ARE TENANT SUPPLIED / CONTRACTOR INSTALLED.

REFLECTED CEILING LEGEND

| | |
|--|--|
| | EXIST GWB - PAINT WHITE UNLESS OTHERWISE NOTED. |
| | 4'-0" STRIP LED LIGHT FIXTURE. REFER TO SHEET E-300 FOR ADDITIONAL INFO. MOUNT PER DETAIL 1/A2. |
| | EXIST 4'-0" STRIP LED LIGHT FIXTURE TO REMAIN. REFER TO SHEET E-300 FOR ADDITIONAL INFO. |
| | EXIST 4'-0" STRIP LED EMERGENCY LIGHT FIXTURE TO REMAIN. REFER TO SHEET E-300 FOR ADDITIONAL INFO. |
| | EXIST 2'-0"x4'-0" LED LIGHT FIXTURE TO REMAIN. REFER TO SHEET E-300 FOR ADDITIONAL INFO. |
| | EXIST 2'-0"x4'-0" LED EMERGENCY LIGHT FIXTURE TO REMAIN. REFER TO SHEET E-300 FOR ADDITIONAL INFO. |
| | EXIT LIGHT |
| | CEILING HEIGHT ABOVE FINISH FLOOR |
| | POWER POLE |

REFLECTED CEILING PLAN
SCALE: 1/8" = 1'-0"

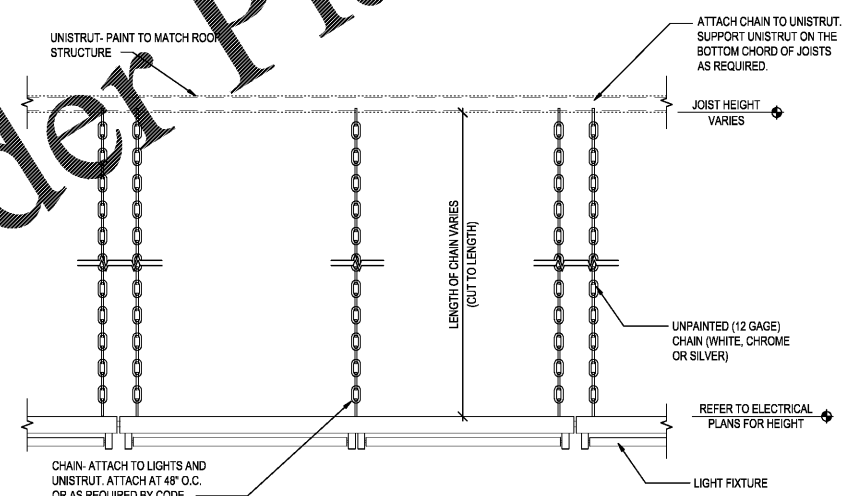

1 LIGHT MOUNTING DETAIL "OPEN CEILING"
SCALE: NTS

| mark | date | revisions |
|------|------|-----------|
| | | |
| | | |
| | | |
| | | |

| date | project | designed | drawn | checked | DW |
|------|---------|----------|-------|---------|----|
| | | | | | |



RRRM ARCHITECTS, PC
Robert S. Berz, Jr., Architect
Duane M. Harver, Architect

1317 Executive Blvd., Suite 200
Chesapeake, VA 23320
(757) 522-2528 Fax (757) 522-6882



FORMER WALGREENS, FDS #197103
COCHRAN, GA
REFLECTED CEILING PLAN, DETAIL AND LEGEND

project
drawing

sheet
A2