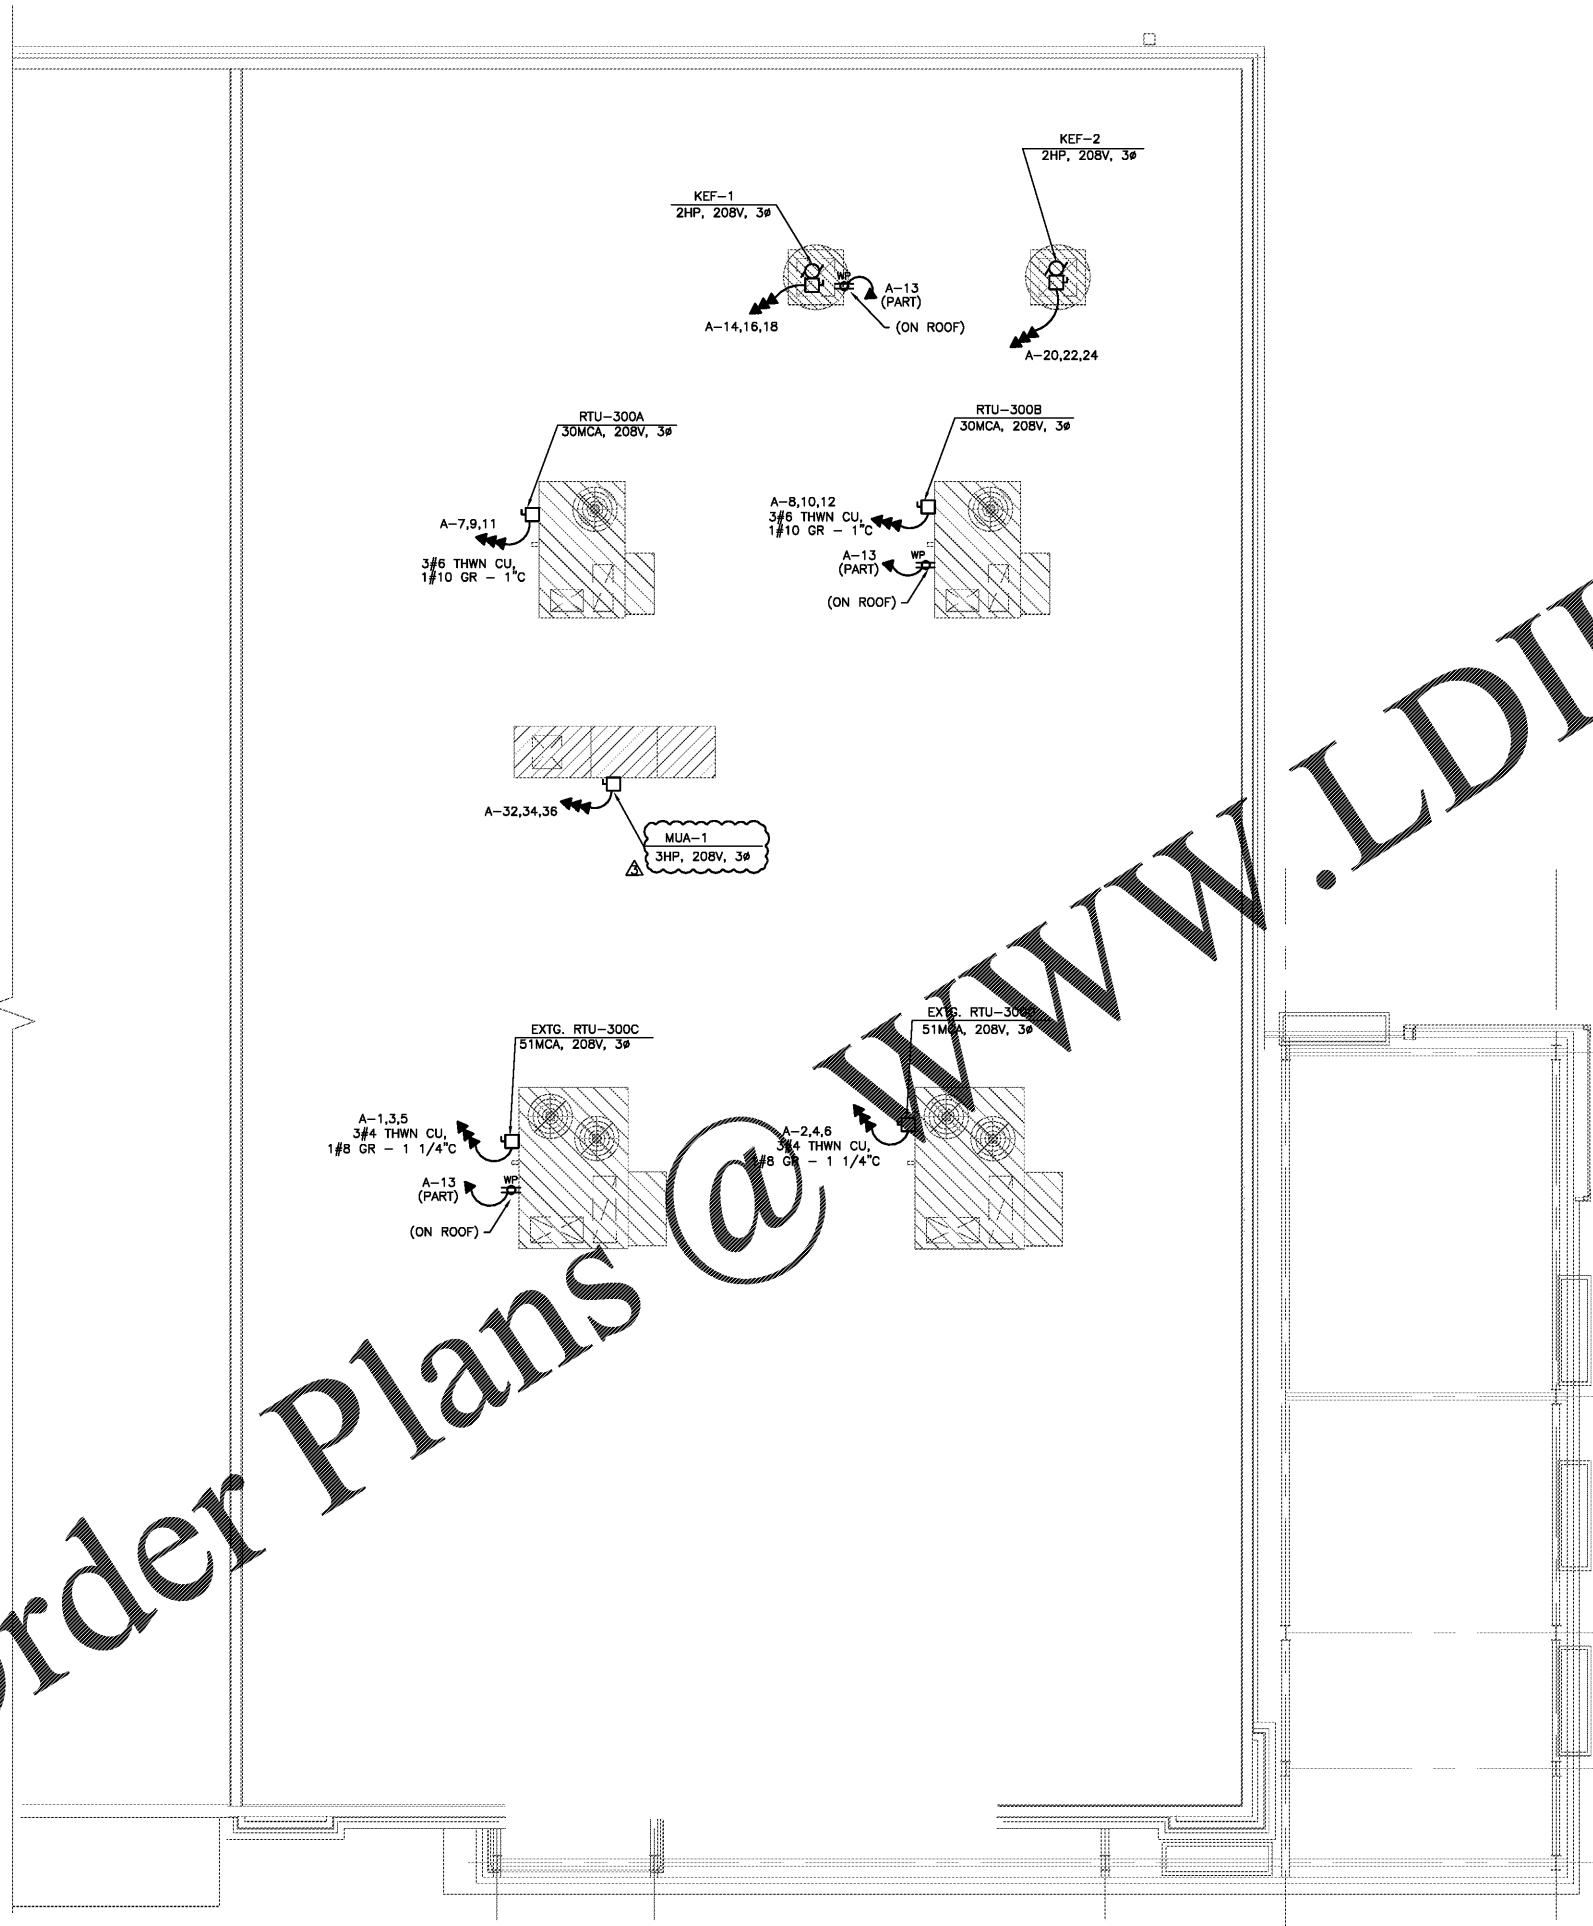
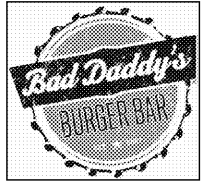
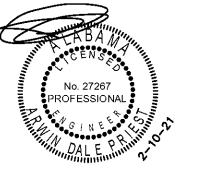


Order Plans @ [www.LDILine.com](http://www.LDILine.com)



**ROOF ELECTRICAL PLAN**  
1/4"=1'-0"

CONSULTANT:  
**ARWIN PRIEST P.E., P.Eng.**  
 MECHANICAL ENGINEER ELECTRICAL ENGINEER  
 242 Mountain Cloud Circle  
 Highlands Ranch, Colorado 80126  
 Email: [arwin@edenver.com](mailto:arwin@edenver.com)  
 Ph: (303) 898-2884  
HEREBY CERTIFY THAT THESE DOCUMENTS  
 WERE PREPARED OR APPROVED BY ME, AND  
 THAT I AM A DULY LICENSED PROFESSIONAL  
 ENGINEER UNDER THE LAWS OF THE STATE  
 OF MARYLAND, LICENSE NO. 25013, EXPIRATION  
 10-24-21



**GOOD TIMES RESTAURANTS, INC.**  
 141 Union Blvd, Suite 400  
 Lakewood, CO 80226  
 303-384-1430

**BAD DADDY'S BURGER BAR**  
 "EASTCHASE"  
 MONTGOMERY, AL 36117

Issue Record:

4.23.2019	FOR PLAN REVIEW
05.06.2019	WALK-IN BOX
07.01.2019	CANOPY REVS
02.10.2020	TO GO REVS

Revisions:

 

Drawn:  
 DRAWN BY: VR

Checked:  
 CHECKED BY: WR

Project No.  
 PROJECT#: 19-207

Contractor:

ROOF  
 ELECTRICAL  
 PLAN



Date of Last Print:  
 02.10.2020