


Order Plans @ WWW.LDILine.com

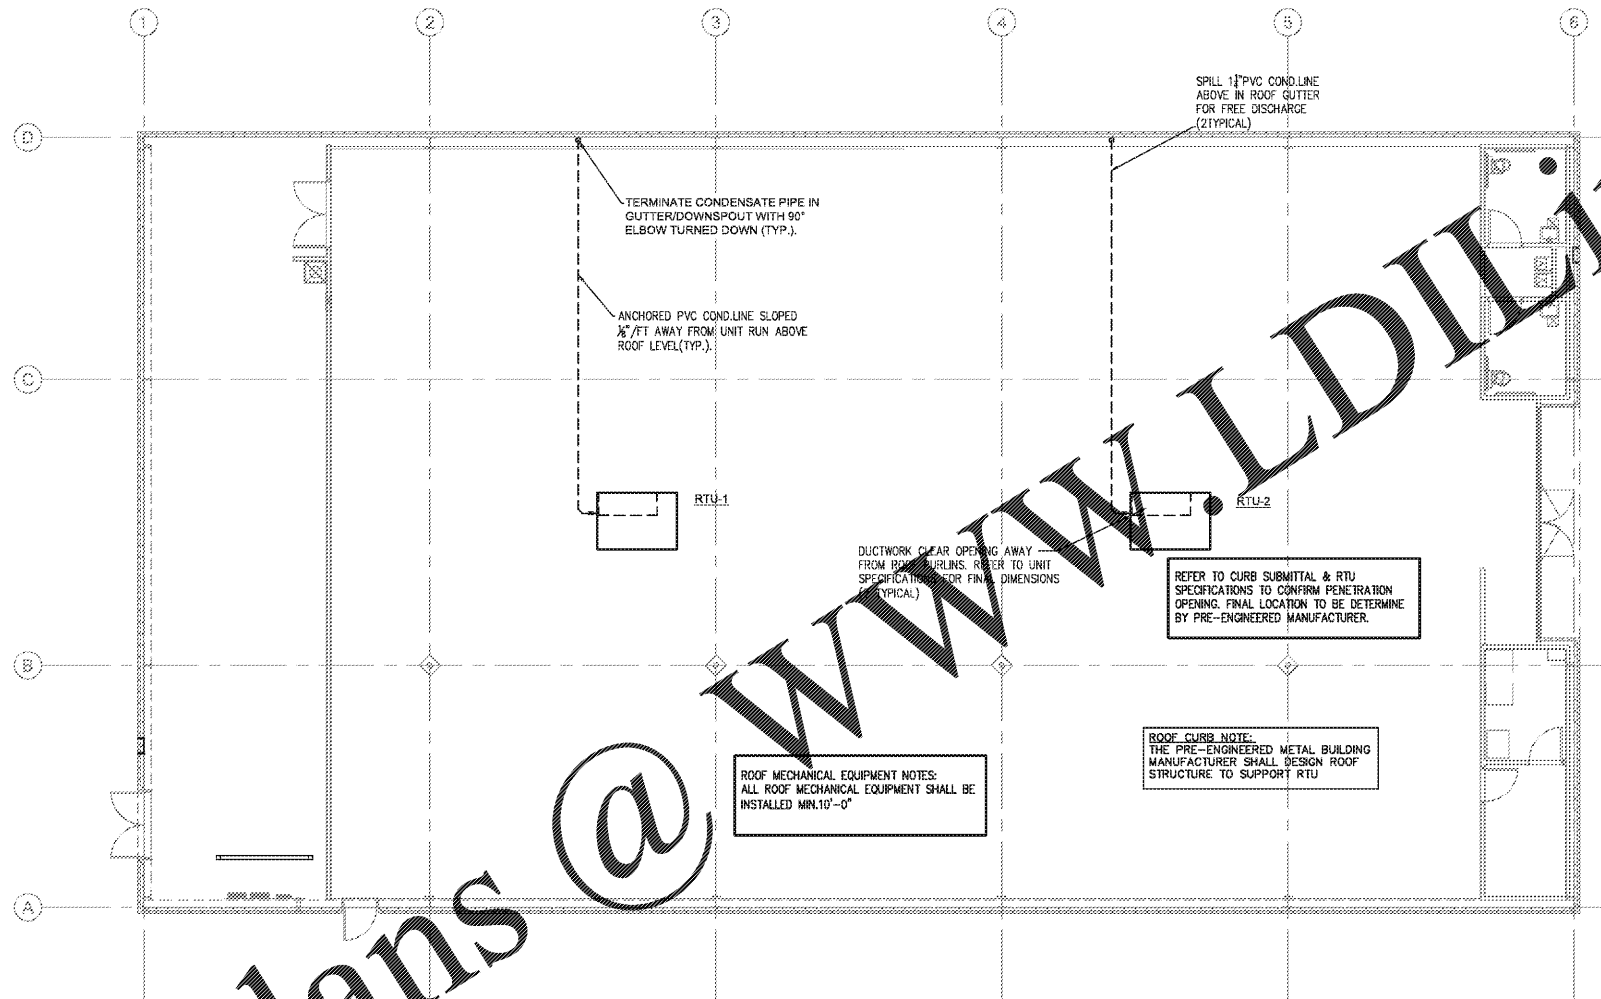

1 HVAC ROOF PLAN
M3.0 SCALE: 1/8" = 1'-0"

Robert E. Walker, IV
Architect

2229 FIRST AVE. SOUTH
SUITE 110
BIRMINGHAM, Alabama
35233
T-205.254.3212
F-205.254.3269

ROBERT M. BEATTIE, PE

2875 SHELBY CREEK CIRCLE - GUNDSVILLE, AL 35756
PHYSICIAN: 205.254.3212 • ARCHITECT: 205.254.3212
WEBSITE: WWW.RMBEATTIE.COM • EMAIL: RMBEATTIE@GMAIL.COM
STRUCTURAL DEPT.: 205.254.3212 • CIVIL: 205.254.3212
ELECTRICAL DEPT.: 205.254.3212 • MECHANICAL: 205.254.3212
PLUMBING DEPT.: 205.254.3212 • SPECIALTY: 205.254.3212

ROBERT M. BEATTIE, PE

ROBERT M. BEATTIE, PE - MEMBER ENGINEER'S BOARD OF ALABAMA
LICENSED PROFESSIONAL ENGINEER - MECHANICAL
LICENSE NO. 28995
EXPIRES 12/31/2021
ALL RIGHTS RESERVED. THIS DOCUMENT IS THE PROPERTY OF RMBEATTIE.COM. NO PART OF THIS DOCUMENT MAY BE REPRODUCED OR TRANSMITTED IN ANY FORM OR BY ANY MEANS, ELECTRONIC OR MECHANICAL, WITHOUT PERMISSION IN WRITING FROM RMBEATTIE.COM.



1-14-21



DOLLAR GENERAL
BUILDING
Prototype 9100 SF B
Store # 22718

DG Woodstock
Bells Ferry Rd.
Woodstock, GA

CONSTRUCTION
DOCUMENTS

PROJECT NO.: 8095.97
ISSUED: 01/15/2021

HVAC
ROOF PLAN

M3.0

DISCLAIMER: THESE DOCUMENTS WERE BASED ON THE STANDARD PROTOTYPE DRAWING PROVIDED TO US BY DOLLAR GENERAL THROUGH THEIR OWNERS REPRESENTATIVE. THE GENERAL CONTRACTOR SHALL BE RESPONSIBLE FOR FIELD VERIFYING ALL EXISTING CONDITIONS PRIOR TO CONSTRUCTION WITH ANY SITE WORK, MATERIALS, FOUNDATIONS, BUILDING FABRICATION, ETC. ANY DISCREPANCIES BETWEEN THESE DOCUMENTS AND ACTUAL FIELD CONDITIONS SHALL BE BROUGHT TO THE ATTENTION OF THE ARCHITECT PRIOR TO ANY WORK BEING DONE. ANY REQUIRED ENGINEERING CHANGES TO MATCH THE EXISTING SITE CONDITIONS SHALL BE TREATED AS ADDITIONAL SERVICES.