

SHEET NOTES

1. GENERAL CONTRACTOR SHALL COORDINATE ALL WORK WITH WALMART CONSTRUCTION MANAGER.
2. NOT USED.
3. NOT USED.
4. REF N1 FOR FINISH KEY.

SGA Design Group, P.C.
1437 South Boulder, Suite 550
Tulsa, Oklahoma 74116
T 918.587.8800
F 918.587.8901
www.sgadesigngroup.com

STIPULATION FOR REUSE
THIS DRAWING IS THE PROPERTY OF SGA DESIGN GROUP AND IS NOT TO BE REPRODUCED OR TRANSMITTED IN ANY FORM OR BY ANY MEANS, ELECTRONIC OR MECHANICAL, WITHOUT THE WRITTEN PERMISSION OF SGA DESIGN GROUP. ANY REUSE OF THIS DRAWING FOR ANY PROJECT OR IN ANY MANNER WITHOUT THE WRITTEN PERMISSION OF SGA DESIGN GROUP SHALL BE CONSIDERED A VIOLATION OF THE TERMS OF THE AGREEMENT BETWEEN THE PARTIES.

CONSULTANTS

Walmart
PRATTVILLE, AL
1903 COBBS FORD RD
STORE NO. 0463-249
2084988 | PHOTO
2021 MAJOR PROJECT

ISSUE BLOCK

NO.	DATE	DESCRIPTION

CHECKED BY: T/RO/AMVT
DRAWN BY: AR
PROTO CYCLE: 01/29/21
DOCUMENT DATE: 03/11/21


THE RECORD COPY OF THIS DRAWING IS ON FILE AT THE OFFICES OF SGA DESIGN GROUP. THIS ELECTRONIC DOCUMENT IS RELEASED FOR THE PURPOSE OF REFERENCE, COORDINATION, AND/OR FACILITY MANAGEMENT. THIS DRAWING SHALL NOT BE CONSIDERED FINAL OR COMPLETE UNLESS IT IS SIGNED AND SEALED BY THE ARCHITECT.

STATE OF ALABAMA
ARIANE V. TATTERSHALL
2016
Ariane Tattershall
03/31/2021


AUTO CENTER PLANS AND DETAILS
SHEET: AC1

Order Plans @ www.LDILine.com

2 AUTOMOTIVE ELEVATION
1/4" = 1'-0"

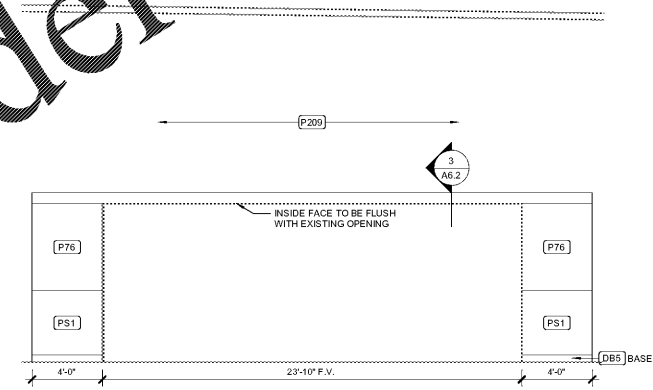

1 ENLARGED AUTO CENTER PLAN
1/8" = 1'-0"

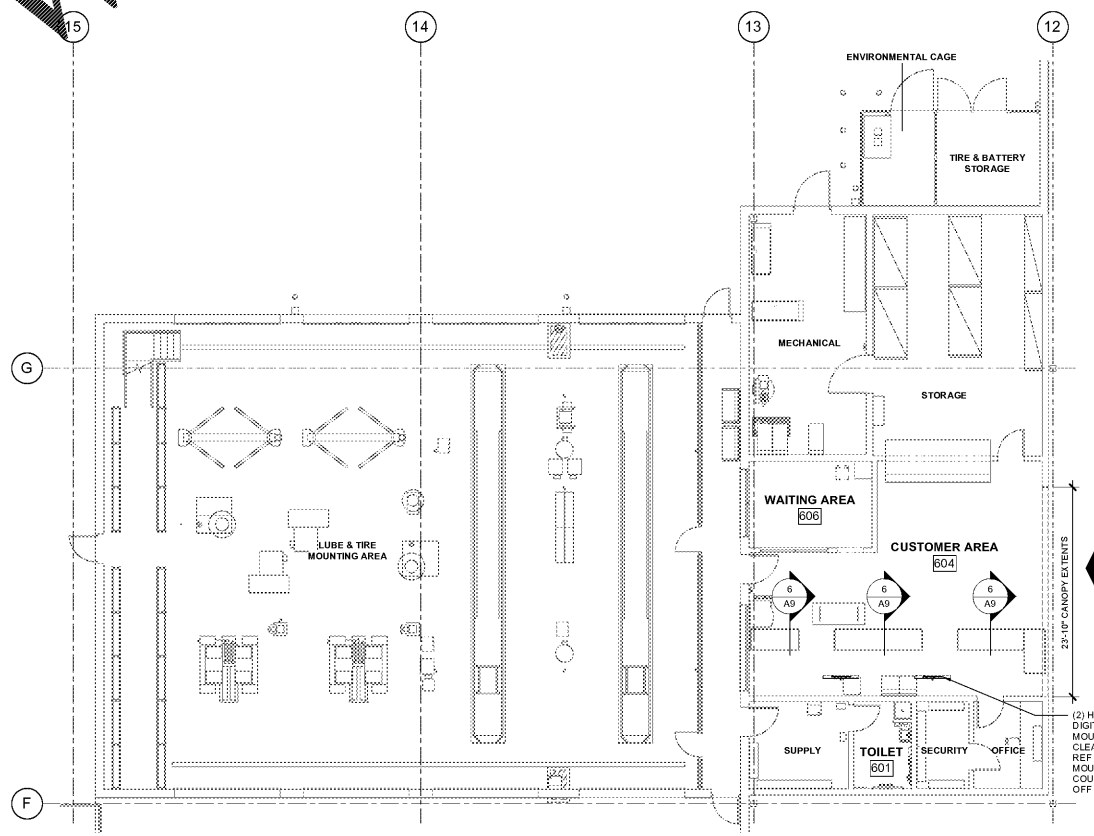

NOTE:
NO CONSTRUCTION WORK SHALL INTERFERE WITH THE NORMAL OPERATION OF THE AUTO CENTER.

601 TOILET
FINISHES
• ALL FINISHES ARE EXISTING TO REMAIN, EXCEPT AS NOTED BELOW.
• CLEAN FLOOR, WALL FINISH, CEILING, PLUMBING FIXTURES, TOILET ACCESSORIES, AND HARDWARE TO LIKE-NEW CONDITION, REF SPEC 01740. COORDINATE WITH STORE MANAGEMENT FOR SIGN-OFF AFTER RESTROOMS HAVE BEEN CLEANED.

604 CUSTOMER SERVICE, 606 WAITING AREA
WALLS
• GYP BD: PAINT WALLS P209 TO CEILING OR EXPOSED STRUCTURE. USE PS7 WAINSCOT AND DBS BASE.
• CRU: PAINT P209 TO CEILING ON EXPOSED STRUCTURE. DIAMOND PLATE WAINSCOT: ETR. PAINT P209 ABOVE WAINSCOT.
• PAINT ALL HOLLOW METAL DOORS AND FRAMES P162.

FLOOR
• REF SHEET SA1.1 FOR FLOOR FINISH PLAN.
CEILING
• REF SHEET SA1 FOR CEILING SCHEDULE.

MILLWORK
• RE-LAMINATE FRONT FACE AND SIDE FACES OF EXISTING CASEWORK. INSTALL NEW WALL GUARD, INFILL TOE KICK AND INSTALL NEW BASE.
• EXISTING SOLID SURFACE OR LAMINATE COUNTERTOP: REPLACE COUNTERTOP WITH NEW SS COUNTERTOP.

(2) HORIZONTALLY ORIENTED DIGITAL DISPLAYS POLE MOUNTED FROM ABOVE WITH 80" CLEAR TO BOTTOM OF SCREEN. REF 4-A0 MOUNT CENTERED BEHIND THE COUNTERS WITH A MINIMUM 2'-0" OFF WALL. REF ELECTRICAL.