



KEYNOTES

- 15.700 REMOVE AIR DEVICES AND DUCTWORK SHOWN DASHED UNLESS OTHERWISE NOTED AND CAP OFF DUCTWORK TO REMAIN. PATCH AND REPAIR DUCTWORK AS NEEDED INCLUDING SEALING DUCTWORK TO REMAIN PER SPECIFICATIONS. CONNECT TO EXISTING SUPPLY/RETURN DUCTWORK INDICATED.
- 15.705 REBALANCE AIR DEVICE TO CFM SHOWN. REDISTRIBUTE AIR FROM EXISTING DUCTWORK TO MATCH NEW CFM REQUIREMENTS. FIELD VERIFY LOCATION OF EXISTING DUCTWORK.

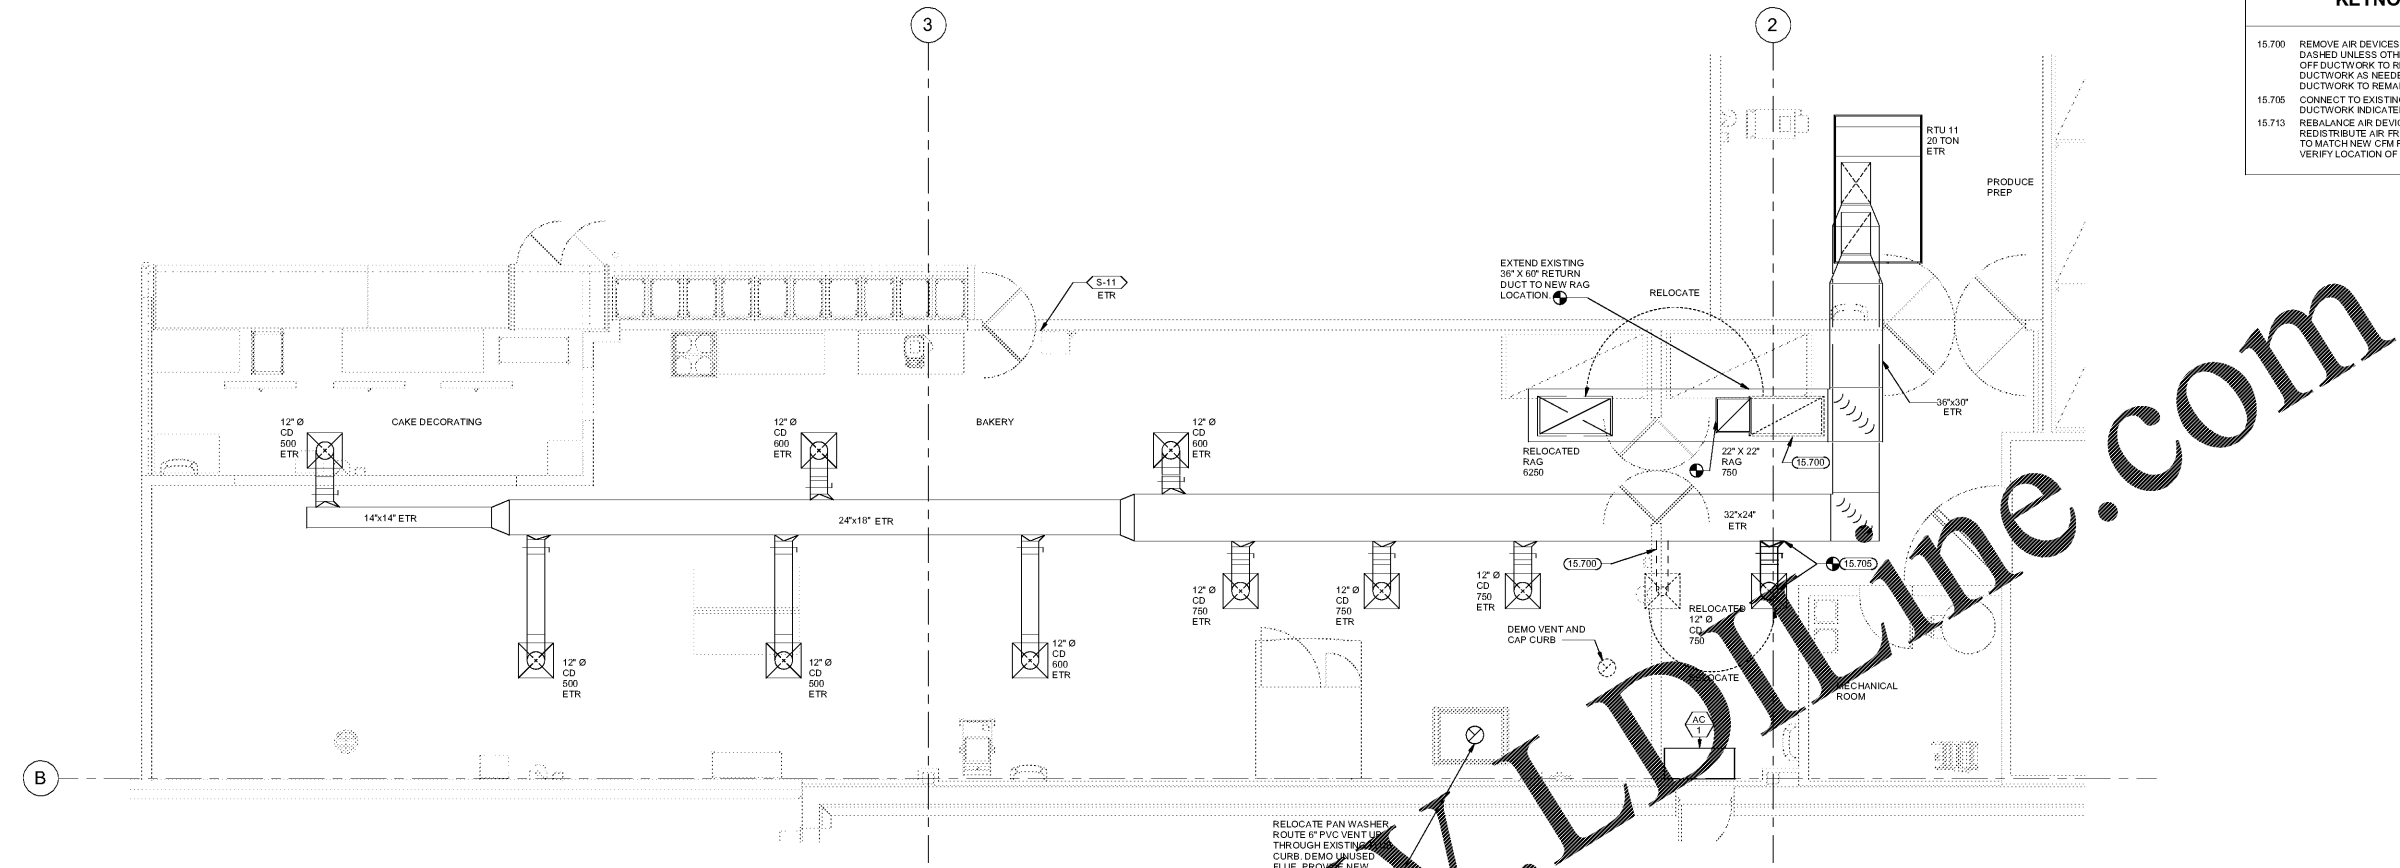

③ BAKERY MECHANICAL PLAN
1/4" = 1'-0"

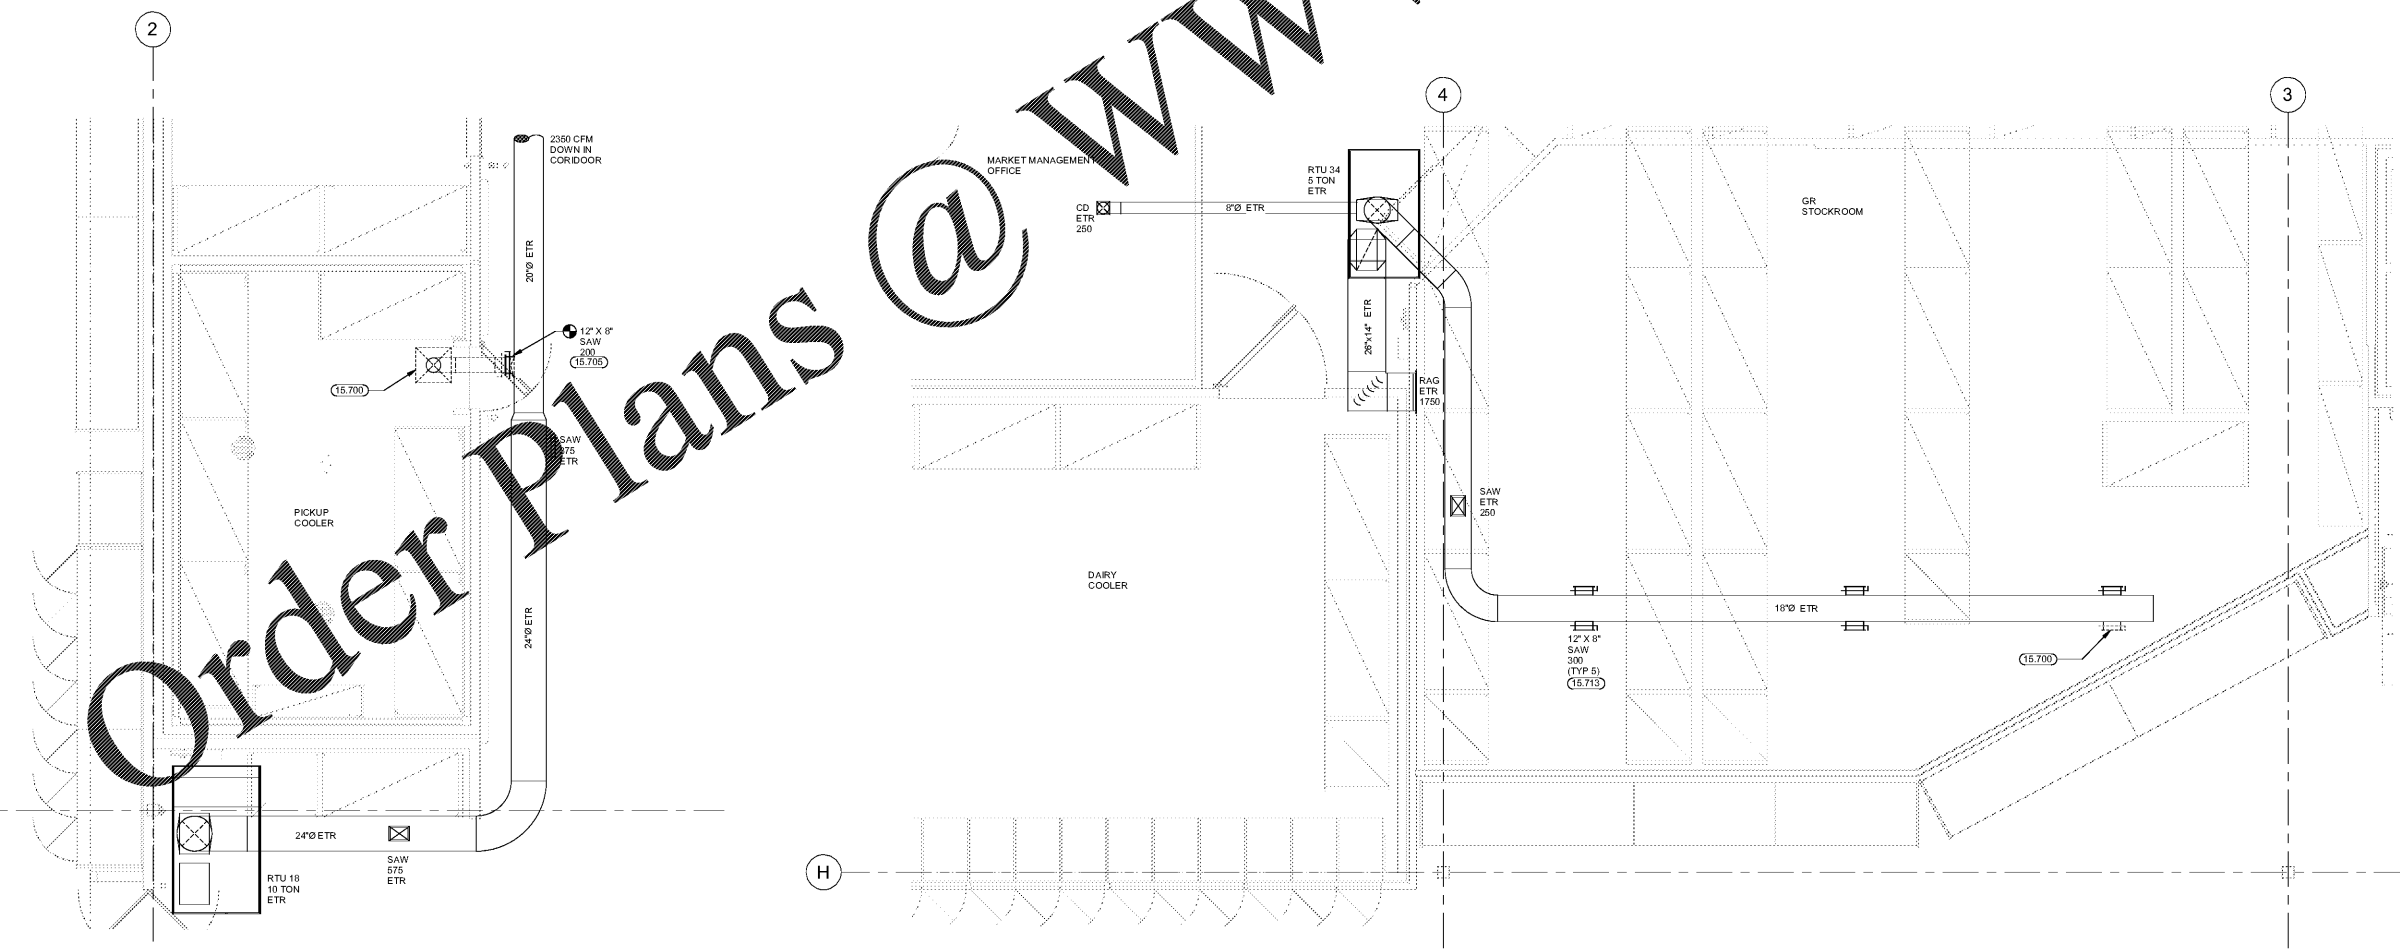

② OGP MECHANICAL PLAN
1/4" = 1'-0"

① REAR GROCERY MECHANICAL PLAN
1/4" = 1'-0"

STIPULATION FOR RIDGE
THIS DRAWING AND ALL INFORMATION CONTAINED HEREIN IS THE PROPERTY OF HENDERSON ENGINEERS AND IS TO BE USED ONLY FOR THE PROJECT AND SITE SPECIFICALLY IDENTIFIED HEREIN. IT IS TO BE KEPT IN CONFIDENCE AND NOT TO BE REPRODUCED, COPIED, OR TRANSMITTED IN ANY FORM OR BY ANY MEANS, ELECTRONIC OR MECHANICAL, INCLUDING PHOTOCOPYING, RECORDING, OR BY ANY INFORMATION STORAGE AND RETRIEVAL SYSTEM, WITHOUT THE WRITTEN PERMISSION OF HENDERSON ENGINEERS. THE USER OF THIS DRAWING SHALL BE RESPONSIBLE FOR VERIFYING ALL INFORMATION AND CONDITIONS SHOWN ON THIS DRAWING ARE ACCURATE AND CORRECT FOR THE PROJECT AND SITE SPECIFICALLY IDENTIFIED HEREIN. THE USER OF THIS DRAWING SHALL BE RESPONSIBLE FOR VERIFYING ALL INFORMATION AND CONDITIONS SHOWN ON THIS DRAWING ARE ACCURATE AND CORRECT FOR THE PROJECT AND SITE SPECIFICALLY IDENTIFIED HEREIN.

CONSULTANTS
HENDERSON ENGINEERS
6845 LEBLANCHE SUITE 00
PRATTVILLE, AL 37067
TEL 615.742.2500 FAX 615.742.2001
WWW.HENDERSONENGINEERS.COM
AL. CONTRACTOR LICENSE NO. CA2186
EXP. 08/31/2022

Walmart
PRATTVILLE, AL
1803 COBBS FORD ROAD
STORE NO. 0485-249
JOB NUMBER: 218000483 | PHOTO: 188

2021 MAJOR PROJECT

ISSUE BLOCK

NO.	DATE	DESCRIPTION

CHECKED BY: AI
DRAWN BY: TNJ
PROTO CYCLE: 01/29/21
DOCUMENT DATE: 03/31/21



03/30/2021
GROCERY MECHANICAL PLAN

SHEET: GM1

EXISTING CONDITIONS WERE TAKEN FROM ORIGINAL DRAWINGS AND MAY NOT REFLECT EXACT 'AS-BUILT' CONDITIONS. CONTRACTOR SHALL FIELD VERIFY ALL EXISTING CONDITIONS PRIOR TO SUBMITTING FINAL BIDS. CONTRACTOR SHALL CAREFULLY COORDINATE NEW WORK AND DEMOLITION WITH ALL OTHER DISCIPLINES AND EXISTING CONDITIONS.

EACH SUBCONTRACTOR IS RESPONSIBLE FOR HAVING A THOROUGH KNOWLEDGE OF ALL DRAWINGS AND SPECIFICATIONS IN THEIR RELATED FIELD. THE FAILURE TO ACQUAINT THEMSELVES WITH THIS KNOWLEDGE DOES NOT RELIEVE THE RESPONSIBILITY OF PERFORMING THE WORK PROPERLY. NO ADDITIONAL COMPENSATION SHALL BE ALLOWED BECAUSE OF CONDITIONS THAT OCCUR DUE TO FAILURE TO FAMILIARIZE WORKERS WITH THIS KNOWLEDGE.