



KEYNOTES


- 16.126 EXISTING LIGHT FIXTURE TO BE DEMOLISHED.
- 16.129 CONNECT TO EXISTING CIRCUIT PREVIOUSLY SERVING AREA LIGHTING THAT WAS REMOVED. MAINTAIN EXISTING CIRCUIT CONTROL UNLESS NOTED OTHERWISE. PROVIDE CONSTANT HOT FOR EMERGENCY EXIT AND LOCALLY CONTROLLED LIGHT FIXTURES.
- 16.131 CONNECT TO EXISTING CIRCUIT.

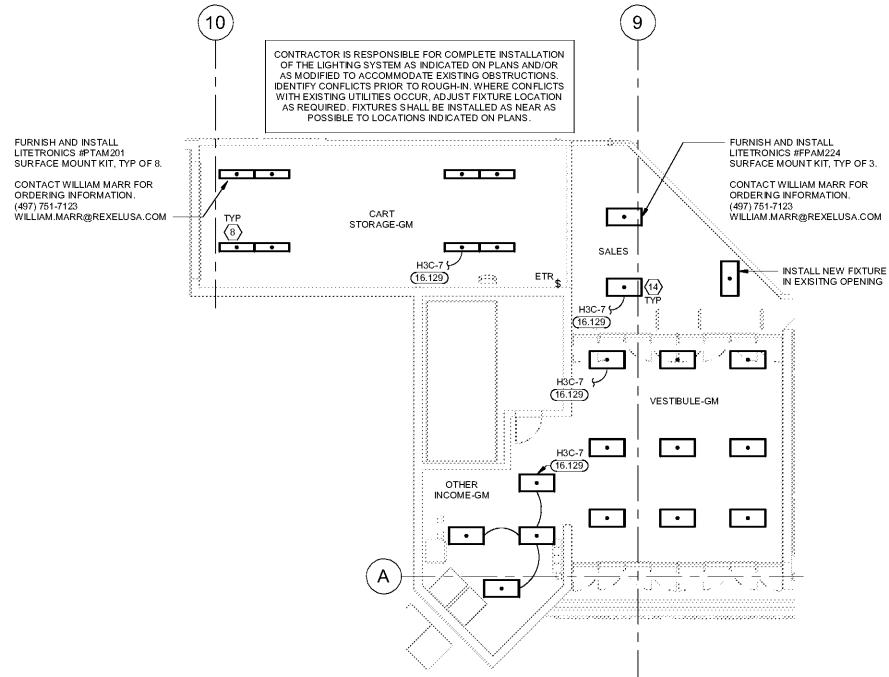


4 GM VESTIBULE LIGHTING PLAN
1/8" = 1'-0"

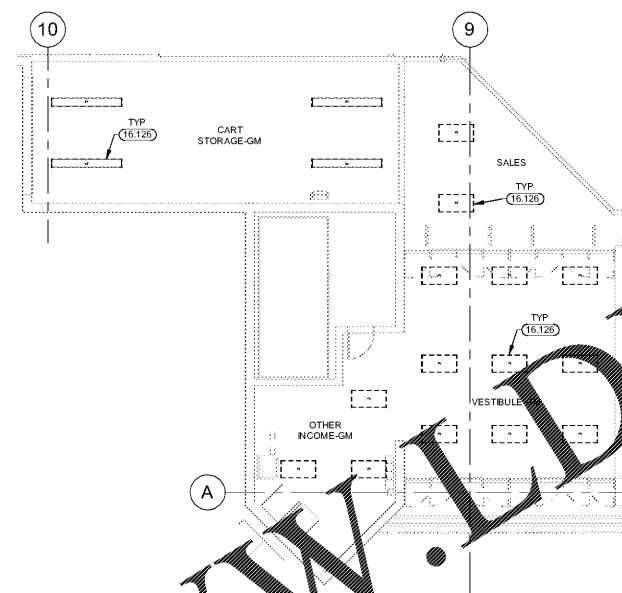

3 GM VESTIBULE LIGHTING DEMO PLAN

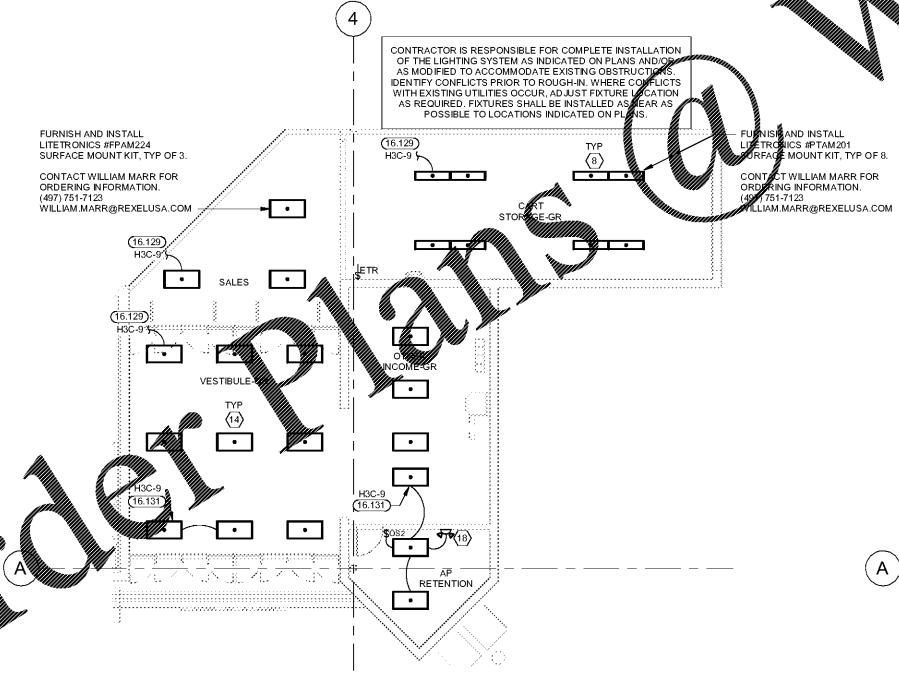

2 GR VESTIBULE LIGHTING PLAN
1/8" = 1'-0"

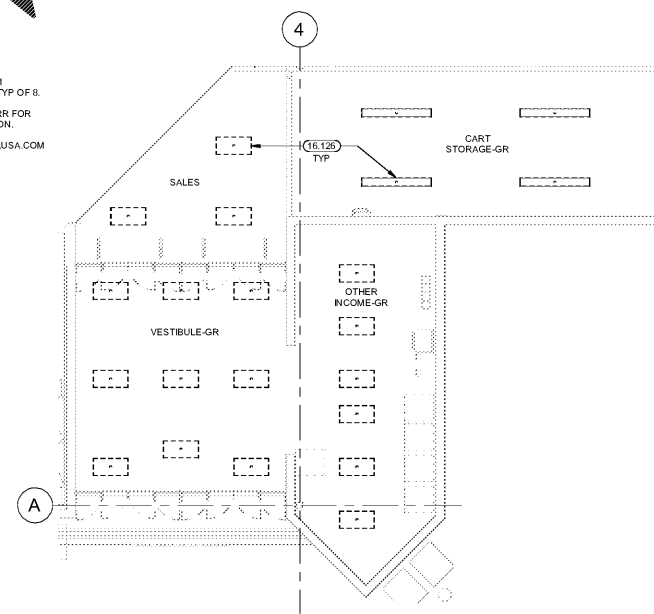

1 GR VESTIBULE LIGHTING DEMO PLAN
1/8" = 1'-0"

Order Plans @ WWW.LDILine.com

STIPULATION FOR REUSE
THIS DRAWING IS THE PROPERTY OF HENDERSON ENGINEERS. IT IS TO BE USED ONLY FOR THE PROJECT AND SITE SPECIFICALLY IDENTIFIED HEREON. IT IS NOT TO BE REPRODUCED, COPIED, OR TRANSMITTED IN ANY FORM OR BY ANY MEANS, ELECTRONIC OR MECHANICAL, INCLUDING PHOTOCOPYING, RECORDING, OR BY ANY INFORMATION STORAGE AND RETRIEVAL SYSTEM, WITHOUT THE WRITTEN PERMISSION OF HENDERSON ENGINEERS. ANY UNAUTHORIZED REUSE OF THIS DRAWING IS STRICTLY PROHIBITED AND WILL BE PROSECUTED TO THE FULL EXTENT OF THE LAW.

CONSULTANTS
HENDERSON ENGINEERS
6945 LEBLANCHE BLVD. SUITE 600
TEL: (313) 422-2000 FAX: (313) 422-2001
WWW.HENDERSONENGINEERS.COM
AL. CORP. REG. NO. 00485-249
EXPIRES 1/01/2022

Walmart
PRATTVILLE, AL
1803 COBBES FORD ROAD
STORE NO. 00485-249
JOB NUMBER: 218000485 | PHOTO:
2021 MAJOR PROJECT | 18B

ISSUE BLOCK	

CHECKED BY: MM
DRAWN BY: SBHDP
PROTO CYCLE: 01/29/21
DOCUMENT DATE: 03/31/21



03/30/2021
ENLARGED LIGHTING PLANS

EXISTING CONDITIONS WERE TAKEN FROM ORIGINAL DRAWINGS AND MAY NOT REFLECT EXACT "AS-BUILT" CONDITIONS. CONTRACTOR SHALL FIELD VERIFY ALL EXISTING CONDITIONS PRIOR TO SUBMITTING FINAL BIDS. CONTRACTOR SHALL CAREFULLY COORDINATE NEW WORK AND DEMOLITION WITH ALL OTHER DISCIPLINES AND EXISTING CONDITIONS.

EACH SUBCONTRACTOR IS RESPONSIBLE FOR HAVING A THOROUGH KNOWLEDGE OF ALL DRAWINGS AND SPECIFICATIONS IN THEIR RELATED FIELD. THE FAILURE TO ACQUAINT THEMSELVES WITH THIS KNOWLEDGE DOES NOT RELIEVE THE RESPONSIBILITY OF PERFORMING THE WORK PROPERLY. NO ADDITIONAL COMPENSATION SHALL BE ALLOWED BECAUSE OF CONDITIONS THAT OCCUR DUE TO FAILURE TO FAMILIARIZE WORKERS WITH THIS KNOWLEDGE.