

City of Asheville/ Parks & Recreation
**DR. WESLEY GRANT SR.
 CENTER EXPANSION**

285 LIVINGSTON STREET
 ASHEVILLE, NC 28801

DESIGNER
CLARK NEXSEN
 301 COLLEGE STREET, SUITE 300
 ASHEVILLE, NORTH CAROLINA 28801
 828.232.0608
 CLARK NEXSEN LICENSE NUMBER: C-1028

GENERAL NOTES

- REFER TO SHEET F-001 FOR FIRE PROTECTION LEGEND, ABBREVIATIONS, WATER FLOW DATA AND SPRINKLER SYSTEM INFORMATION.
- REFER TO SHEET F-002 FOR FIRE ALARM LEGEND, FIRE ALARM RISER DIAGRAM AND SEQUENCE OF OPERATIONS MATRIX.

KEY NOTES

- CONDUITS AND BACKBOXES FOR FIRE ALARM DEVICES TO BE CONCEALED WITHIN WALL AND ARE NOT TO BE LEFT EXPOSED.
- SPRINKLERS IN THE GYM ARE TO BE PROVIDED WITH GUARDS.
- SPRINKLER PIPES AND APPURTENANCES TO BE INSTALLED CLOSE TO STRUCTURE DUE TO EXPOSED TONGUE AND GROOVE CEILING IN THIS SPACE.
- CONNECT TO EXISTING SPRINKLER RISER. SEE PHOTO A5 ON SHEET F-001.
- PIPING TO NEW SPRINKLER SYSTEM ADDITION.
- MONITOR FLOW AND TAMPER SWITCH ON NEW SPRINKLER MAIN.
- SPRINKLER PIPING WITHIN EXISTING BLDG TO RUN WITHIN SOFFIT ABOVE CEILING. SEE ARCHITECTURAL PLANS FOR COORDINATION.
- SHUTDOWN HVLS FANS ON SPRINKLER WATER FLOW.
- DRY SIDEWALL SPRINKLER HEADS TO BE PROVIDED.



SUBMITTAL
 03.12.2021
CONSTRUCTION DOCUMENTS

REVISIONS


KEY PLAN

SHEET
FIRST FLOOR PLAN


FP101

DESIGN: AAR
 DRAWN: AAR
 REVIEW: RBA
 CN 7904-A

 GRAPHIC SCALE(S)



FIRST FLOOR PLAN
 1/8" = 1'-0"

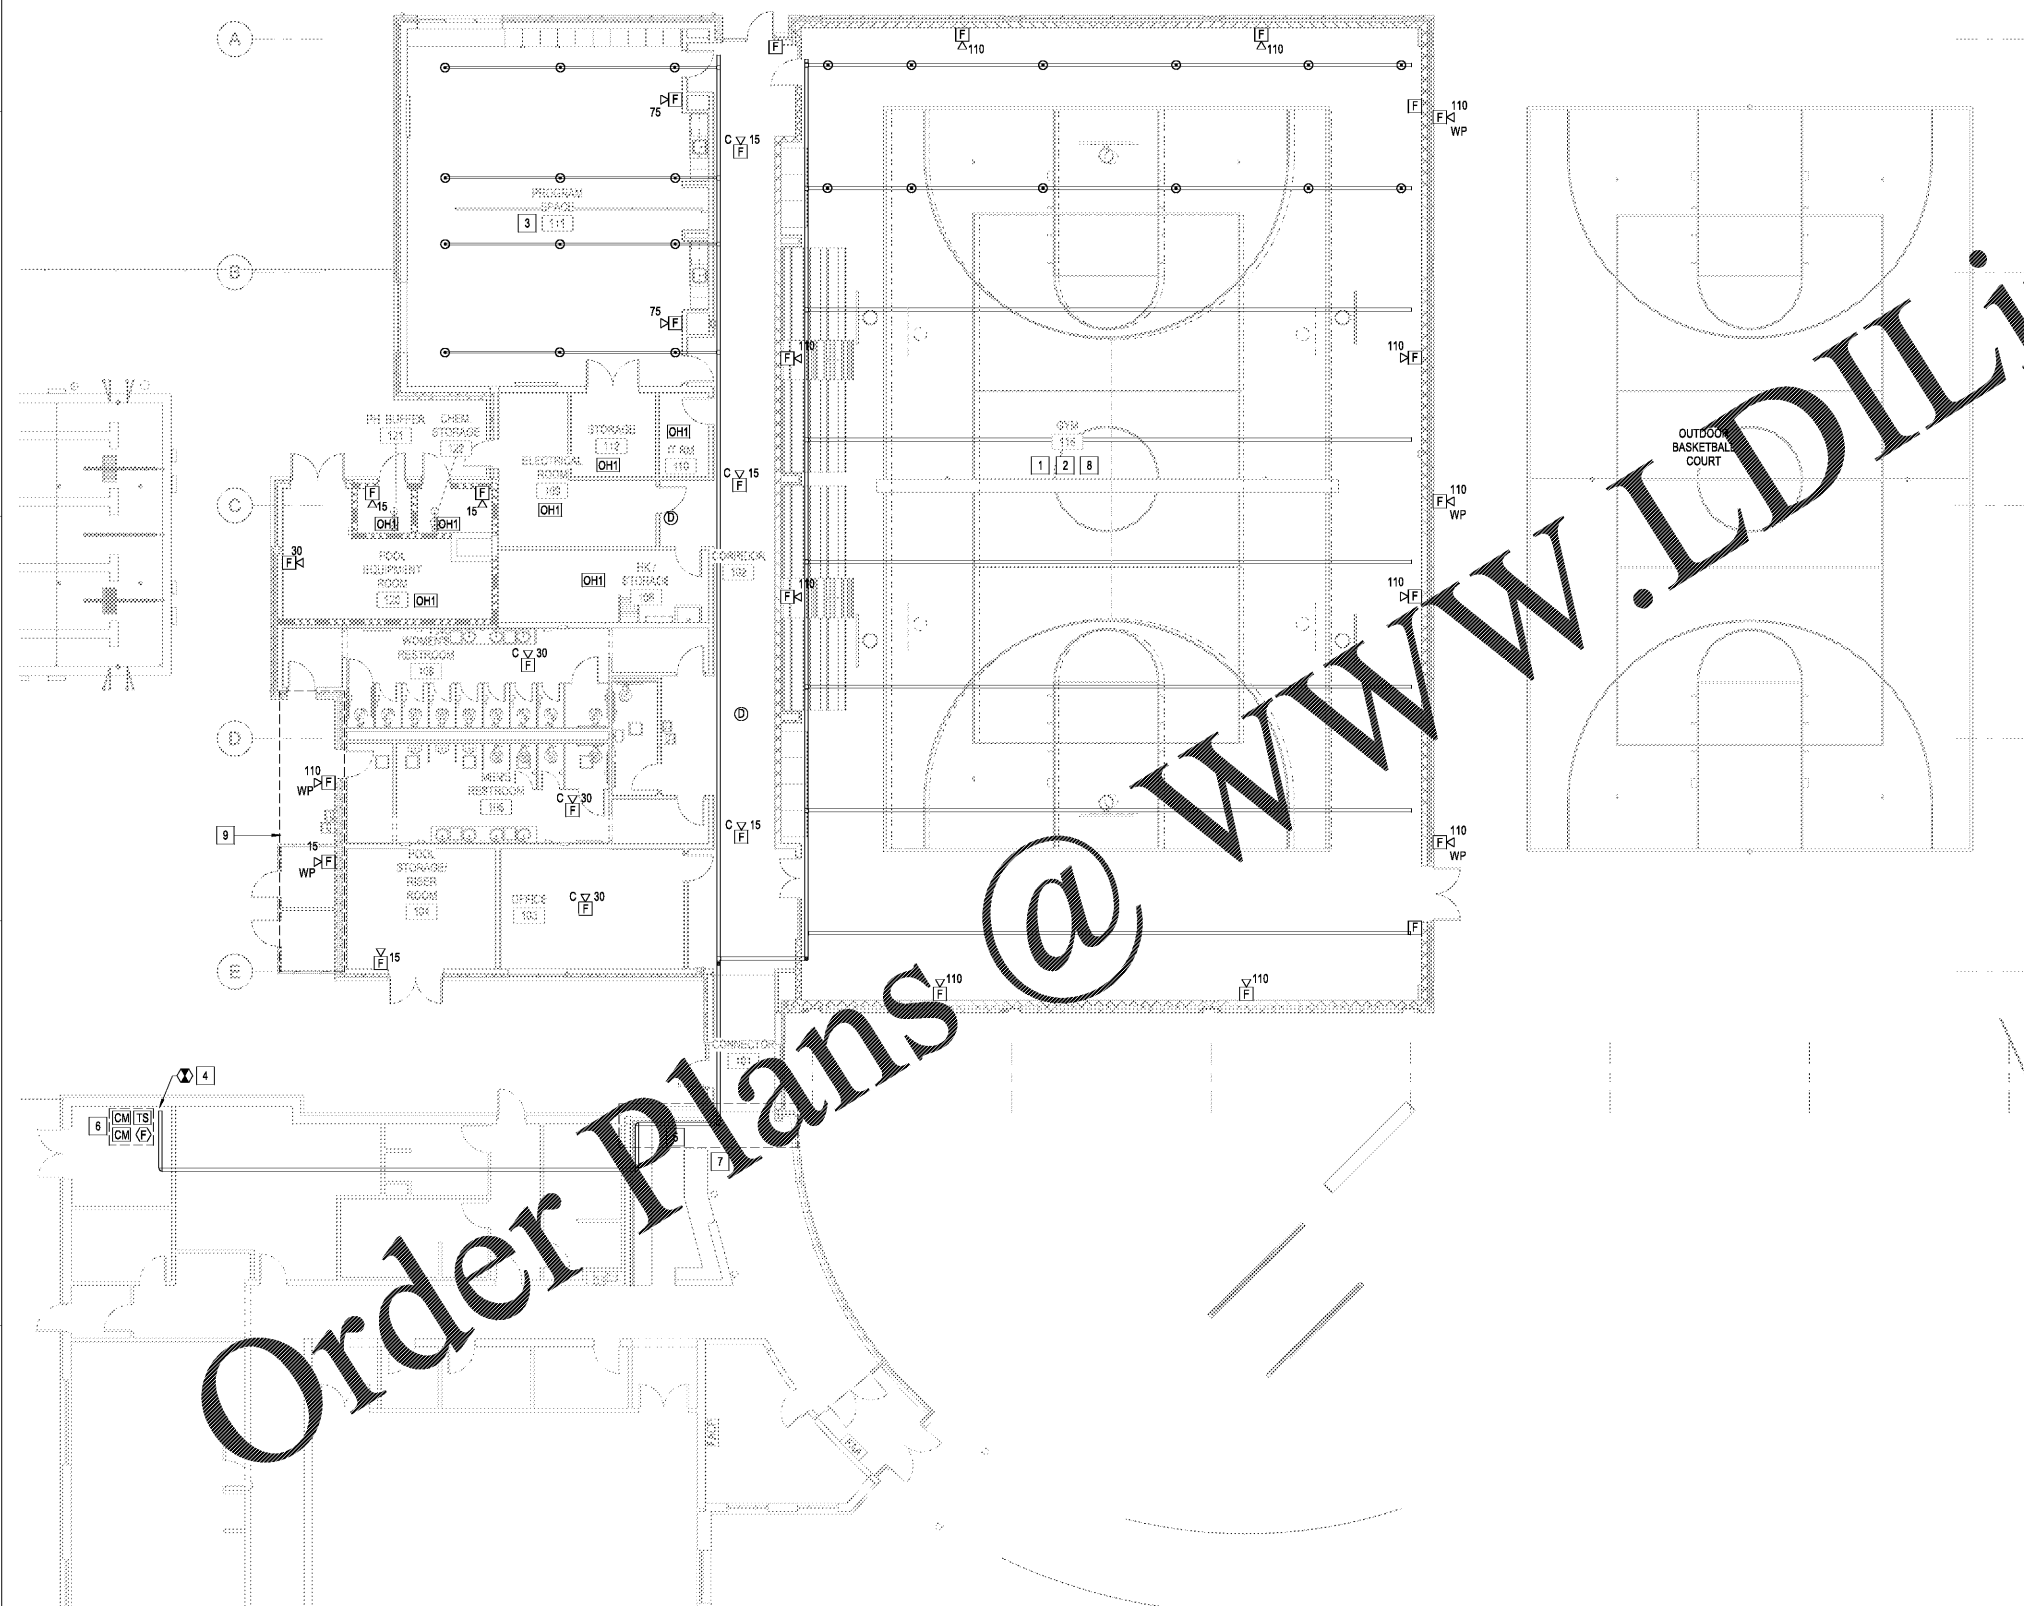

Order Plans @ www.LDILine.com

www.LDILine.com

C:\Users\alga\OneDrive\Documents\7904_Southside Facilities_F10_Archipa Revsheet@clarknksen.com.rvt
 3/11/2021 8:55:45 AM
 CLARK NEXSEN