

GENERAL NOTES

1. THESE DRAWINGS ARE DIAGRAMMATIC ONLY AND ARE NOT TO BE SCALED. FIELD VERIFY ALL DIMENSIONS, PIPE SIZES, AND INVERTS REFER TO ARCHITECTURAL SHEETS FOR DIMENSIONS AND LOCATIONS OF ALL PLUMBING FIXTURES AND EQUIPMENT.
2. ALL DOMESTIC COLD WATER SUPPLY PIPING, DOMESTIC HOT WATER SUPPLY PIPING, DOMESTIC HOT WATER RETURN PIPING, ROOF DRAIN BODIES, OVERFLOW ROOF DRAIN BODIES, 1" OF VERTICAL RAIN LEADER PIPING FROM DRAINS, AND ALL HORIZONTAL STORM WATER PIPING MUST BE INSULATED AND IDENTIFIED PER SPECIFICATIONS.
3. PROVIDE SLEEVES AND FIRE RATED ASSEMBLIES FOR ALL PENETRATIONS OF FIRE RATED FLOORS AND WALLS. REFER TO ARCHITECTURAL SHEETS FOR FIRE RATED ASSEMBLY DETAILS AND FIRE RATED FLOOR AND WALL DESIGNATIONS.

KEY NOTES

1. INSTALL WCO AT BASE OF WASTE STACKS WHERE INDICATED. SEE WALL CLEANOUT DETAIL AND PLUMBING SPECIALTIES SCHEDULE.
2. INSTALL VTR AT THIS LOCATION. COORDINATE WITH ROOFING CONTRACTOR FOR FLASHING REQUIREMENTS. VTR MUST BE 15' FROM ANY HVAC INTAKE LOUVERS. COORDINATE WITH HVAC CONTRACTOR FOR VTR EXACT LOCATION. OFFSET VTR TO LOCATION FOR ALL CODE REQUIREMENTS.

City of Asheville Parks & Recreation
DR. WESLEY GRANT
CENTER EXPANSION
 285 LIVINGSTON STREET
 ASHEVILLE, NC 28801

DESIGNER

CLARK NEXSEN
 333 FAYETTEVILLE STREET, SUITE 1000
 RALEIGH, NORTH CAROLINA 27601
 919-828-1876
 CLARK NEXSEN LICENSE NUMBER: C-1028

PROFESSIONAL SEAL



02/24/2021

SUBMITTAL
 03.12.2021
CONSTRUCTION DOCUMENTS

REVISIONS


KEY PLAN

SHEET
FIRST FLOOR PLAN - SANITARY AND VENT PIPING


PL102

DESIGN: DKB
 DRAWN: DLR
 REVIEW: WAW

CN 7904-A

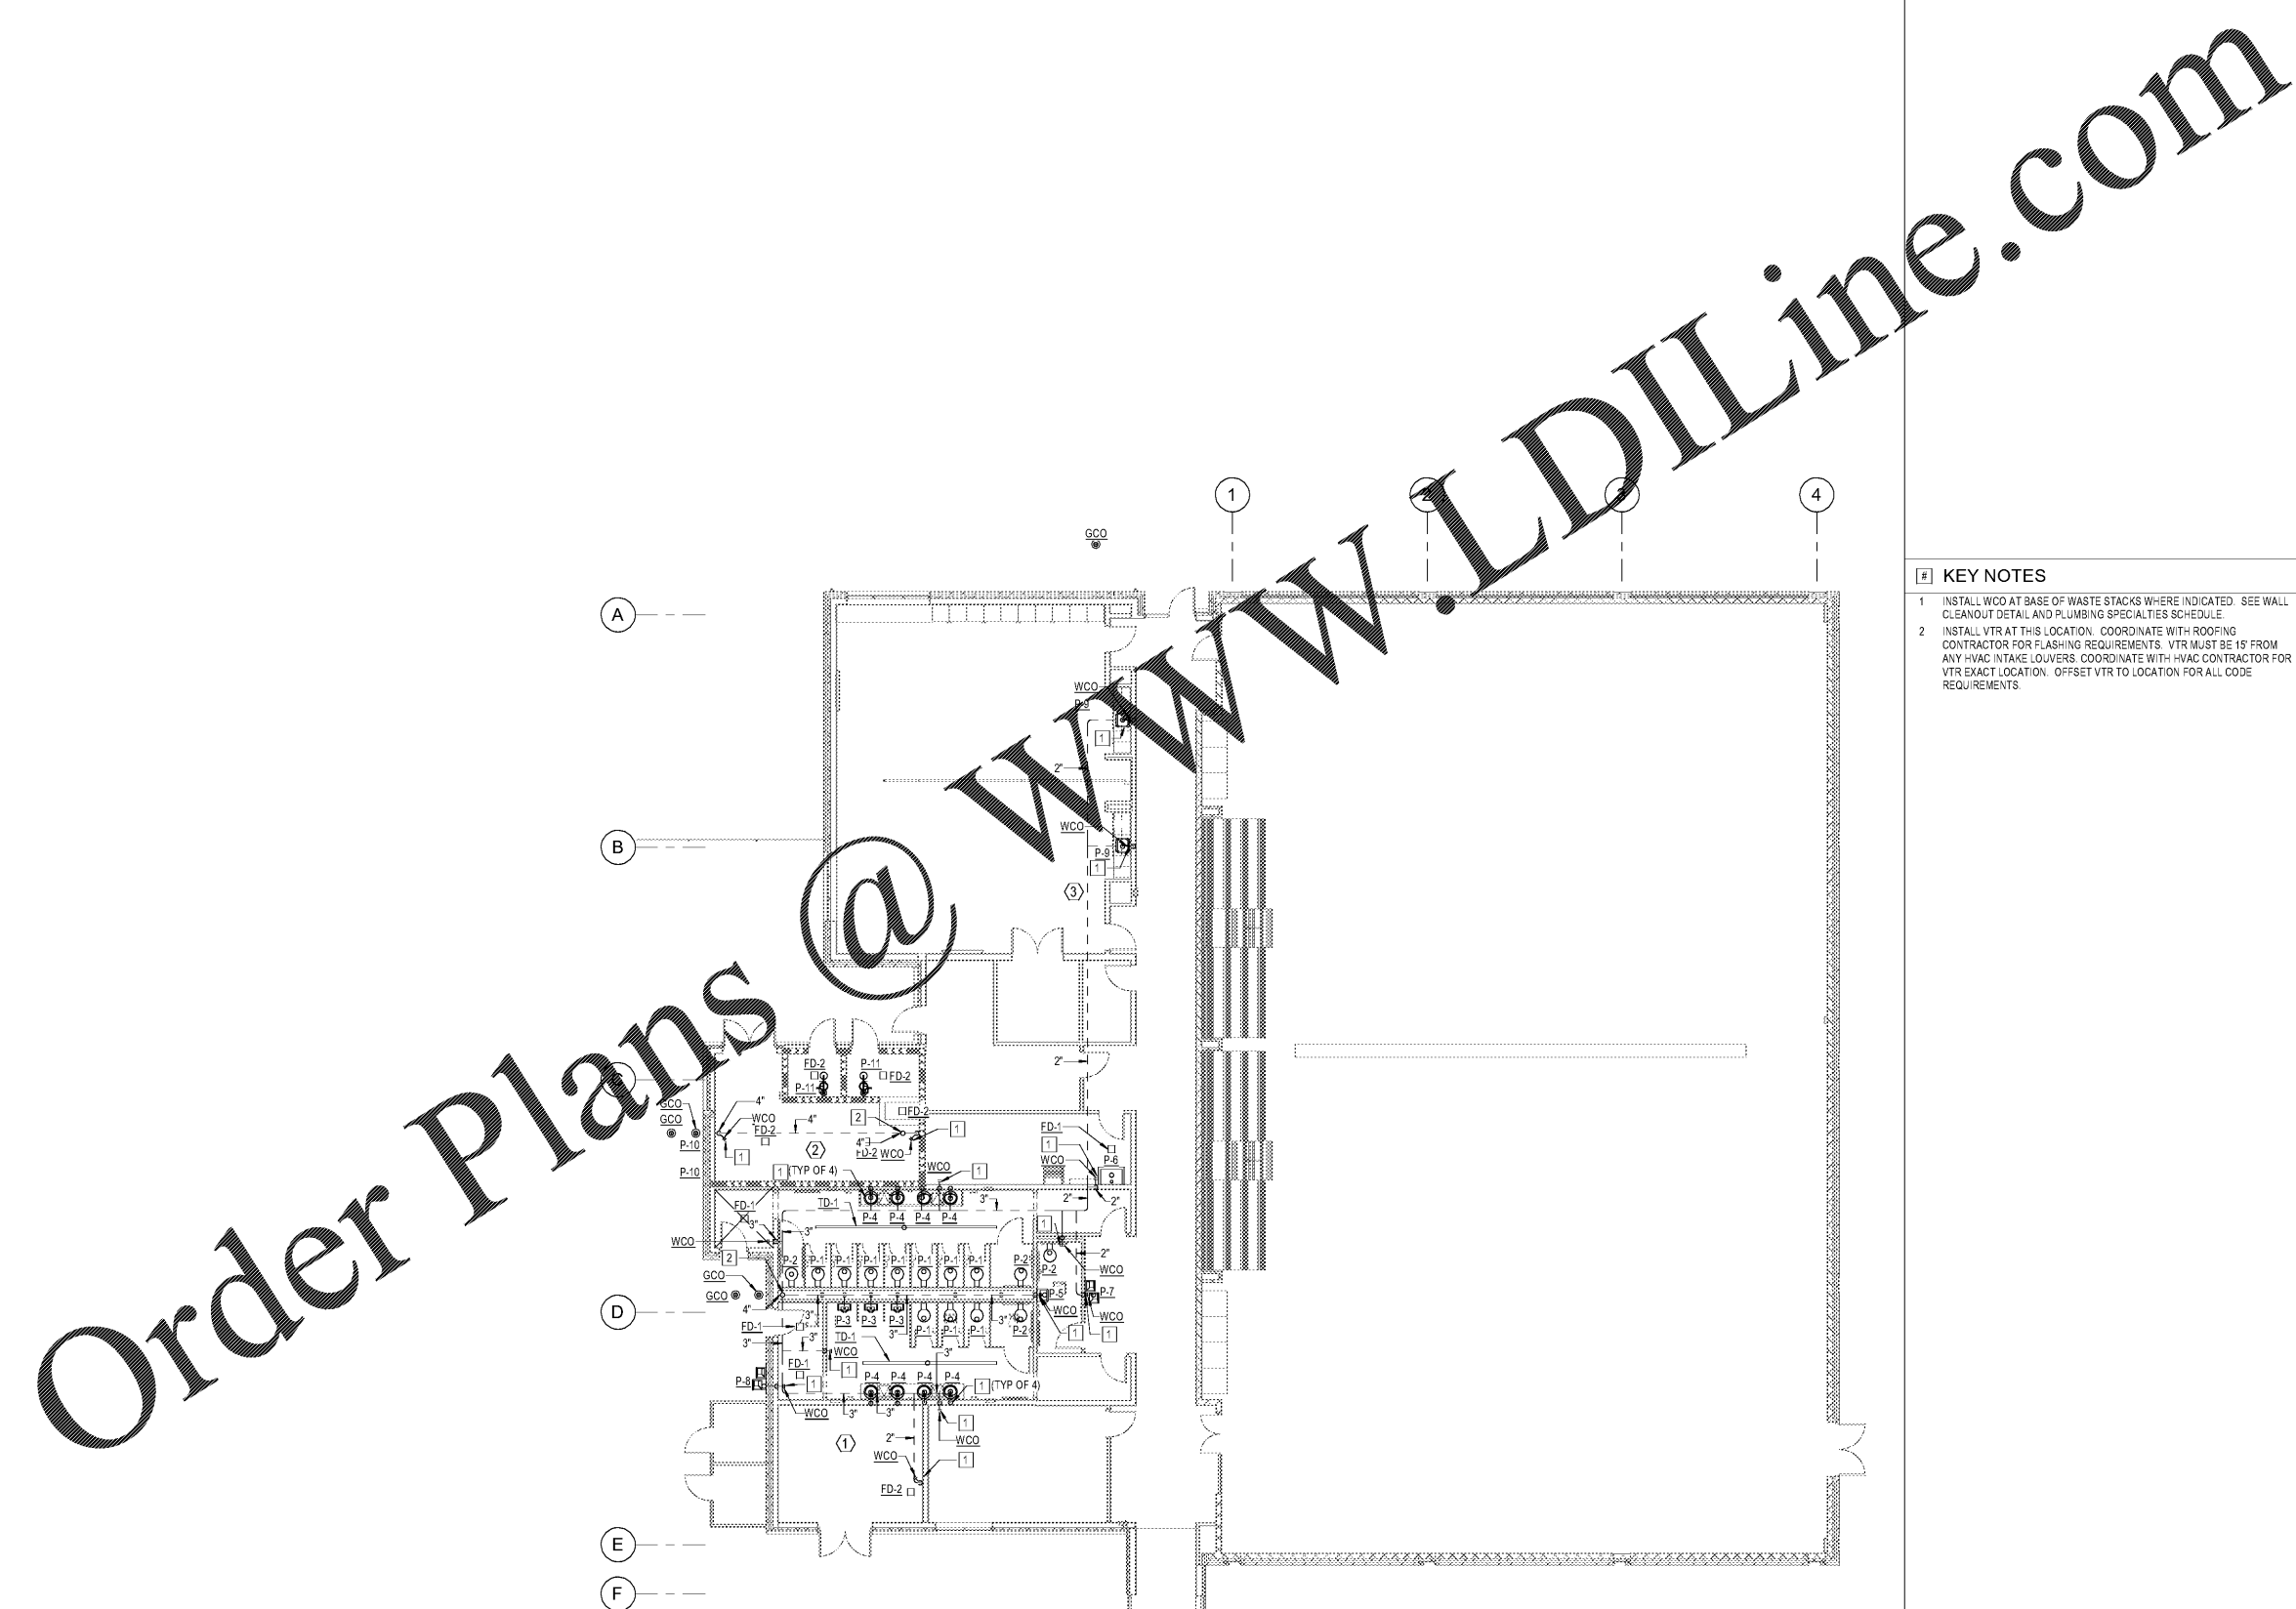

 FIRST FLOOR PLAN - SANITARY AND VENT PIPING
 1/8" = 1'-0"



3/11/2021 4:54:52 PM
 C:\Users\dmurphy\Documents\17501_Southside Facilities_P18_Drinal_Rodrigo\clarknexsen.com.rvt