



2 TURNED DOWN SLAB DETAIL
S01 SCALE: 1/2" = 1'-0"

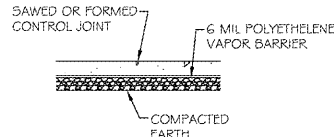


3 CONTROL JOINT DETAIL
S01 SCALE: 1/2" = 1'-0"

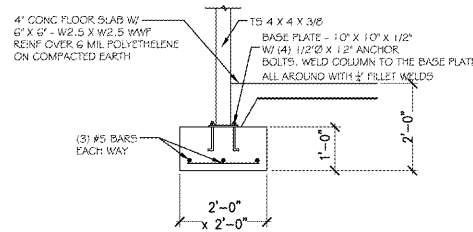

4 COLUMN FOOTING DETAIL
S01 SCALE: 1/2" = 1'-0"

ALL EXTERIOR WALLS ARE SHEAR WALLS. SEE BELOW TABLE FOR SCREW ATTACHMENT. ADD SIMPSON HOLD-DOWN AT EACH CORNER PER BELOW TABLE. SPACE AT 16" FROM THE CORNER.

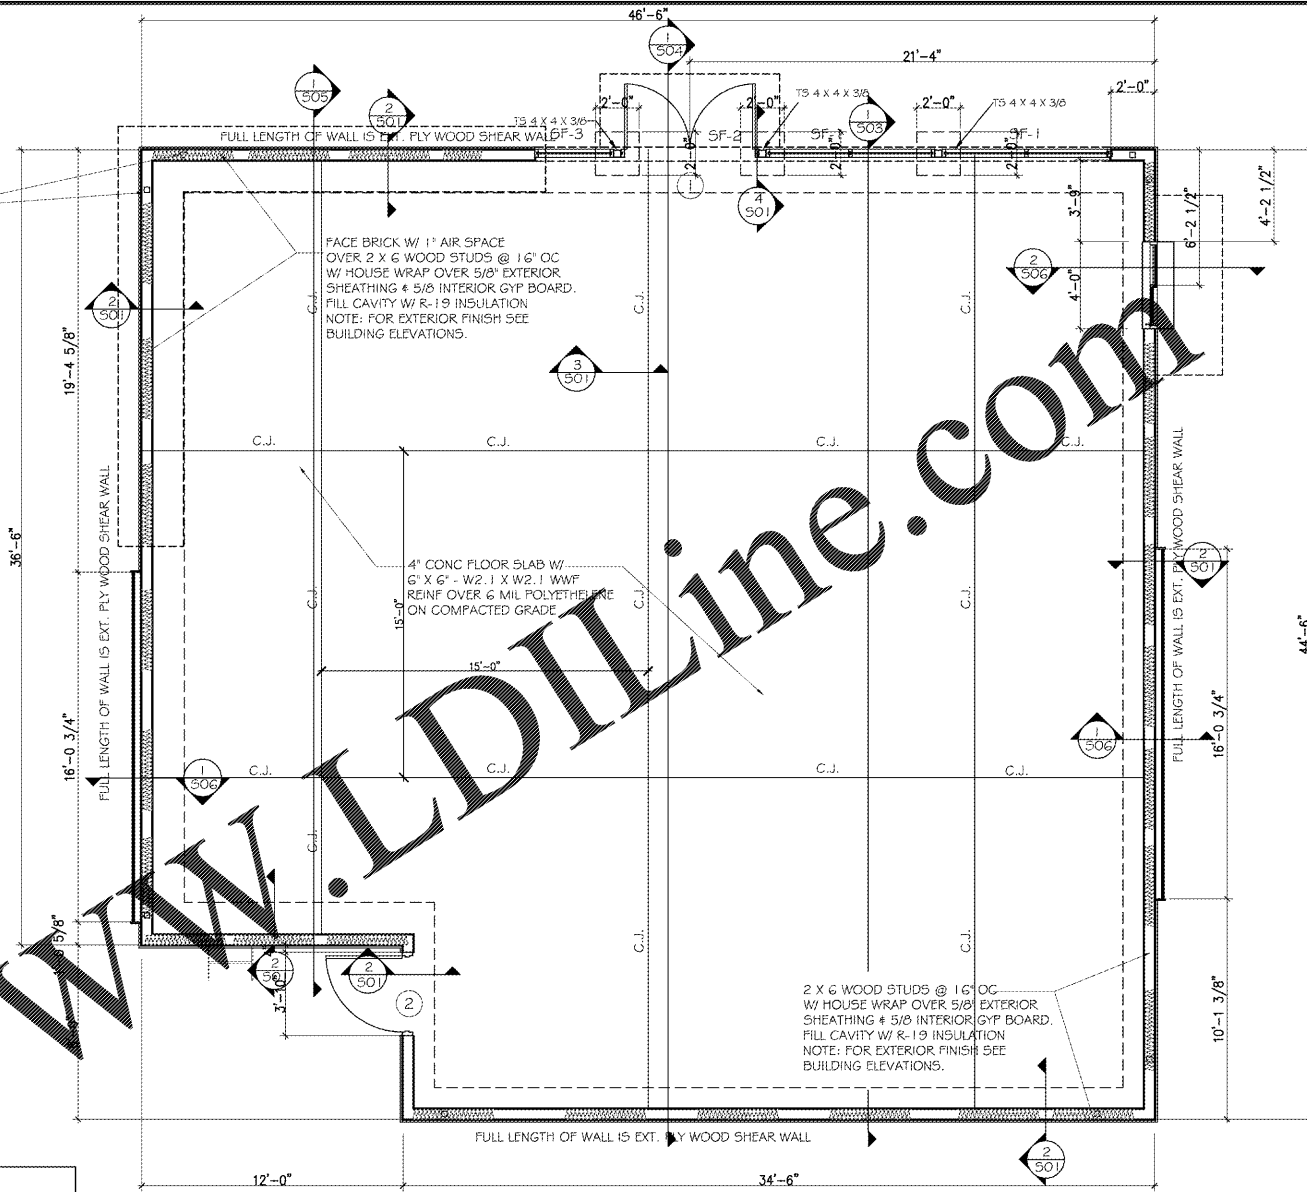

WOOD SHEAR WALL NOTES:

1. HOLD DOWN CONNECTORS SPECIFICATIONS REFER TO SIMPSON STRONG TIE.

WOOD SHEAR WALL SCHEDULE

MARK	SHEATHING	SHEATHING ATTACHMENT	WALL FACE ATTACHMENT	BOTTOM PLATE ATTACHMENT	VERTICAL STUDS AT END OF SHEARWALL	BLOCKING	HOLD-DOWN CONNECTORS AT END OF SHEARWALL
SHEAR WALL	5/8" EXTERIOR PLYWOOD (APA RATED SHEATHING)	10d COMMON NAILS @ 4" O.C. PANEL EDGES 6" O.C. IN FIELD	EXTERIOR SIDE	1/2"x9" MIN. EMBED. A.B. @ 32" O.C. & 12" MAX. FROM THE END OF WALL	(2) 2x4 SP NO. 2	YES	HDU4-SDS 2.5 @ FOUNDATION W/ (10) SDS 1/4"x2 1/2" SCREWS @ 5/8" x 6" EMBED A.B. AND HILTI HIT-HY200 HAS-1/36 ASTM F1554 GR. 36 INTO CONCRETE FOOTING

GENERAL NOTES & SPECIFICATIONS

- DIMENSIONS ARE FROM STUD TO STUD, FURRING TO STUD UNLESS OTHERWISE NOTED.
- SEE PLUMBING DRAWINGS FOR PLUMBING FIXTURE LOCATIONS & SIZE OF UNDER SLAB PIPING.
- SEE HVAC DRAWINGS FOR SERVICE SIZE AND LOCATION.
- SEE ELECTRICAL DRAWINGS FOR PANEL LOCATION.

1 PROPOSED EXTERIOR WALL LAYOUT (FOUNDATION PLAN)
S01 SCALE: 1/4" = 1'-0"

REVISIONS

Date 1-17-2021
Date 3-23-2021



THIS DOCUMENT, THE IDEAS AND DESIGNS INCORPORATED HEREIN, AS AN INSTRUMENT OF PROFESSIONAL SERVICE, IS THE PROPERTY OF WYNN L. WARNER ARCHITECT AND IS NOT TO BE USED, IN WHOLE OR IN PART, FOR ANY OTHER PROJECT WITHOUT THE WRITTEN AUTHORIZATION OF WYNN L. WARNER ARCHITECT.

WYNN L. WARNER ARCHITECT
5292 CAMDEN LAKE PARKWAY
ACWORTH, GA 30101
(770) 867-6638

Sai Ram Consultants, Inc.
(Structural Engineers)
1230 Nash Lee Drive,
Lilburn GA 30047
Ph. 678-409-0405
Ph. 404-456-3556
msrkukato@gmail.com
www.sai-ram-structural-engineers.com

DUNKIN DONUTS
3020 FIVE FORKS TRICKUM ROAD
LILBURN, GA 30047

Drawn By: W/LW
Checked By: W/SK
Date: August 3, 2020
Job No.: 2020-2019-113
Drawing Number

S01

RELEASED FOR CONSTRUCTION

Order Plans @ WWW.LDILine.com