


Order Plans @ www.LDILine.com

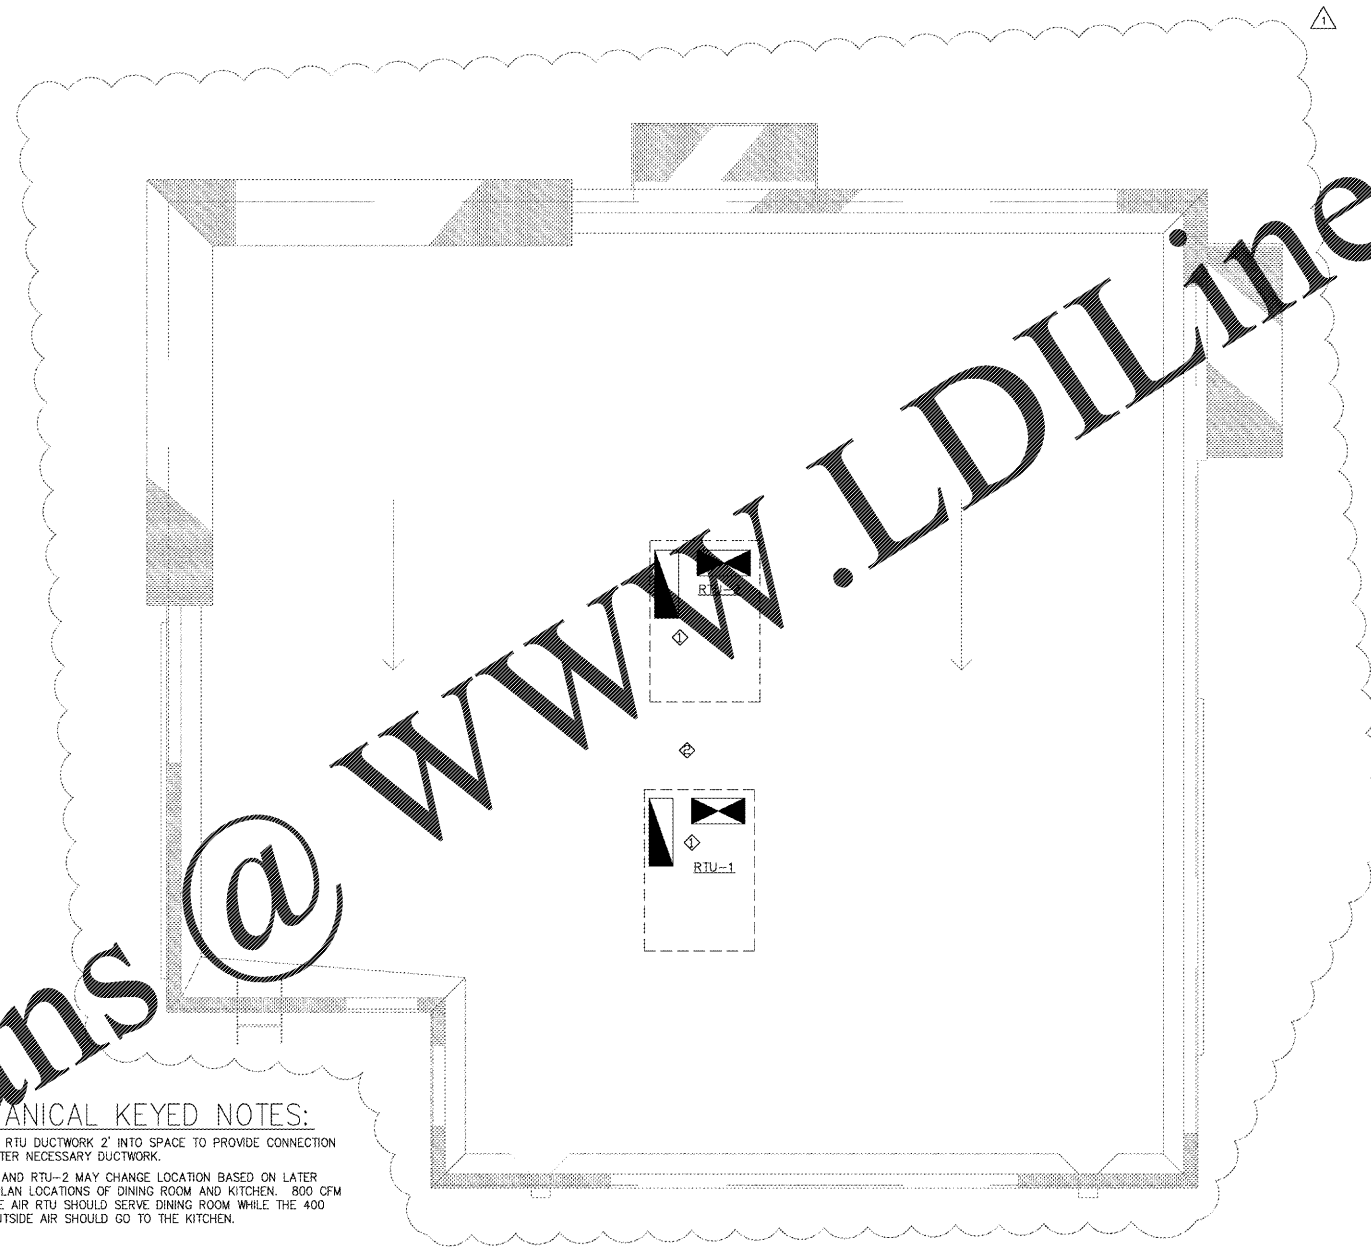

MECHANICAL KEYED NOTES:

- ◇ EXTEND RTU DUCTWORK 2' INTO SPACE TO PROVIDE CONNECTION FOR LATER NECESSARY DUCTWORK.
- ◇ RTU-1 AND RTU-2 MAY CHANGE LOCATION BASED ON LATER FLOORPLAN LOCATIONS OF DINING ROOM AND KITCHEN. 800 CFM OUTSIDE AIR RTU SHOULD SERVE DINING ROOM WHILE THE 400 CFM OUTSIDE AIR SHOULD GO TO THE KITCHEN.

1 HVAC Roof Plan
SCALE: 1/4" = 1'-0"

REVISIONS

Date
 ▲ REVISED ROOF PLAN TO 10/26/2019



THIS DOCUMENT, THE IDEAS AND DESIGNS INCORPORATED HEREIN, AS AN INSTRUMENT OF PROFESSIONAL SERVICE IS THE PROPERTY OF WYNN L. WARNER ARCHITECT AND IS NOT TO BE USED, IN WHOLE OR IN PART, FOR ANY OTHER PROJECT WITHOUT THE WRITTEN AUTHORIZATION OF WYNN L. WARNER ARCHITECT

WYNN L. WARNER ARCHITECT
 5292 CAMDEN LAKE PARKWAY
 ACWORTH, GA 30101
 (770) 367-6638

DUNKIN DONUTS
 3020 FIVE FORKS TRICKUM ROAD
 LILBURN, GA 30047

Drawn By: W.L.W.
 Checked By: W.L.W.
 Date: OCTOBER XX, 2019
 Job No.:
 Drawing Number



M01

RELEASED FOR CONSTRUCTION