

1 SECOND FLOOR PLAN
SCALE: 1/8" = 1'-0"



NOTES:

- 1" CONDENSATE PIPING DOWN THRU FLOOR TO FIRST FLOOR.
- 16"x12" LOUVER AND MOTORIZED DAMPER, RUSKIN MODEL ELF6375DFL, 24V DAMPER MOTOR. PROVIDE BIRDSCREEN. INTERLOCK DAMPER TO OPEN DURING OCCUPIED HOURS.
- REFRIGERANT PIPING UP TO HEAT PUMP ON ROOF. COORDINATE ROUTING IN FIELD.
- 12"x12" LOUVER AND MOTORIZED DAMPER, RUSKIN MODEL ELF6375DFL, 24V DAMPER MOTOR. PROVIDE BIRDSCREEN. INTERLOCK DAMPER TO OPEN DURING OCCUPIED HOURS.



LIFE STORAGE, INC.
Life Storage #497


5800 Brookshire Blvd. · Charlotte, NC 28216

ISSUE	DATE	REVISIONS
1	11/02/2021	ISSUED FOR CLIENT REVIEW
2	1/04/2021	ISSUED FOR BID
3	1/04/2021	ISSUED FOR BID


SECOND FLOOR PLAN

KVD REF NUMBER:
M3.0
SCALE: AS NOTED
DATE: 14SEP2020
JOB NUMBER: 3771

KEVIN R. O'DONNELL, PE
10225 Main Street
Clarence, New York 14031
Phone: (716) 803-8787
Fax: (716) 407-0552 Project # 20-11-02

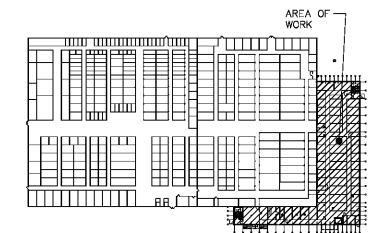

KEY PLAN
SCALE: NONE

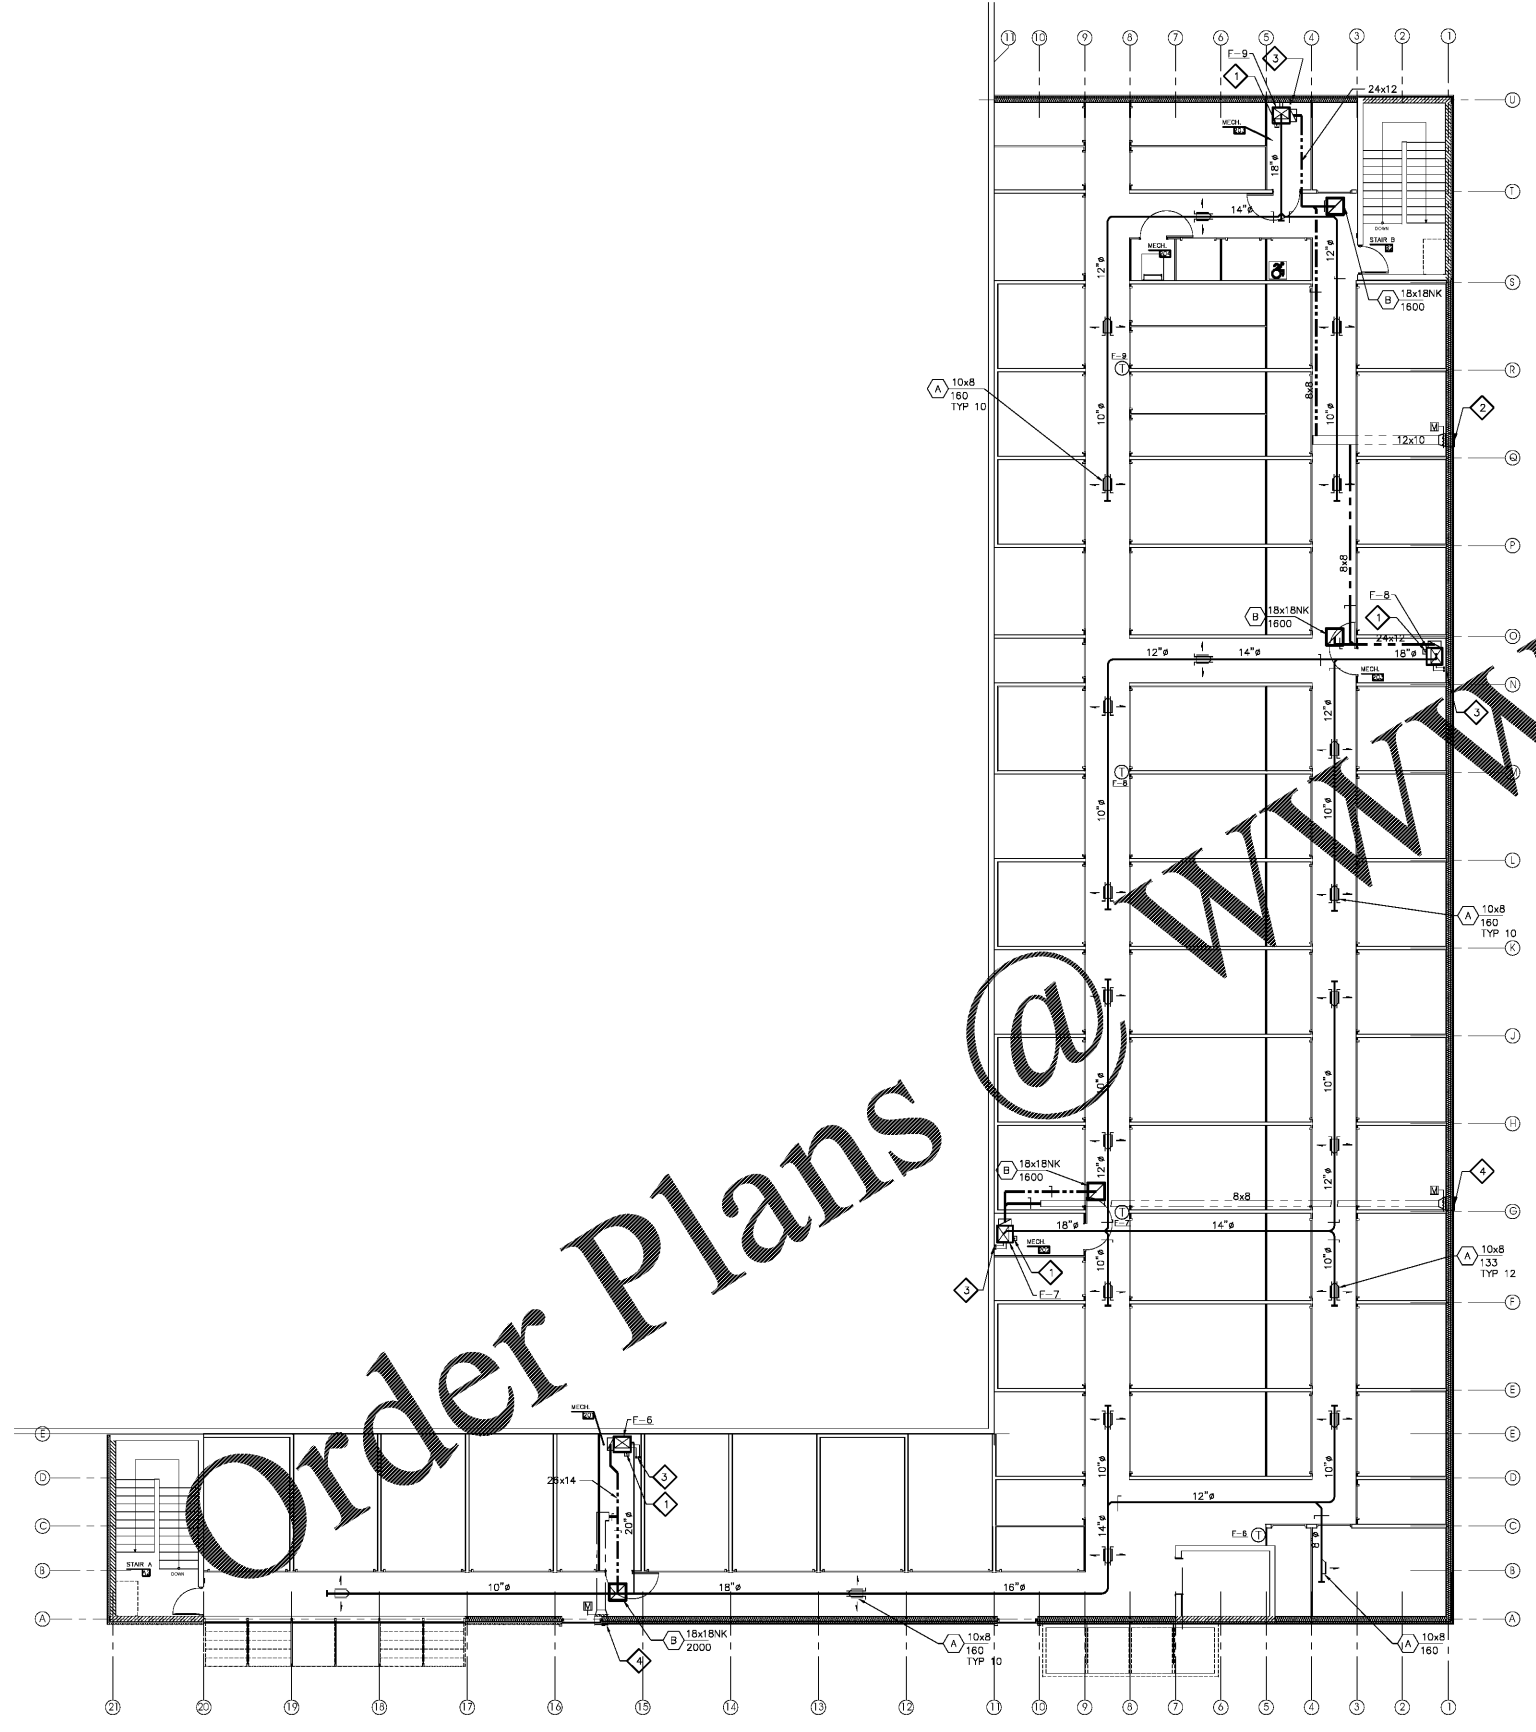

Order Plans @ WWW.LDILine.com