
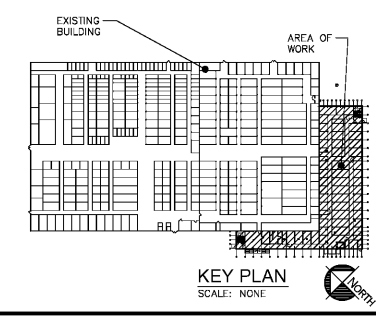


- GENERAL NOTES:**
- HORIZONTAL STORM WATER LINES SLOPED AT 1/8 PER FT. UNLESS NOTED OTHERWISE ON PLANS.
  - RAINFALL IN AREA 3.7 INCHES PER HOUR FOR SIZING STORM WATER LINES.

**DRAWING NOTES:**

- 4" LEADER FROM ROOF DRAIN SUMP TO BELOW
- 4" OVERFLOW LEADER FROM ROOF DRAIN SUMP ON ROOF.

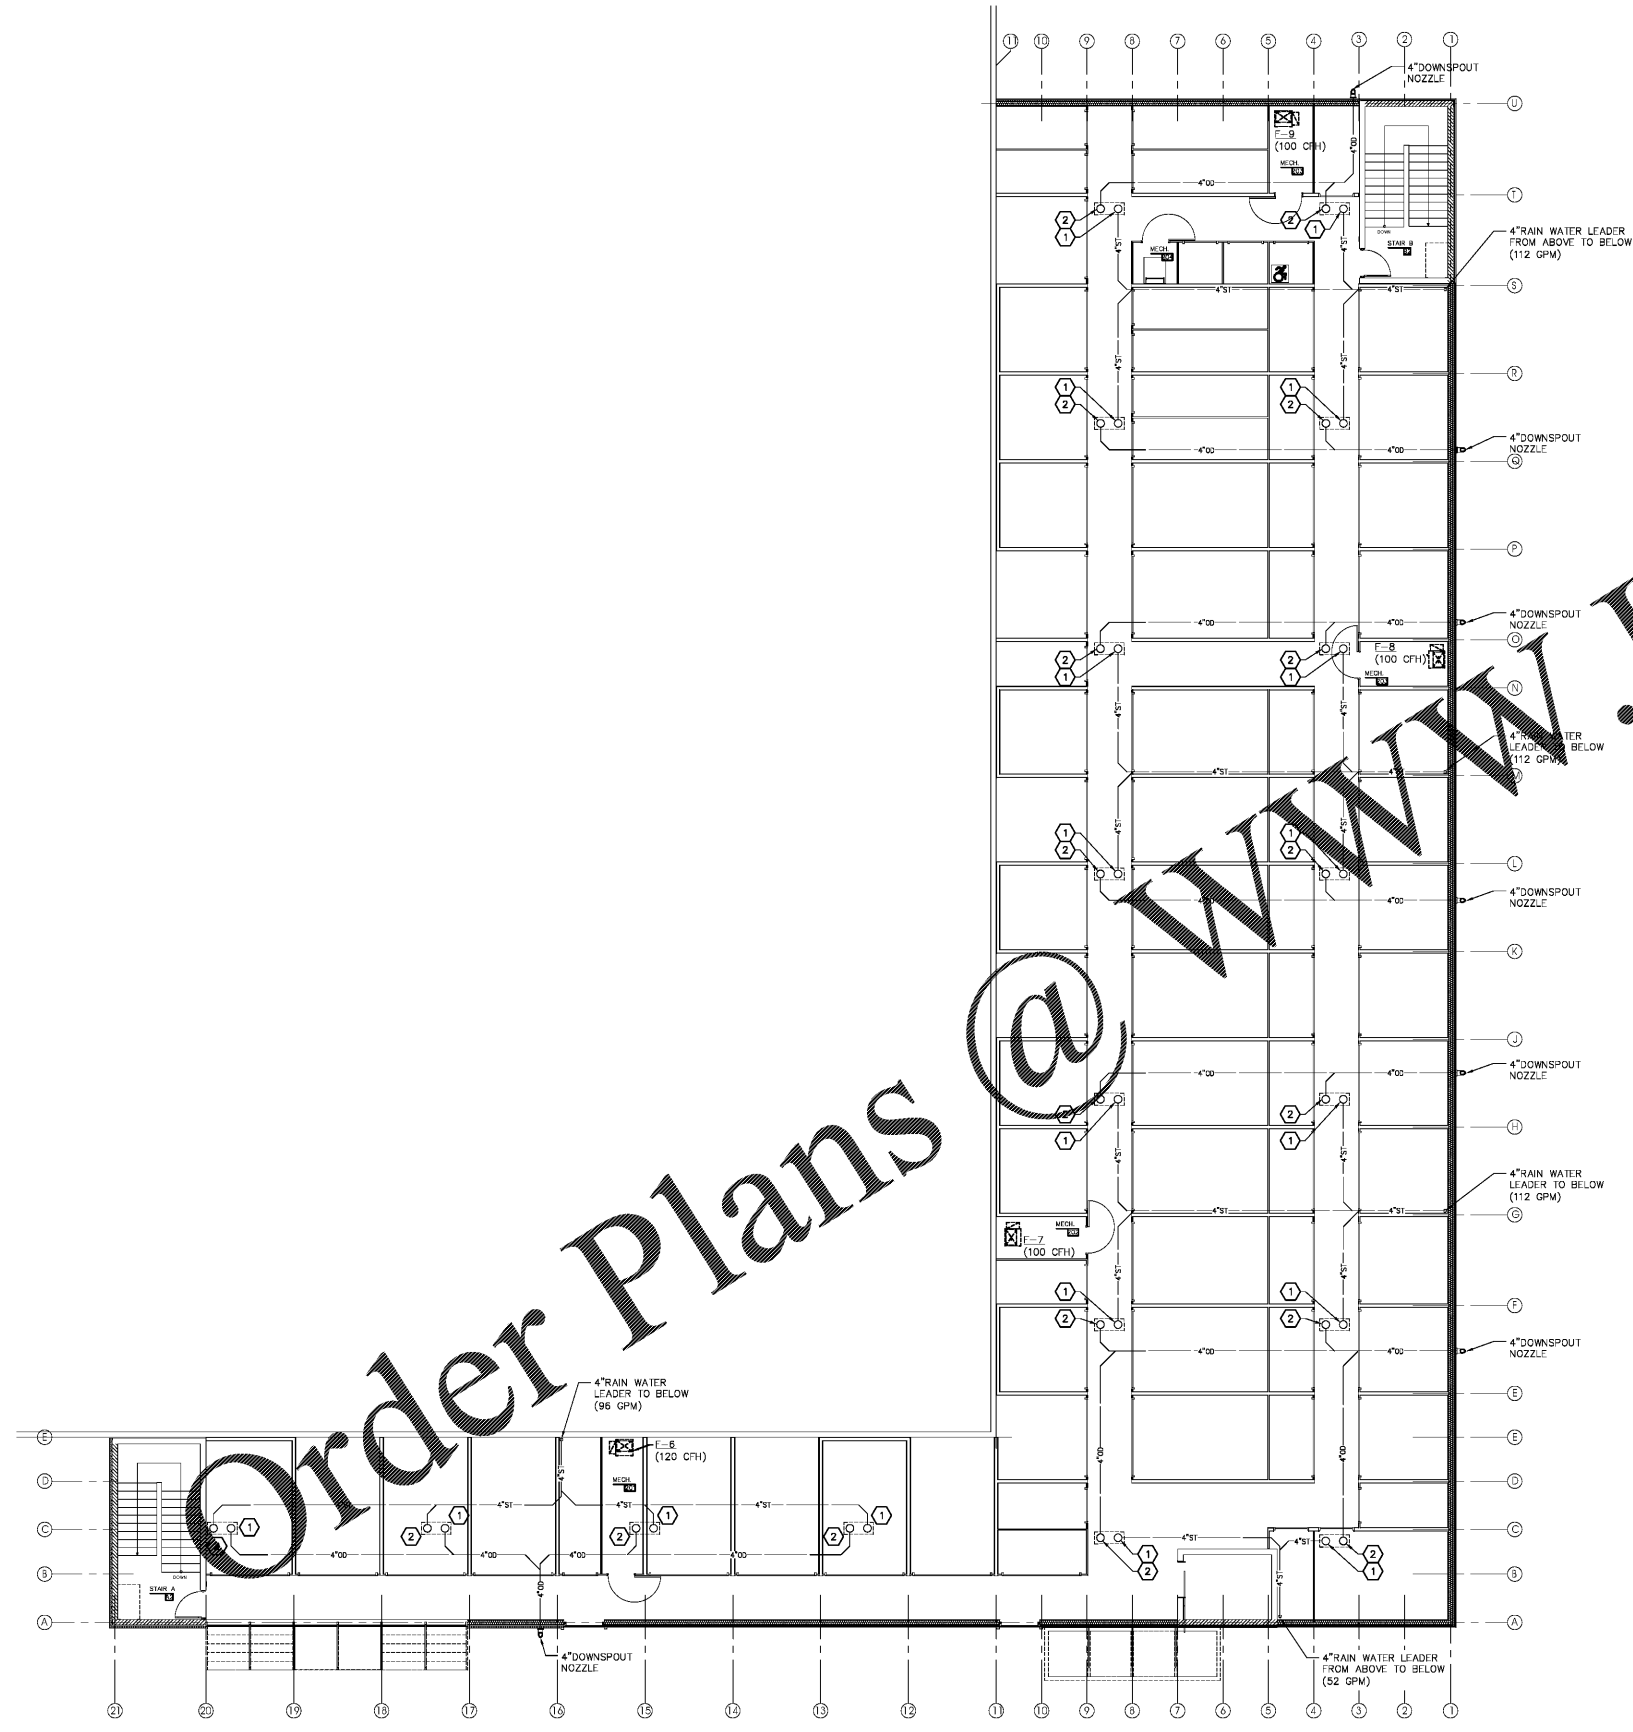

**1 SECOND FLOOR PLAN**  
P3.0 SCALE: 1/8" = 1'-0"



**tmm architect**  
tmm architect  
10225 Main Street  
Clarence, New York 14031  
Phone: (716) 803-8787  
Fax: (716) 407-6552  
www.tmmarchitect.com

**LIFE STORAGE, INC.**  
**Life Storage #497**  
**5800 Brookshire Blvd. · Charlotte, NC 28216**

ISSUE	DATE	REVISIONS
1	11FEB2021	ISSUED FOR CLIENT REVIEW
2	18MAR2021	ISSUED FOR BID
3		

**MECHANICAL PLAN**

KEY PLAN SCALE: NONE

KEVIN R. O'DONNELL, PE  
10225 Main Street  
Clarence, New York 14031  
Phone: (716) 803-8787  
Fax: (716) 407-6552  
Project # 20-11-02

DRAWN BY: KVD  
SCALE: AS NOTED  
DATE: 14SEP2020  
JOB NUMBER: 3771

**P3.0**