



Facilities Management
 1161 West Samford Avenue
 Auburn University, AL 36849
 Phone: (334) 844-4810
 Fax: (334) 844-9458
 Safety is our first priority.
 Think Safety. Act Safely.

No.	Revision	Date



JMR-H
 Architecture, P.C.
 445 Dexter Avenue
 Montgomery, AL 36104
 Phone: (334) 420-5672
 Fax: (334) 420-5682
 JMR-H Project Number: 19-968
 Drawn By: DT


Auburn University Building
 Ham Wilson Arena Renovations
 Project Number 19-451

SHEET TITLE:
 REVISED HVAC PLANS
 - BID ALT #1

DRAWN BY:
 DC
 CHECKED BY:
 RDW
 DATE:
 JANUARY 21, 2021
 FILE NUMBER:

PROJECT NUMBER:
 19-451
 SHEET NUMBER:


M4.2

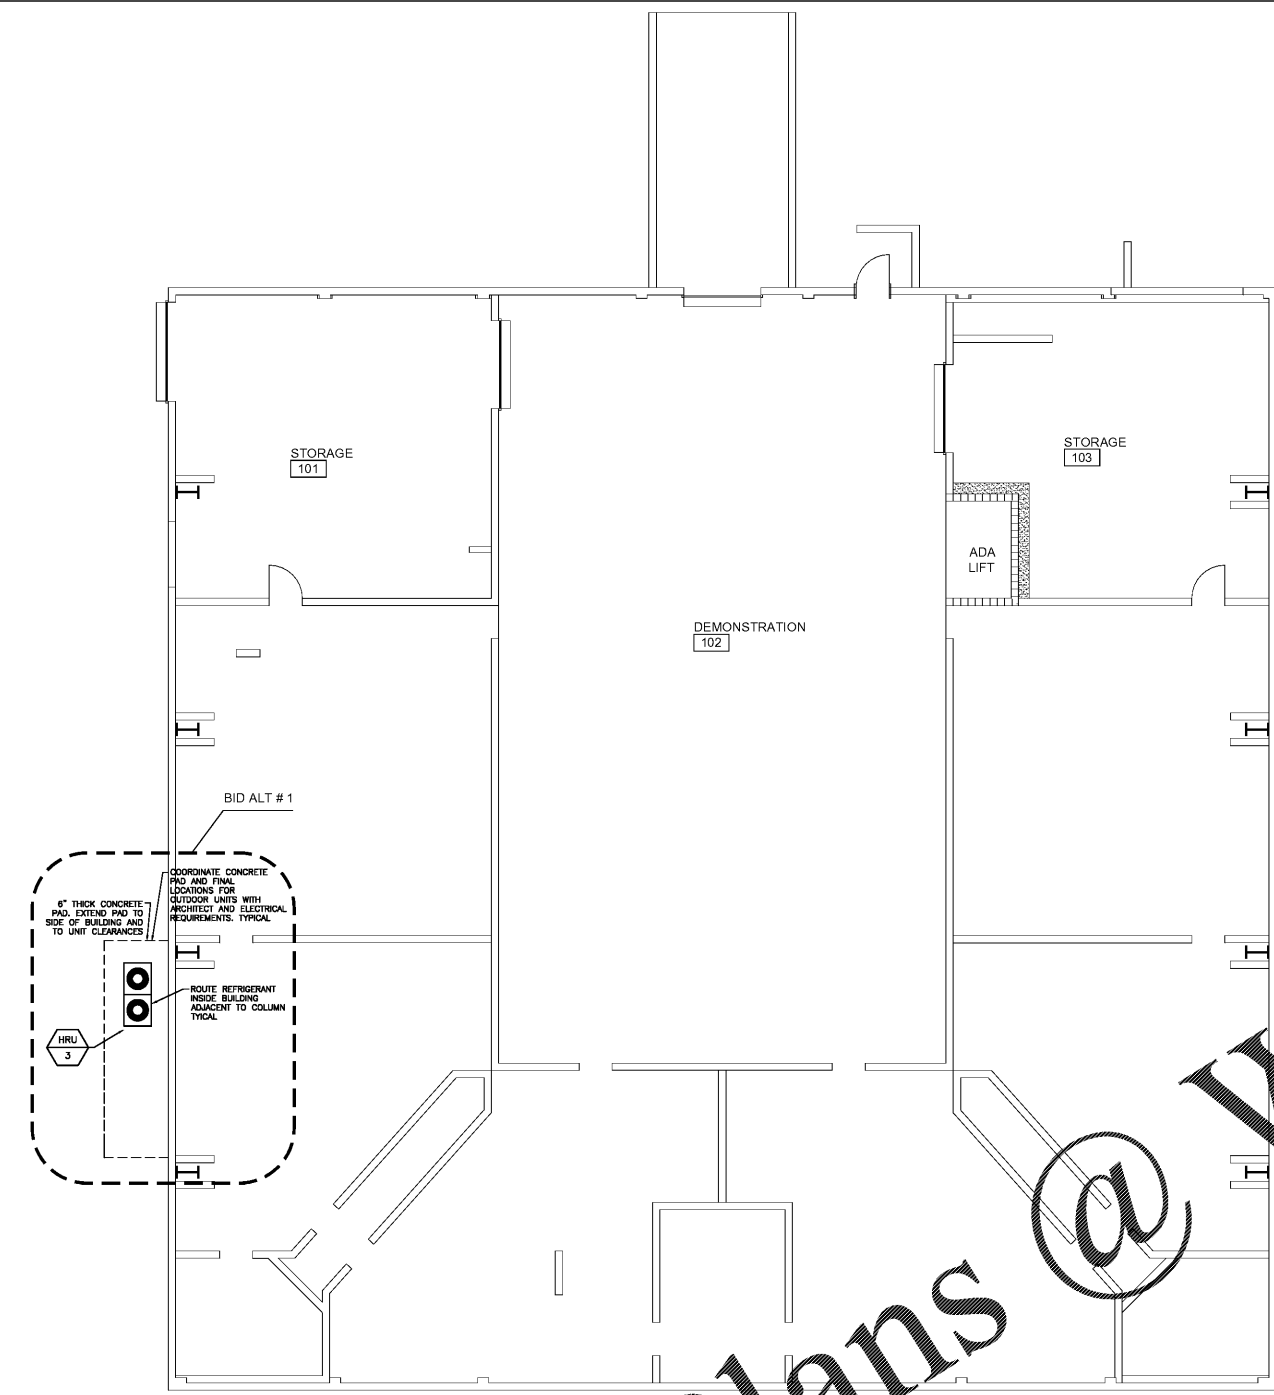

REVISED LOWER FLOOR HVAC PLAN - BID ALT

TAG	Size	Type	Stock Size	Model Number	Manufacturer	Notes
SD-1	24"x24"	SUPPLY	10"	TDC-A	TITUS	ADJUSTABLE DISCHARGE
SD-2	24"x24"	SUPPLY	12"	TDC-A	TITUS	ADJUSTABLE DISCHARGE
AS-1	12"x12"	SUPPLY	6"	TDC-AA	TITUS	ALUMINUM
AS-2	12"x24"	SUPPLY	10"	TDC-AA	TITUS	ALUMINUM
RG	24"x24"	RETURN	23x23	BRF	TITUS	1" FILTER
SWR	36"x60"	RETURN	3.3RFL	TITUS	TITUS	1" FILTER
ATG	24"x24"	TRANSFER	23x23	BF	TITUS	ALUMINUM
OA	24"x24"	O.A.	23x23	BR	TITUS	TITUS


NOTE: FURNISH AND INSTALL AN INSULATION BLANKET ON THE BACK OF ALL CEILING MOUNTED DIFFUSERS AND GRILLES.

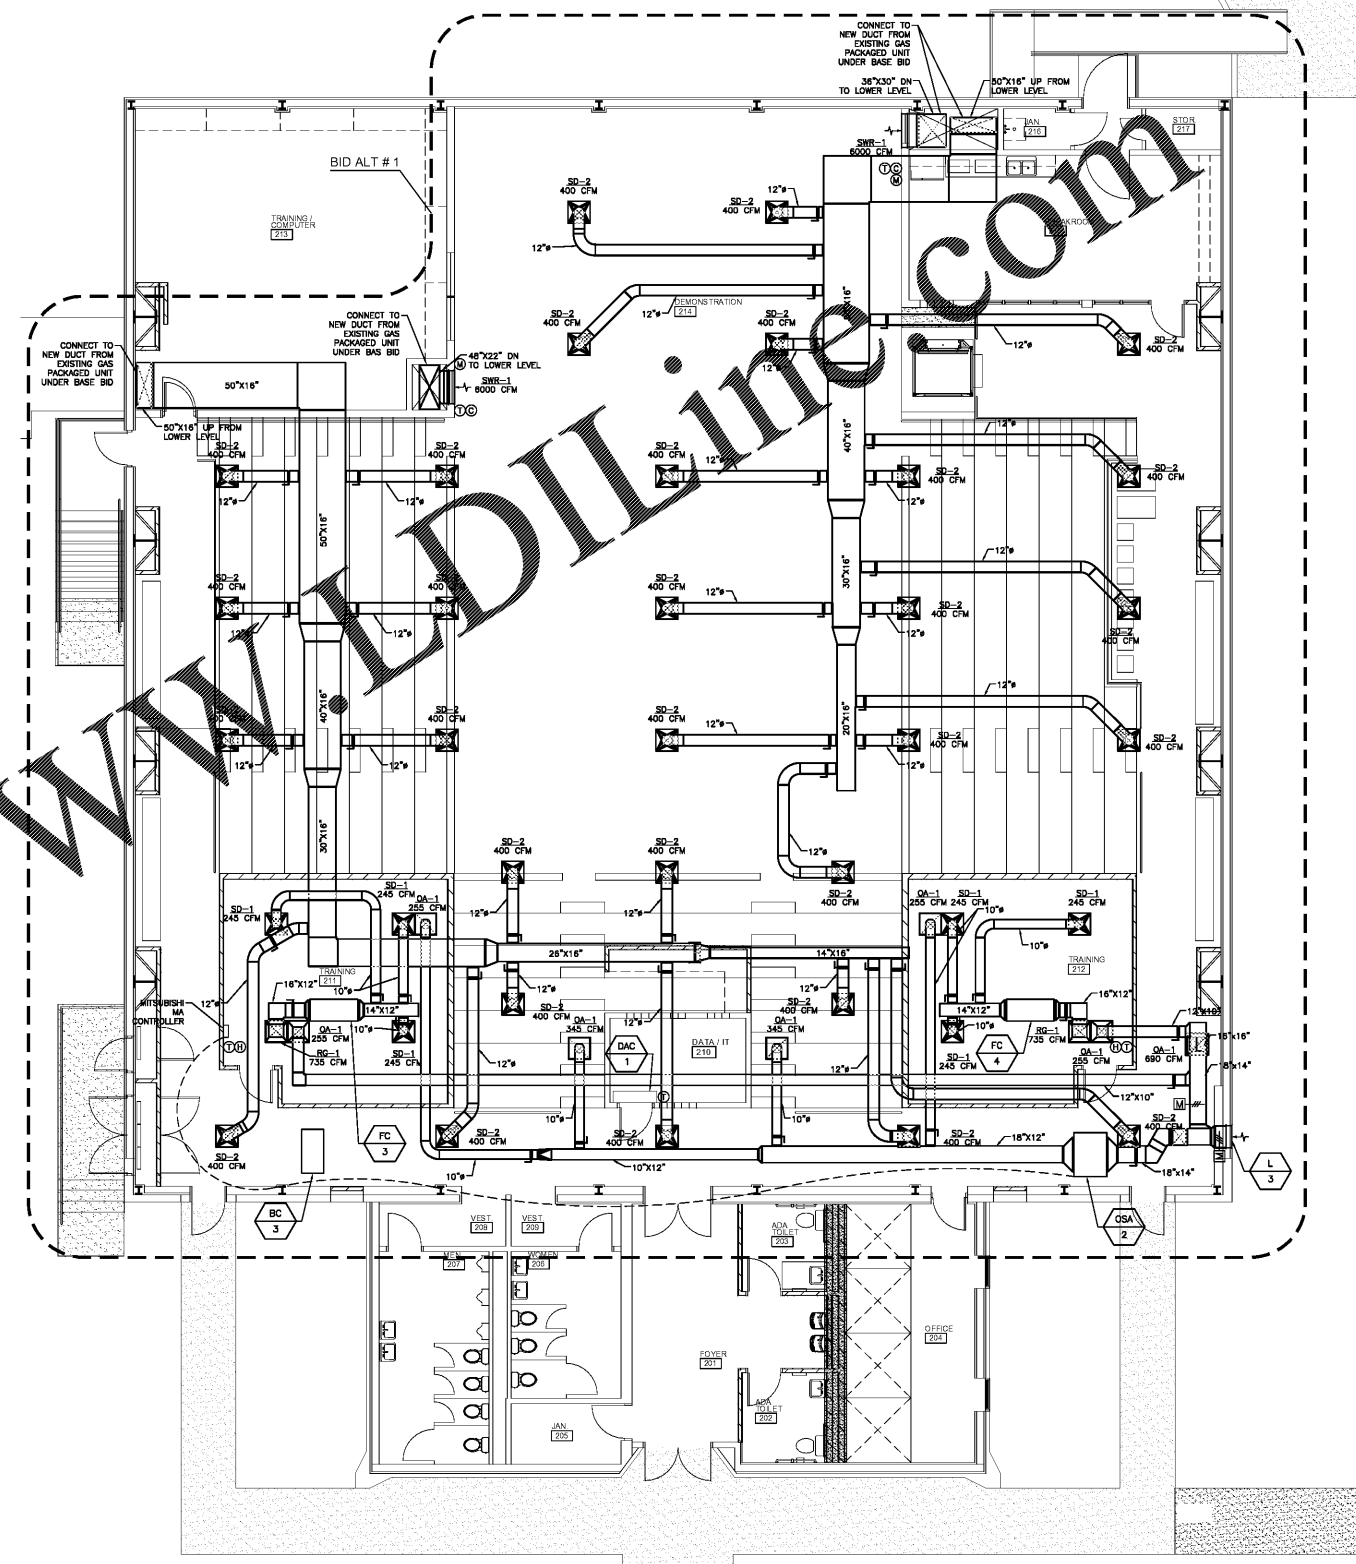

REVISED UPPER FLOOR HVAC PLAN - BID ALT

ALL LOUVERS TO INCLUDE AN 18" DEEP PLENUM BOX AT INTERIOR OF LOUVER. SIZE TO MATCH LOUVER HEIGHT AND WIDTH.

 REFERENCE PLUMBING PLANS FOR CONDENSATE PIPING



REVISED HVAC PLANS - BID ALT

SCALE: 1/8" = 1'-0" 1" = 10'-0"

WHORTON ENGINEERING, INC.
 HVAC - PLUMBING - PROCESS CONTROL

Randee Whorton
 RANDALL WHORTON, P.E.
 PHONE: (256) 820-9887
 DATE: 01-20-2021
 25 SUMMERALL GATE ROAD
 ANNISTON, ALABAMA 36205



WHORTON ENGINEERING PROJECT NO. 19212