



Facilities Management
 1161 West Samford Avenue
 Auburn University, AL 36849
 Phone: (334) 844-4810
 Fax: (334) 844-9458
 Safety is our first priority.
 Think Safety. Act Safely.

No.	Revision	Date




JMR+H
 Architecture, P.C.
 446 Dexter Avenue
 Montgomery, AL 36104
 Phone: (334) 420-5672
 Fax: (334) 420-5662
 JMR+H Project Number: 19-968
 Drawn By: DT

Auburn University Building
 Ham Wilson Arena Renovations
 Project Number 19-451

SHEET TITLE:
LIGHTING PLANS

DRAWN BY:
 SLC
 CHECKED BY:
 SLC
 DATE:
 JANUARY 21, 2021
 FILE NUMBER:
 -
 PROJECT NUMBER:
 19-451
 SHEET NUMBER:

E-3

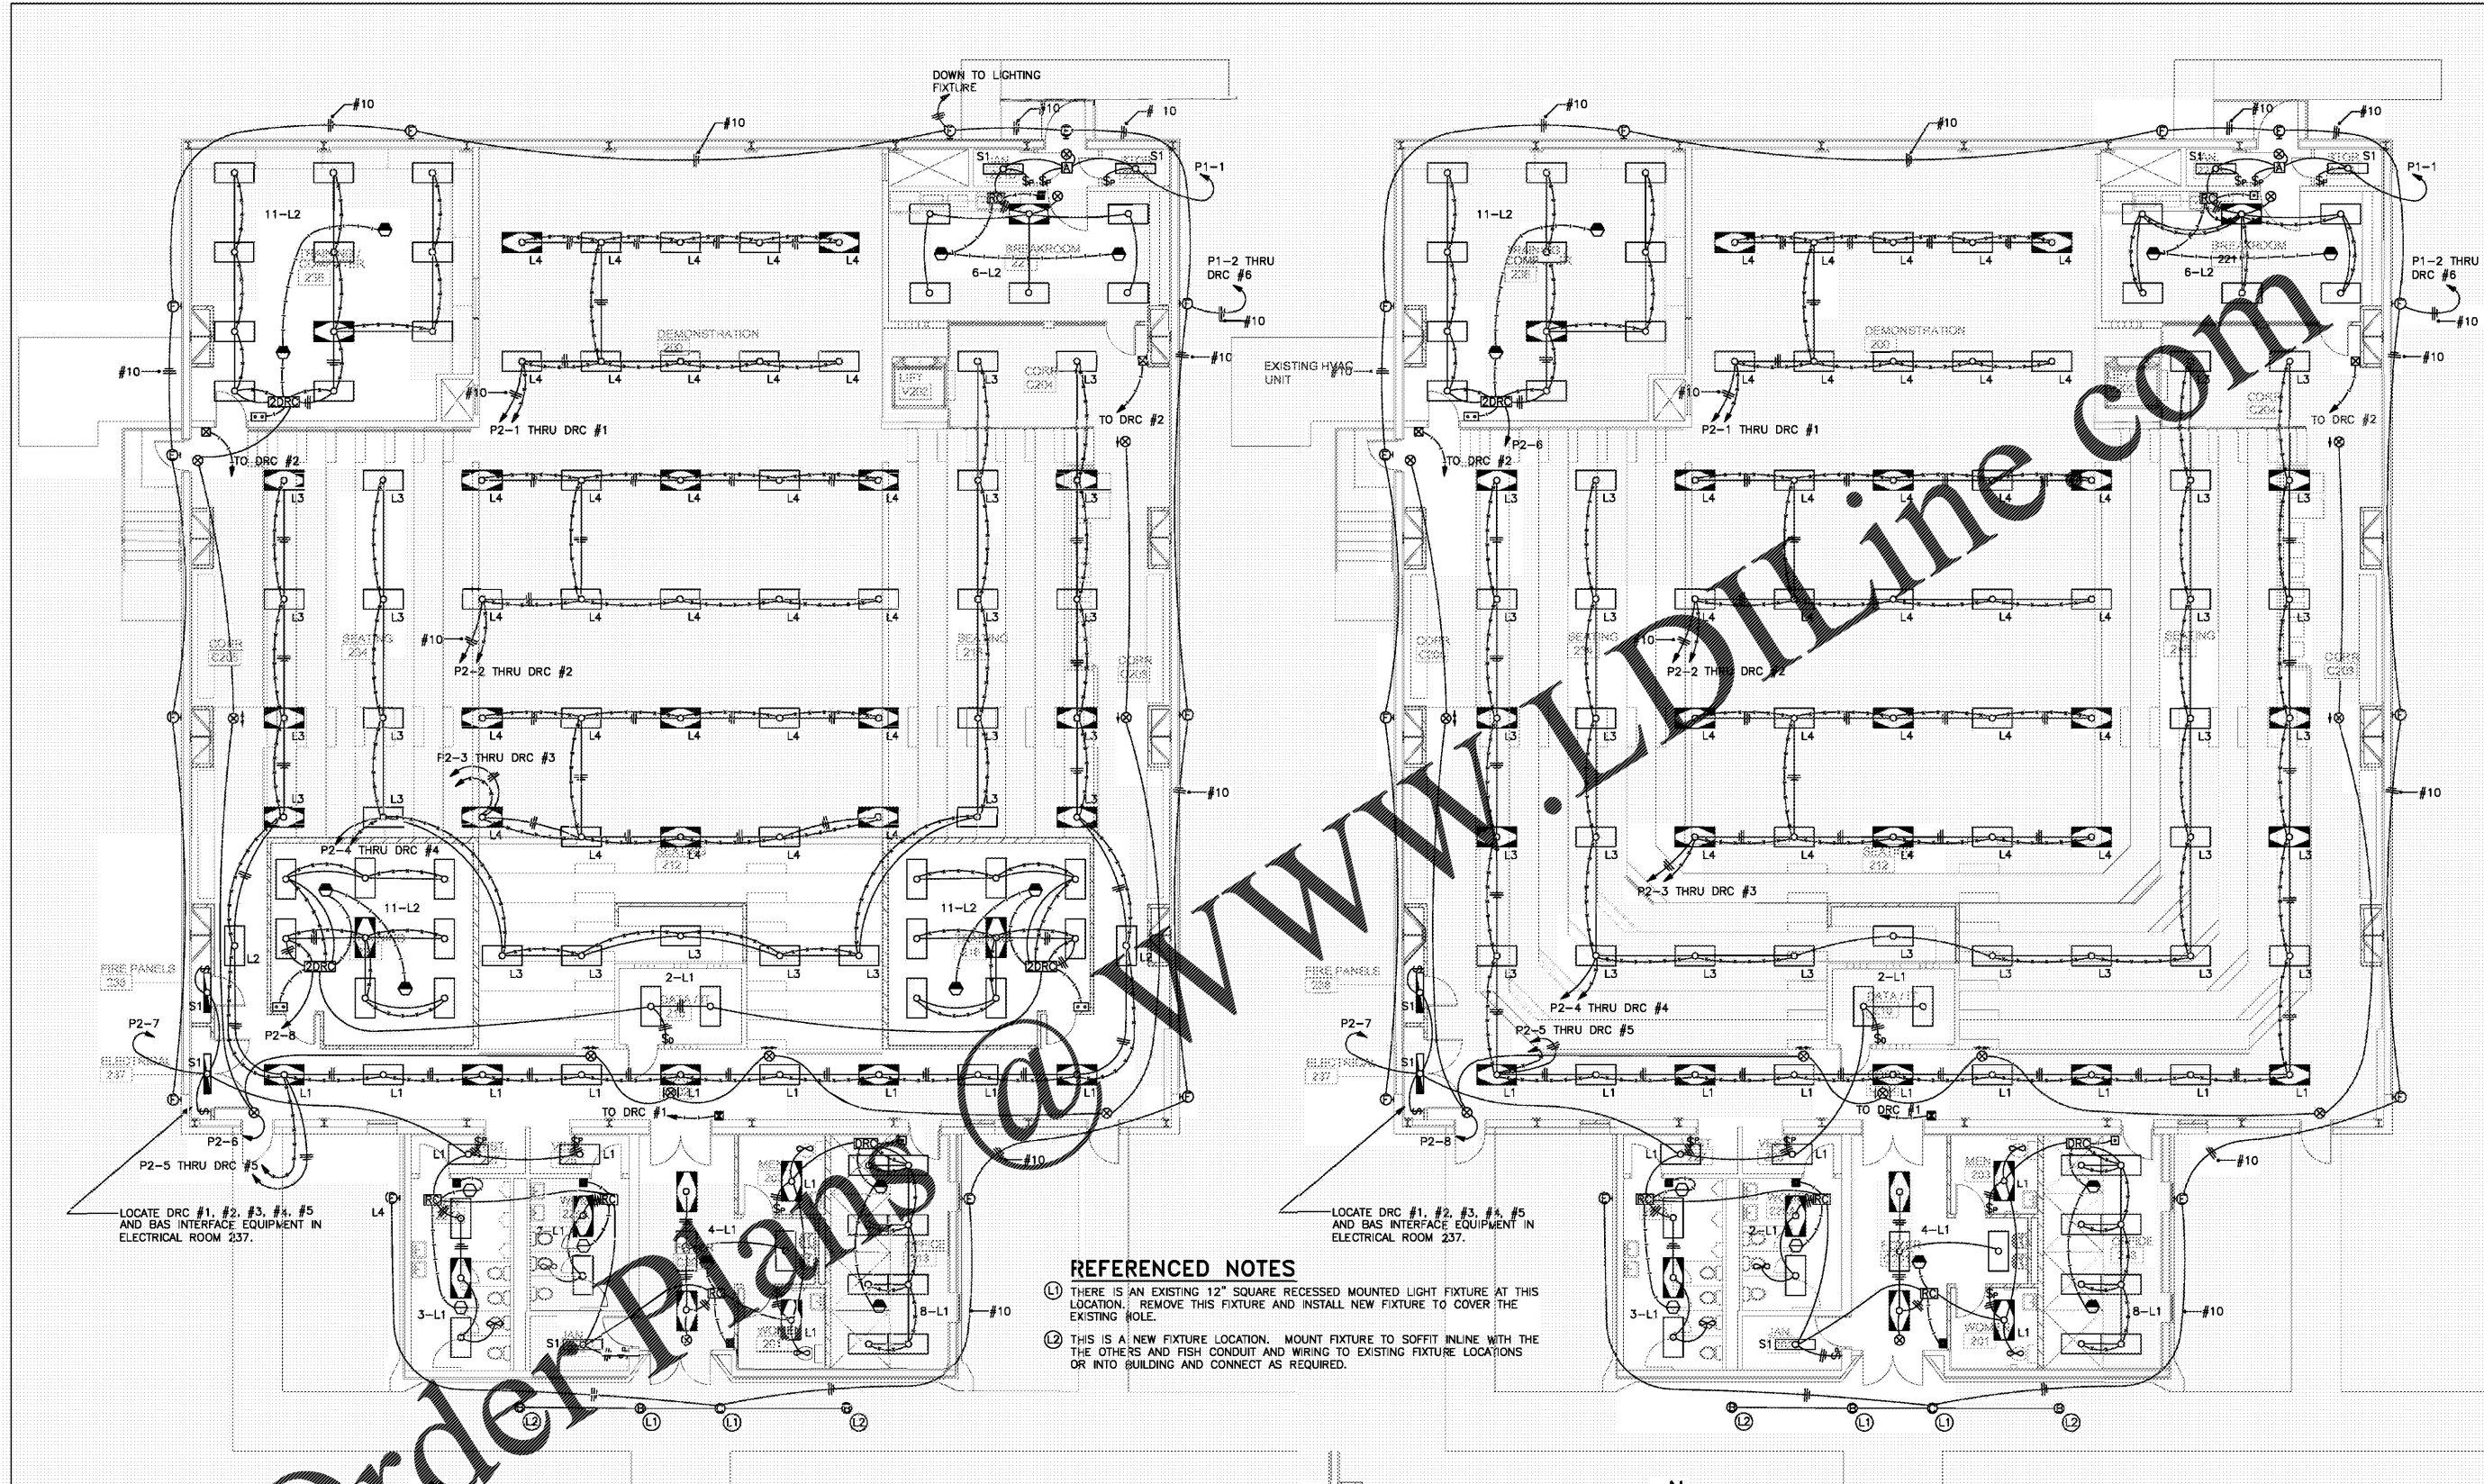

LOCATE DRC #1, #2, #3, #4, #5 AND BAS INTERFACE EQUIPMENT IN ELECTRICAL ROOM 237.

LOCATE DRC #1, #2, #3, #4, #5 AND BAS INTERFACE EQUIPMENT IN ELECTRICAL ROOM 237.

REFERENCED NOTES

- ① THERE IS AN EXISTING 12" SQUARE RECESSED MOUNTED LIGHT FIXTURE AT THIS LOCATION. REMOVE THIS FIXTURE AND INSTALL NEW FIXTURE TO COVER THE EXISTING HOLE.
- ② THIS IS A NEW FIXTURE LOCATION. MOUNT FIXTURE TO SOFFIT IN LINE WITH THE OTHERS AND FISH CONDUIT AND WIRING TO EXISTING FIXTURE LOCATIONS OR INTO BUILDING AND CONNECT AS REQUIRED.

UPPER FLOOR LIGHTING PLAN - ALTERNATE #1
 SCALE: 1/8" = 1'-0"

UPPER FLOOR LIGHTING PLAN - BASE BID
 SCALE: 1/8" = 1'-0"

PARTIAL LIGHTING PLAN - ALTERNATE #3
 SCALE: 1/8" = 1'-0"

LIGHTING CONTROL NOTES

IN THE OFFICE, BREAK ROOM AND THE THREE TRAINING ROOMS THE LIGHTS SHALL TURN ON TO HALF LIGHT LEVELS AUTOMATICALLY WHEN OCCUPANCY IS DETECTED. THE OCCUPANT CAN INCREASE/DECREASE THE LIGHT LEVELS OR TURN THEM OFF MANUALLY. AFTER 20 MINUTES THE LIGHTS WILL AUTOMATICALLY TURN OFF IF NO OCCUPANCY IS DETECTED.

IN VESTIBULES, TOILETS, FOYER, JANITOR, DATA/IT AND STORAGE ROOMS THE LIGHTS SHALL TURN ON AUTOMATICALLY WHEN OCCUPANCY IS DETECTED. THE OCCUPANT CAN TURN THEM OFF MANUALLY. AFTER 20 MINUTES THE LIGHTS WILL AUTOMATICALLY TURN OFF IF NO OCCUPANCY IS DETECTED.

IN THE DEMONSTRATION AND SEATING AREAS THE LIGHTS SHALL TURN ON MANUALLY. THE ENTRY STATIONS SHALL HAVE TWO BUTTONS. EACH BUTTON CAN TOGGLE ON/OFF ONE PROGRAMMED SCENE. THE MULTI-ZONE CONTROLLERS SHALL BE PROGRAMMED FOR SCENES AS DIRECTED BY THE OWNER AND BE ABLE TO RAISE/LOWER EACH ZONE. AT LEAST 1 FOOTCANDLE ON THE PERIMETER WALKWAY SHALL BE PRESENT WHEN ANY LIGHTING IS ON. THE LIGHTS CAN BE TURNED OFF MANUALLY OR AUTOMATICALLY BY A TIME CLOCK OPERATION.

Order Plans @ WWW.DIline.com