




Facilities Management  
 1161 West Samford Avenue  
 Auburn University, AL 36849  
 Phone: (334) 844-4810  
 Fax: (334) 844-9458  
 Safety is our first priority.  
 Think Safety. Act Safely.

No.	Revision	Date

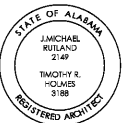

JMR+H Architecture, PC  
 445 Dexter Avenue  
 Montgomery, AL 36104  
 Phone: (334) 420-5672  
 Fax: (334) 420-5692  
 JMR+H Project Number: 19-968  
 Drawn By: DT



Auburn University Building  
 Ham Wilson Arena Renovations  
 Project Number 19-451

SHEET TITLE:  
 PLUMBING  
 RENOVATION -  
 ALTERNATE PLAN

DRAWN BY:  
 RDL  
 CHECKED BY:  
 RDW  
 DATE:  
 JANUARY 21, 2021  
 FILE NUMBER:

PROJECT NUMBER:  
 19-451  
 SHEET NUMBER:

P4.1

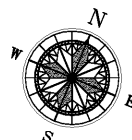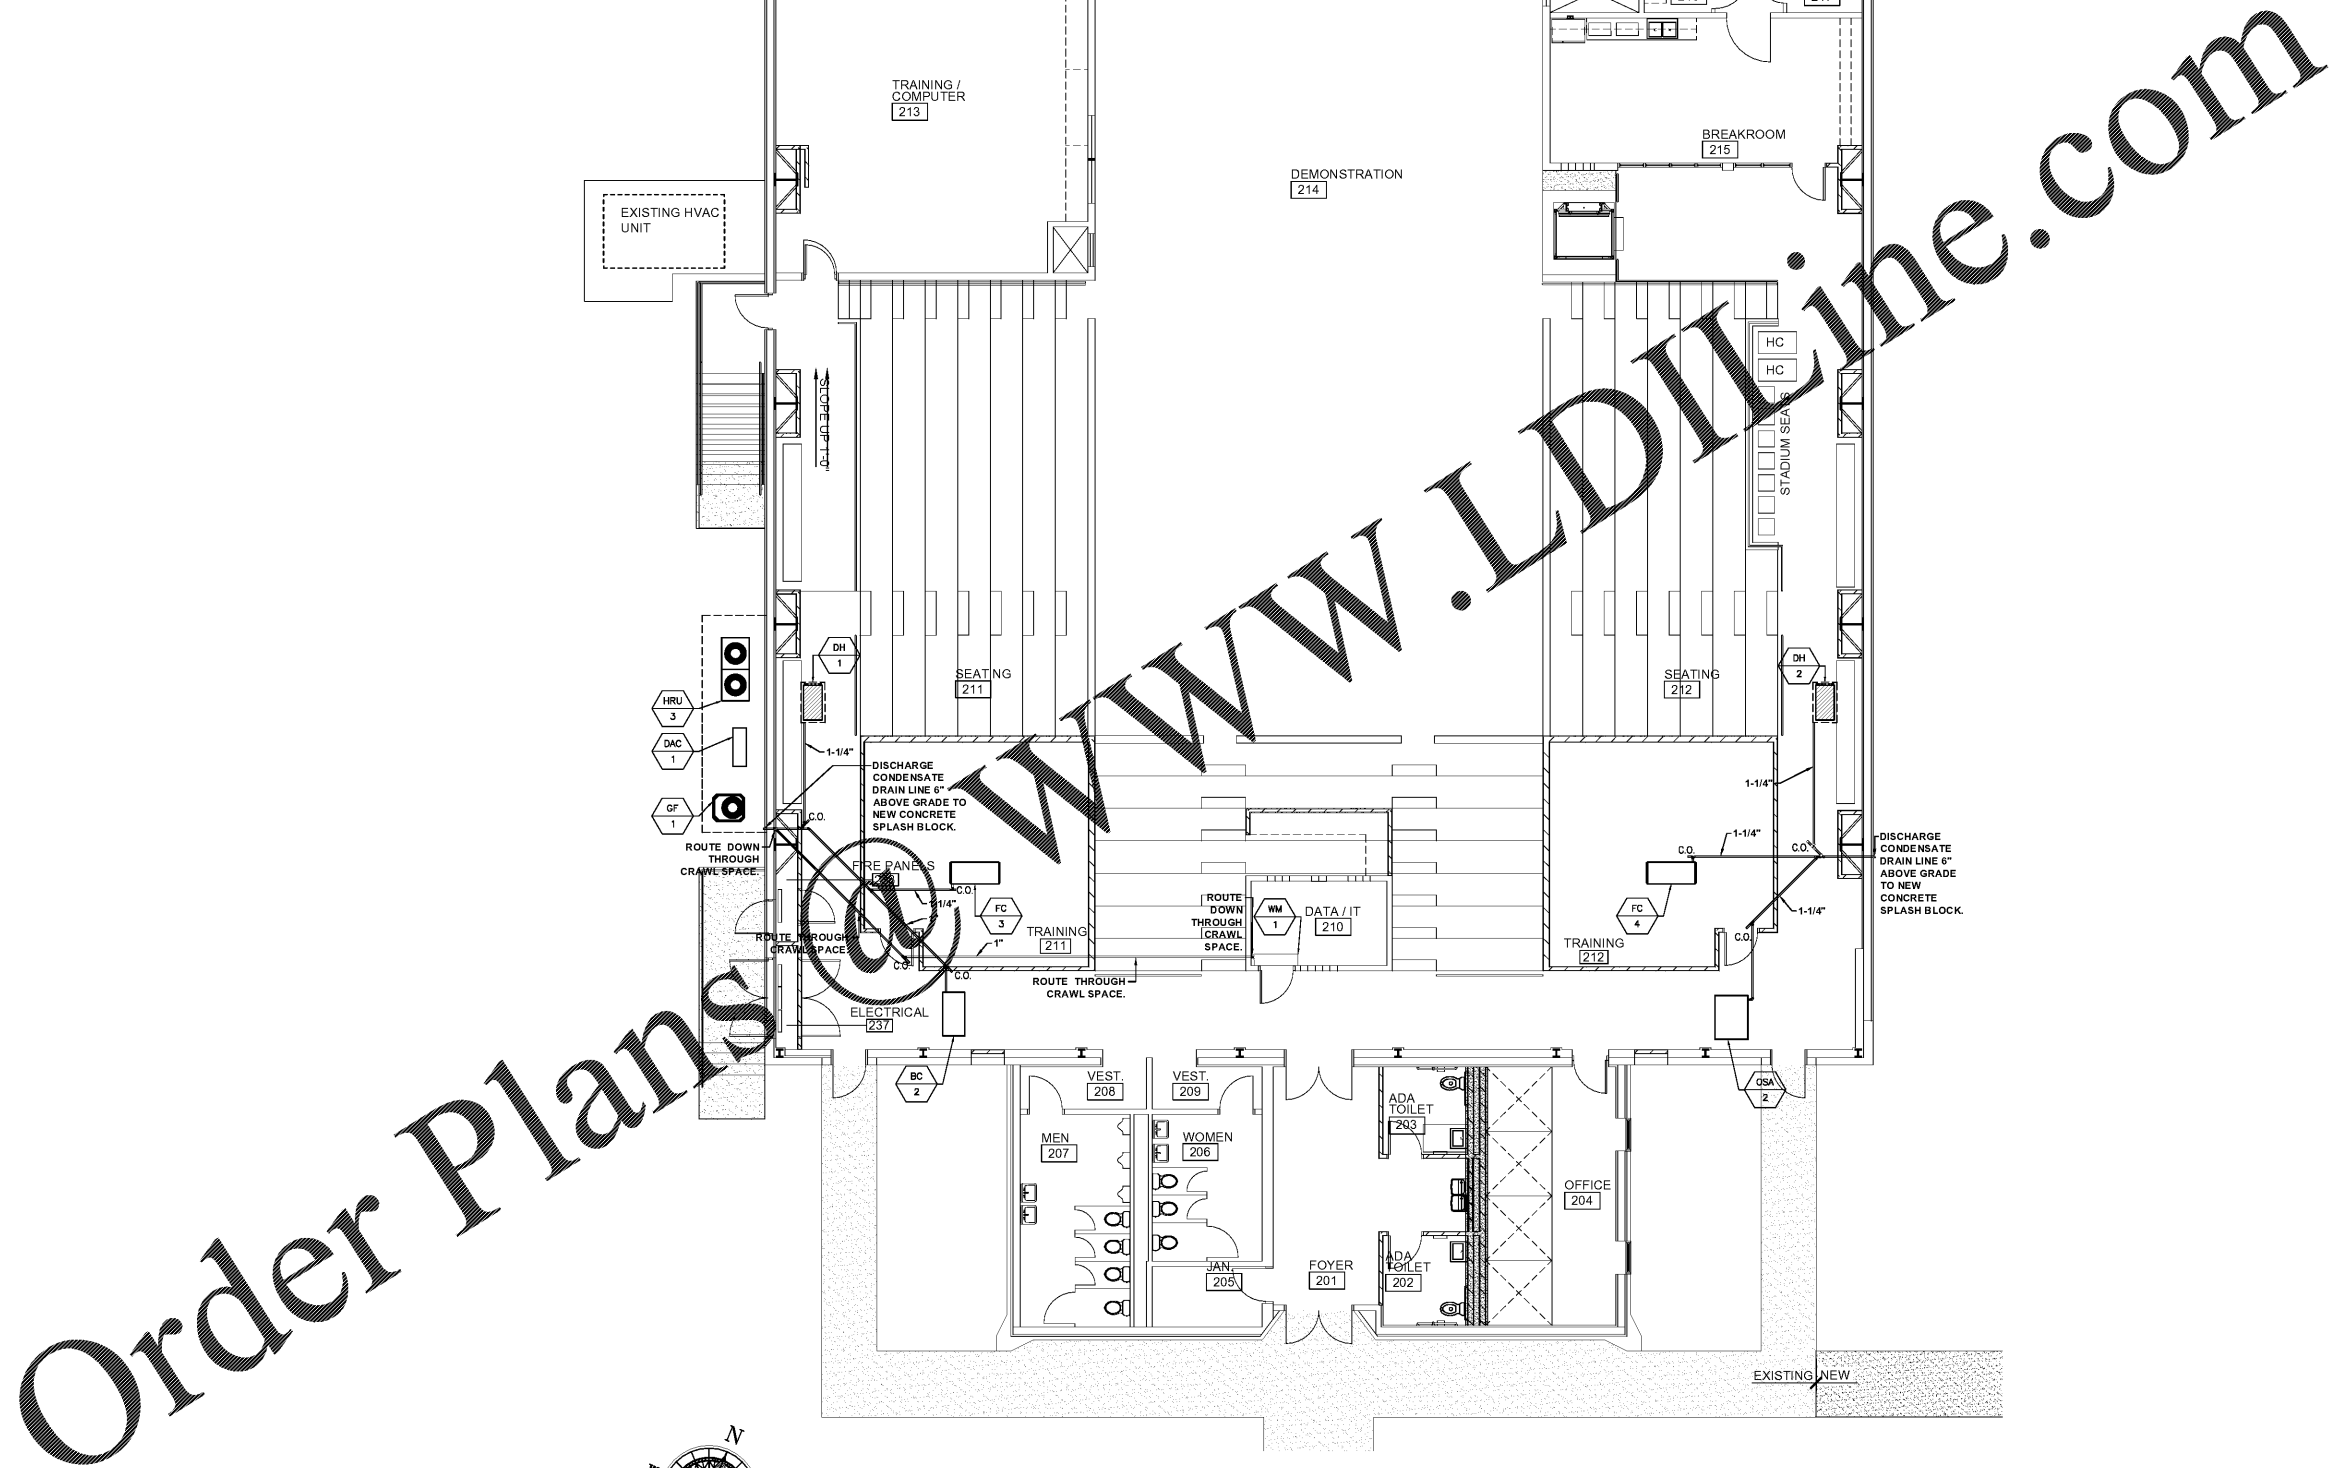

**REVISED CONDENSATE ALTERNATE PLUMBING PLAN**

SCALE: 1/8"=1'-0"

**PLUMBING RENOVATION - ALTERNATE PLAN**

SCALE: 1/8"=1'-0"  
 Scale in feet

**WHORTON ENGINEERING, INC.**

HVAC - PLUMBING - PROCESS CONTROL

*Randall Whorton*  
 RANDALL WHORTON, P.E.  
 PHONE: (256) 820-9897

DATE: 01-20-2021  
 25 SUMMERALL GATE ROAD  
 ANNISTON, ALABAMA 36205

